




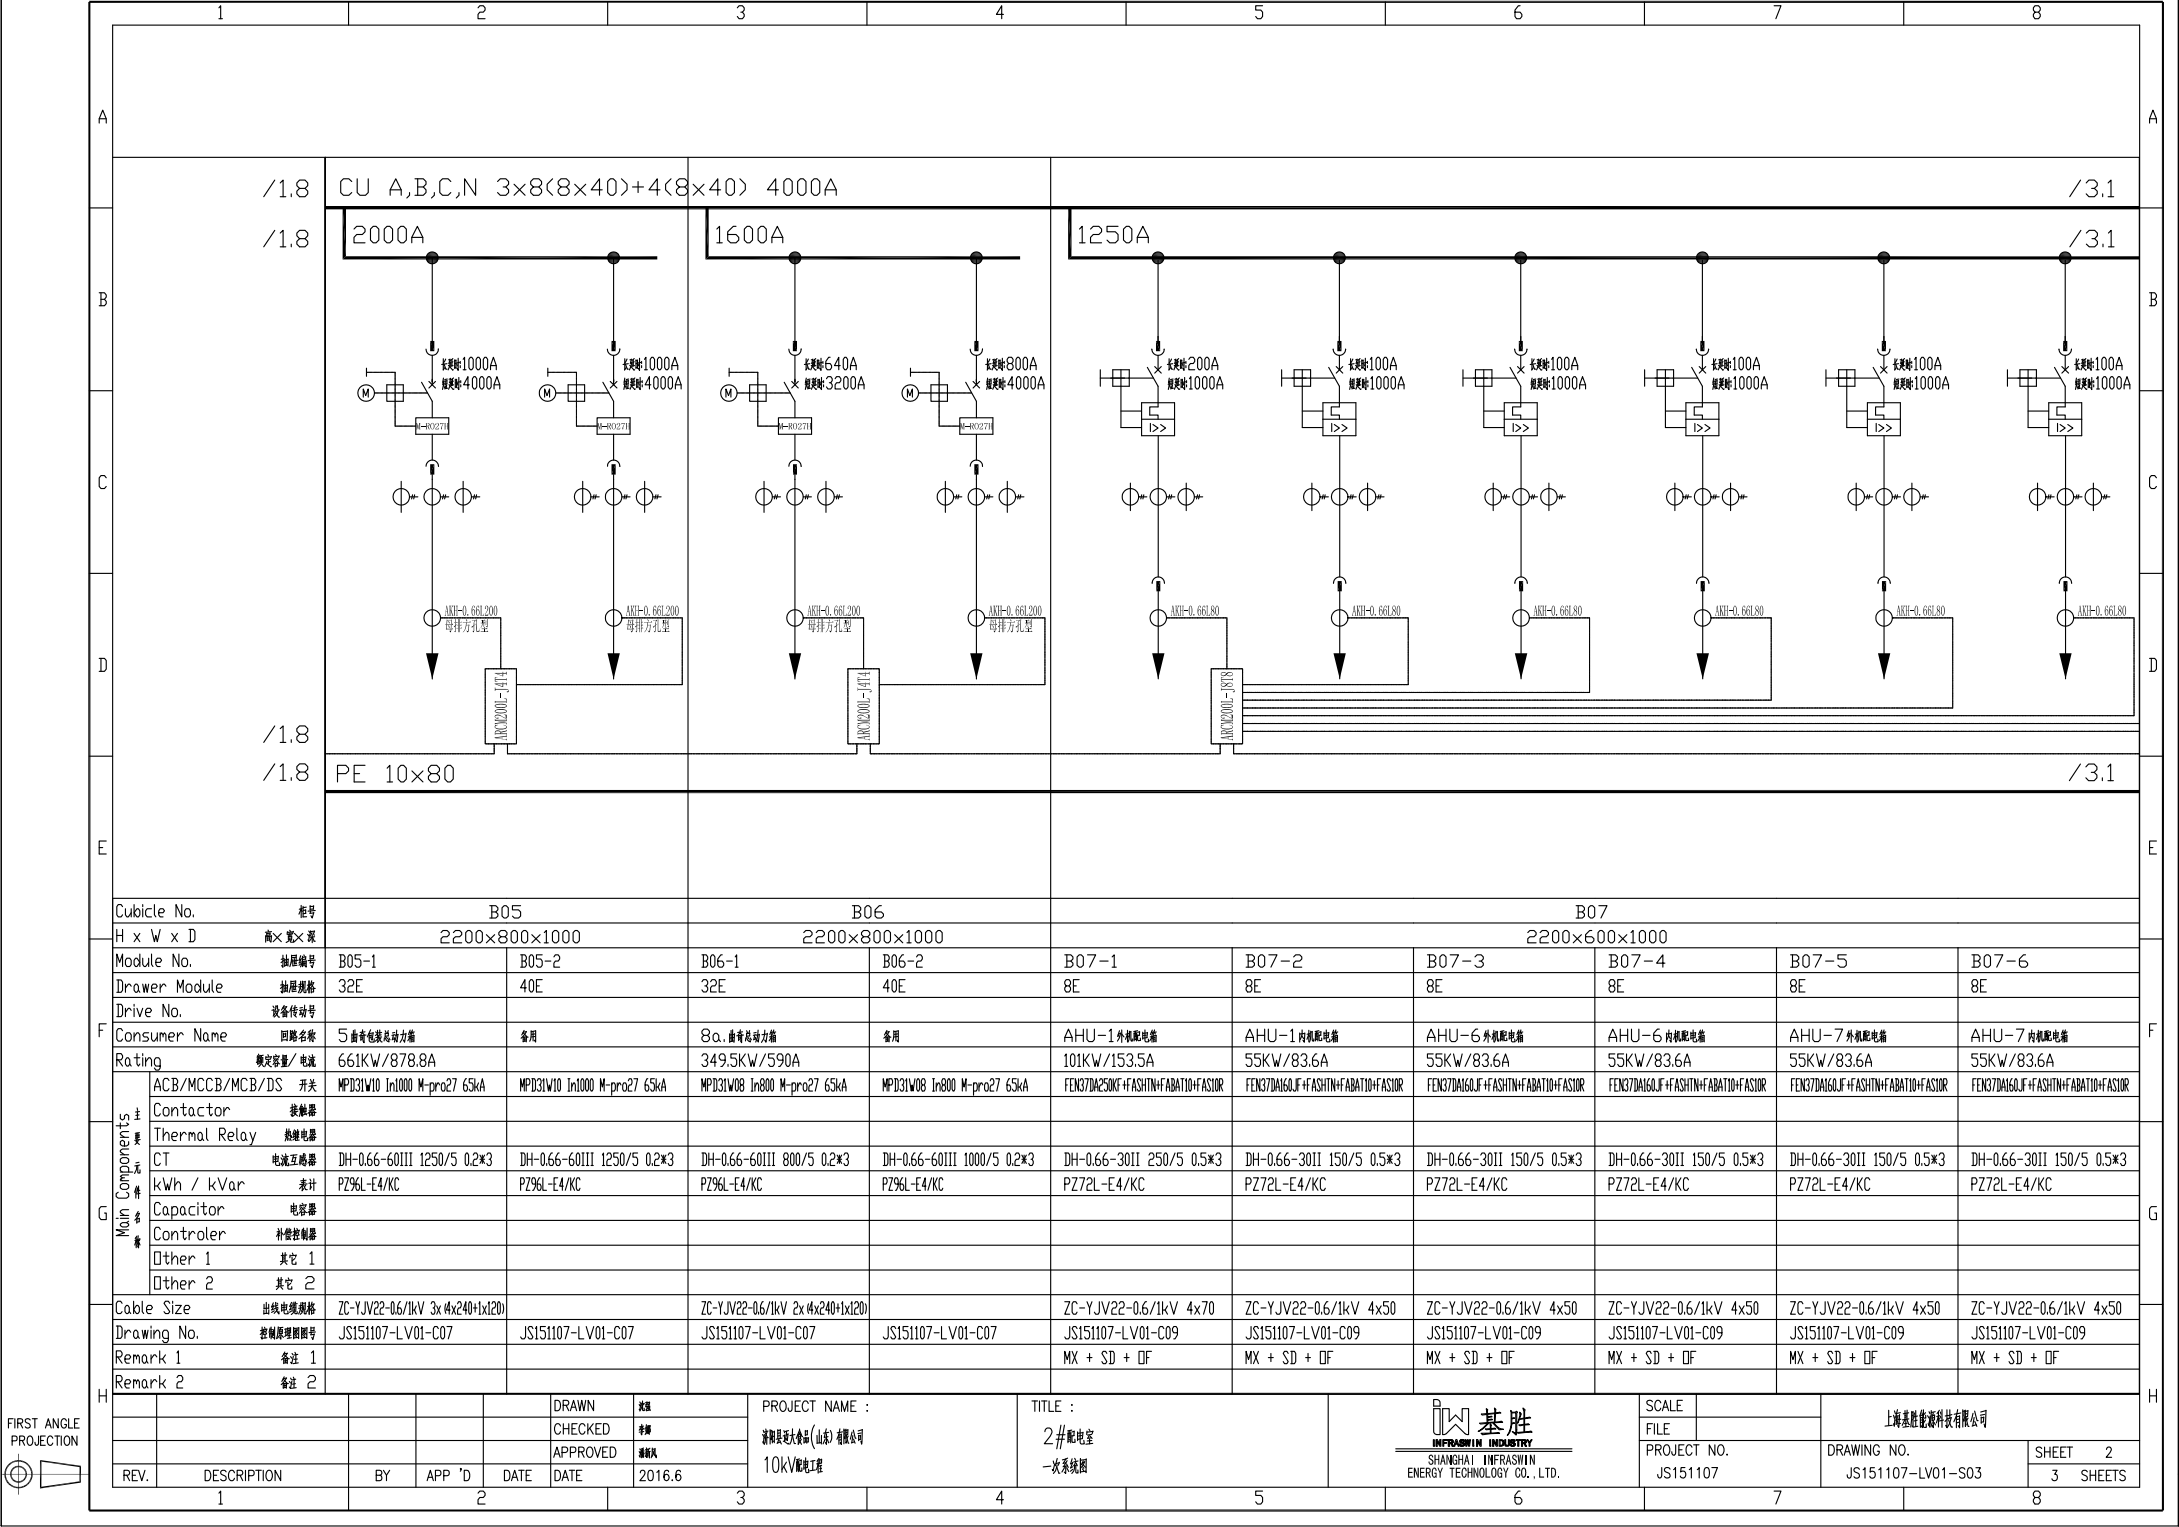


SCALE		上海基胜能源科技有限公司	
FILE			
PROJECT NO.		DRAWING NO.	SHEET 2
JS151107		JS151107-LV01-S03	3 SHEETS

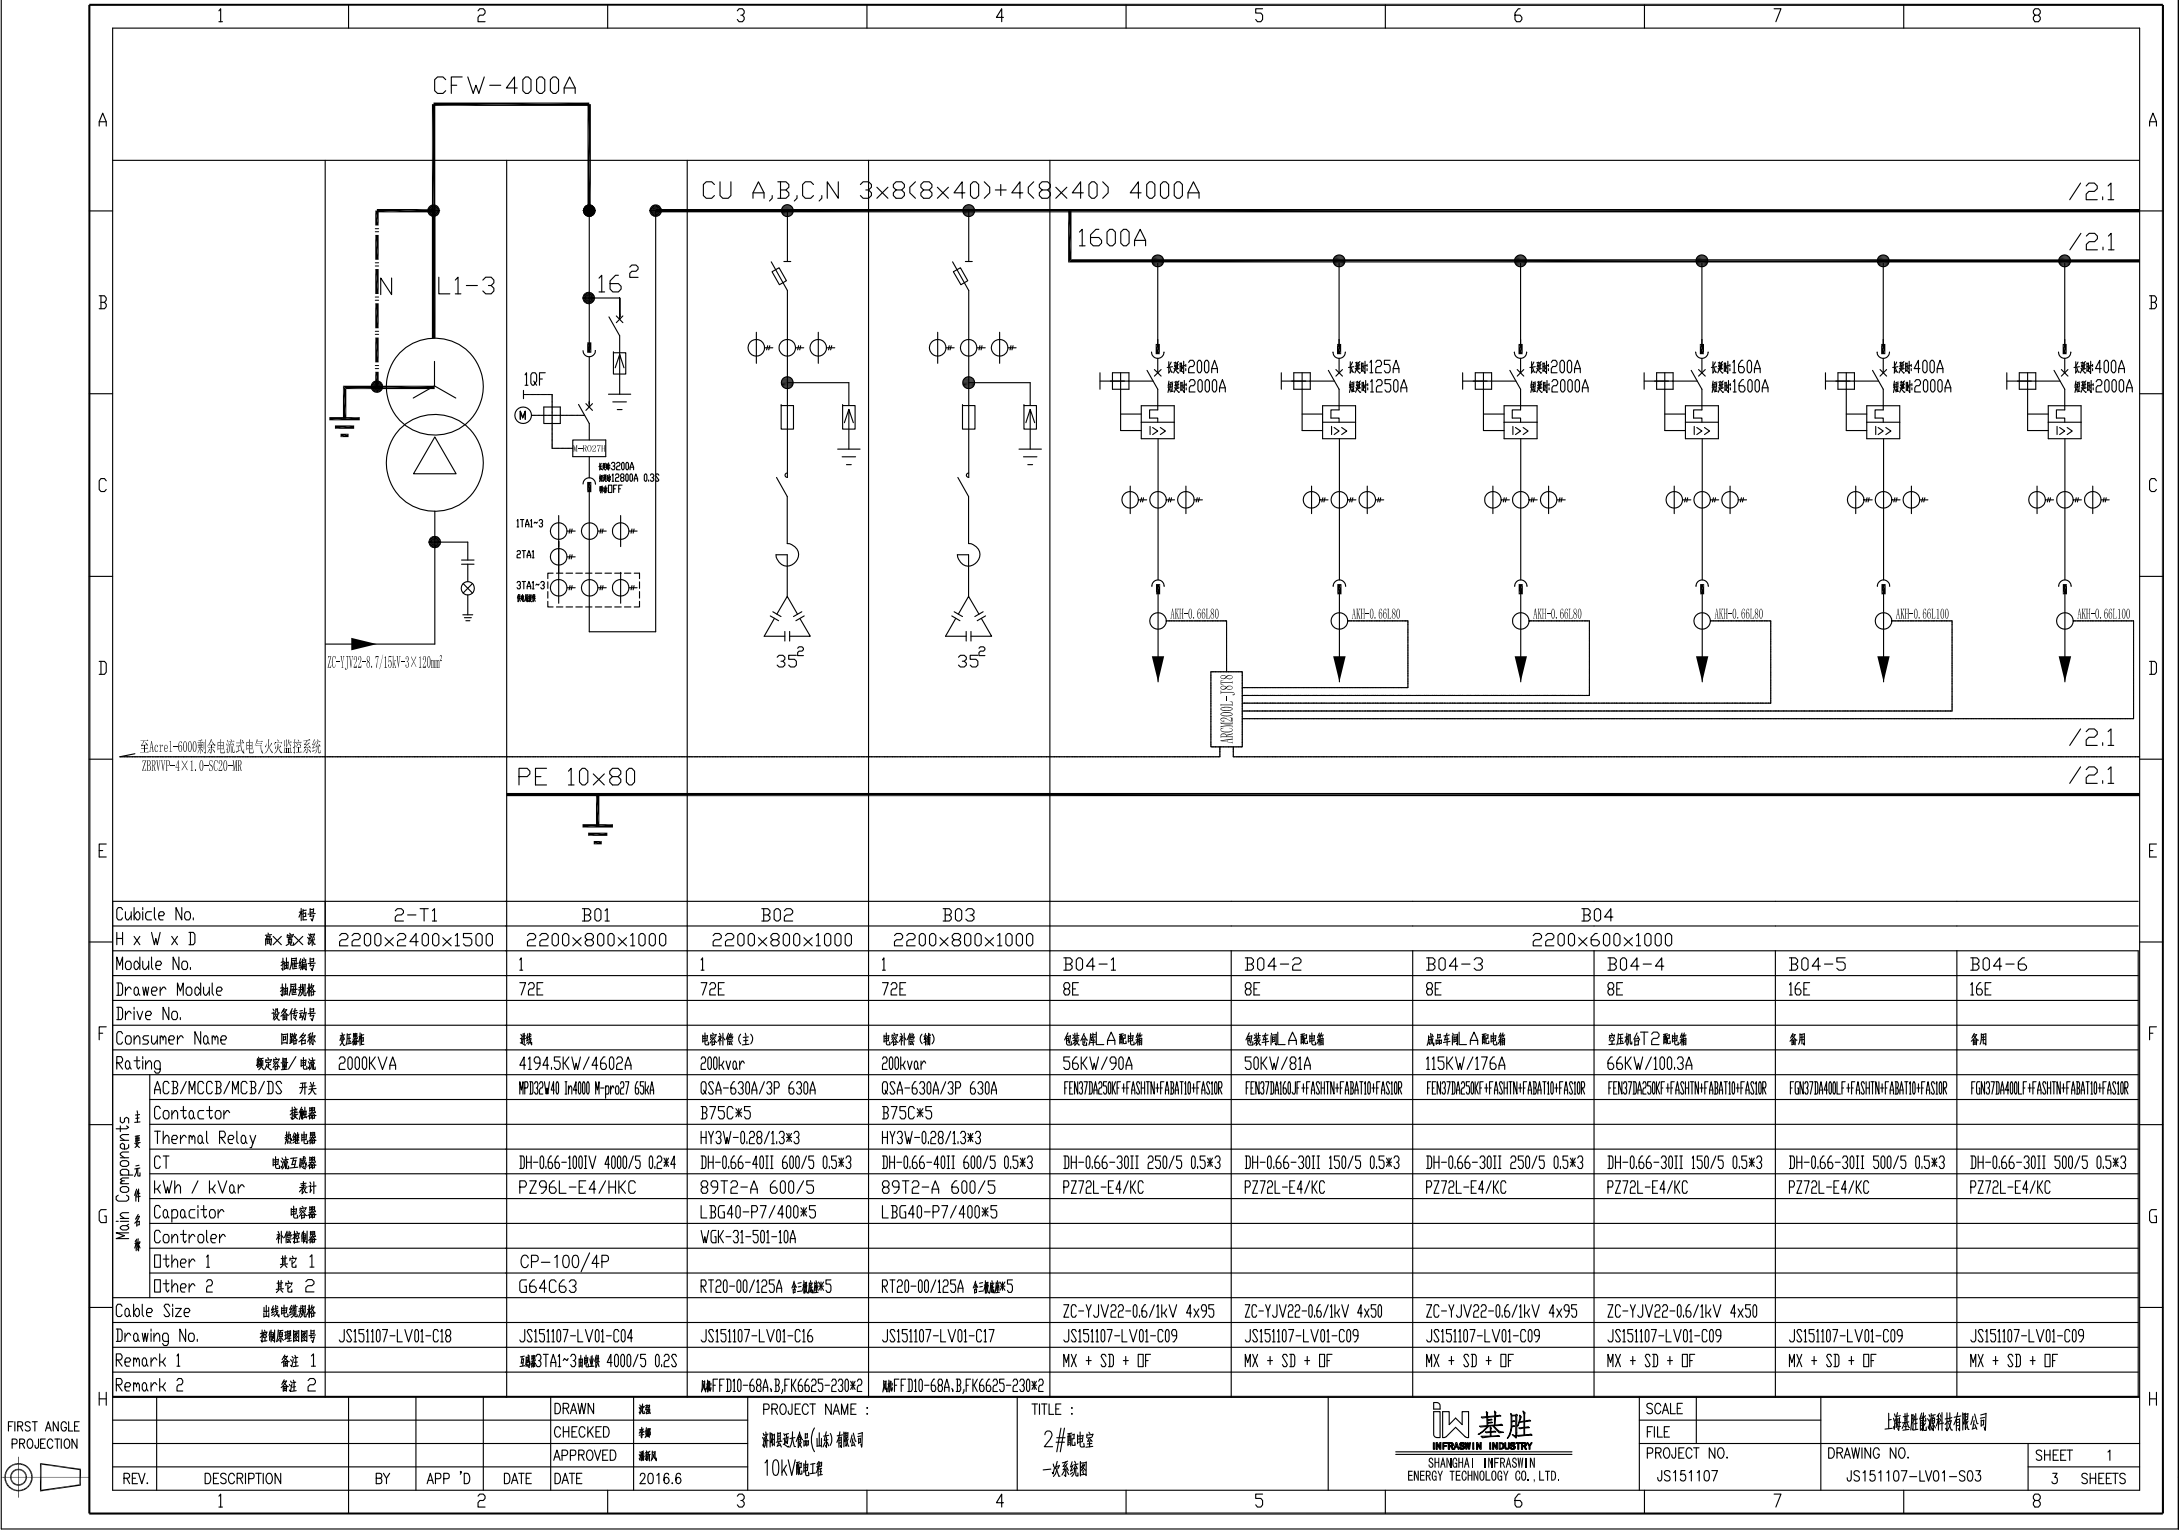

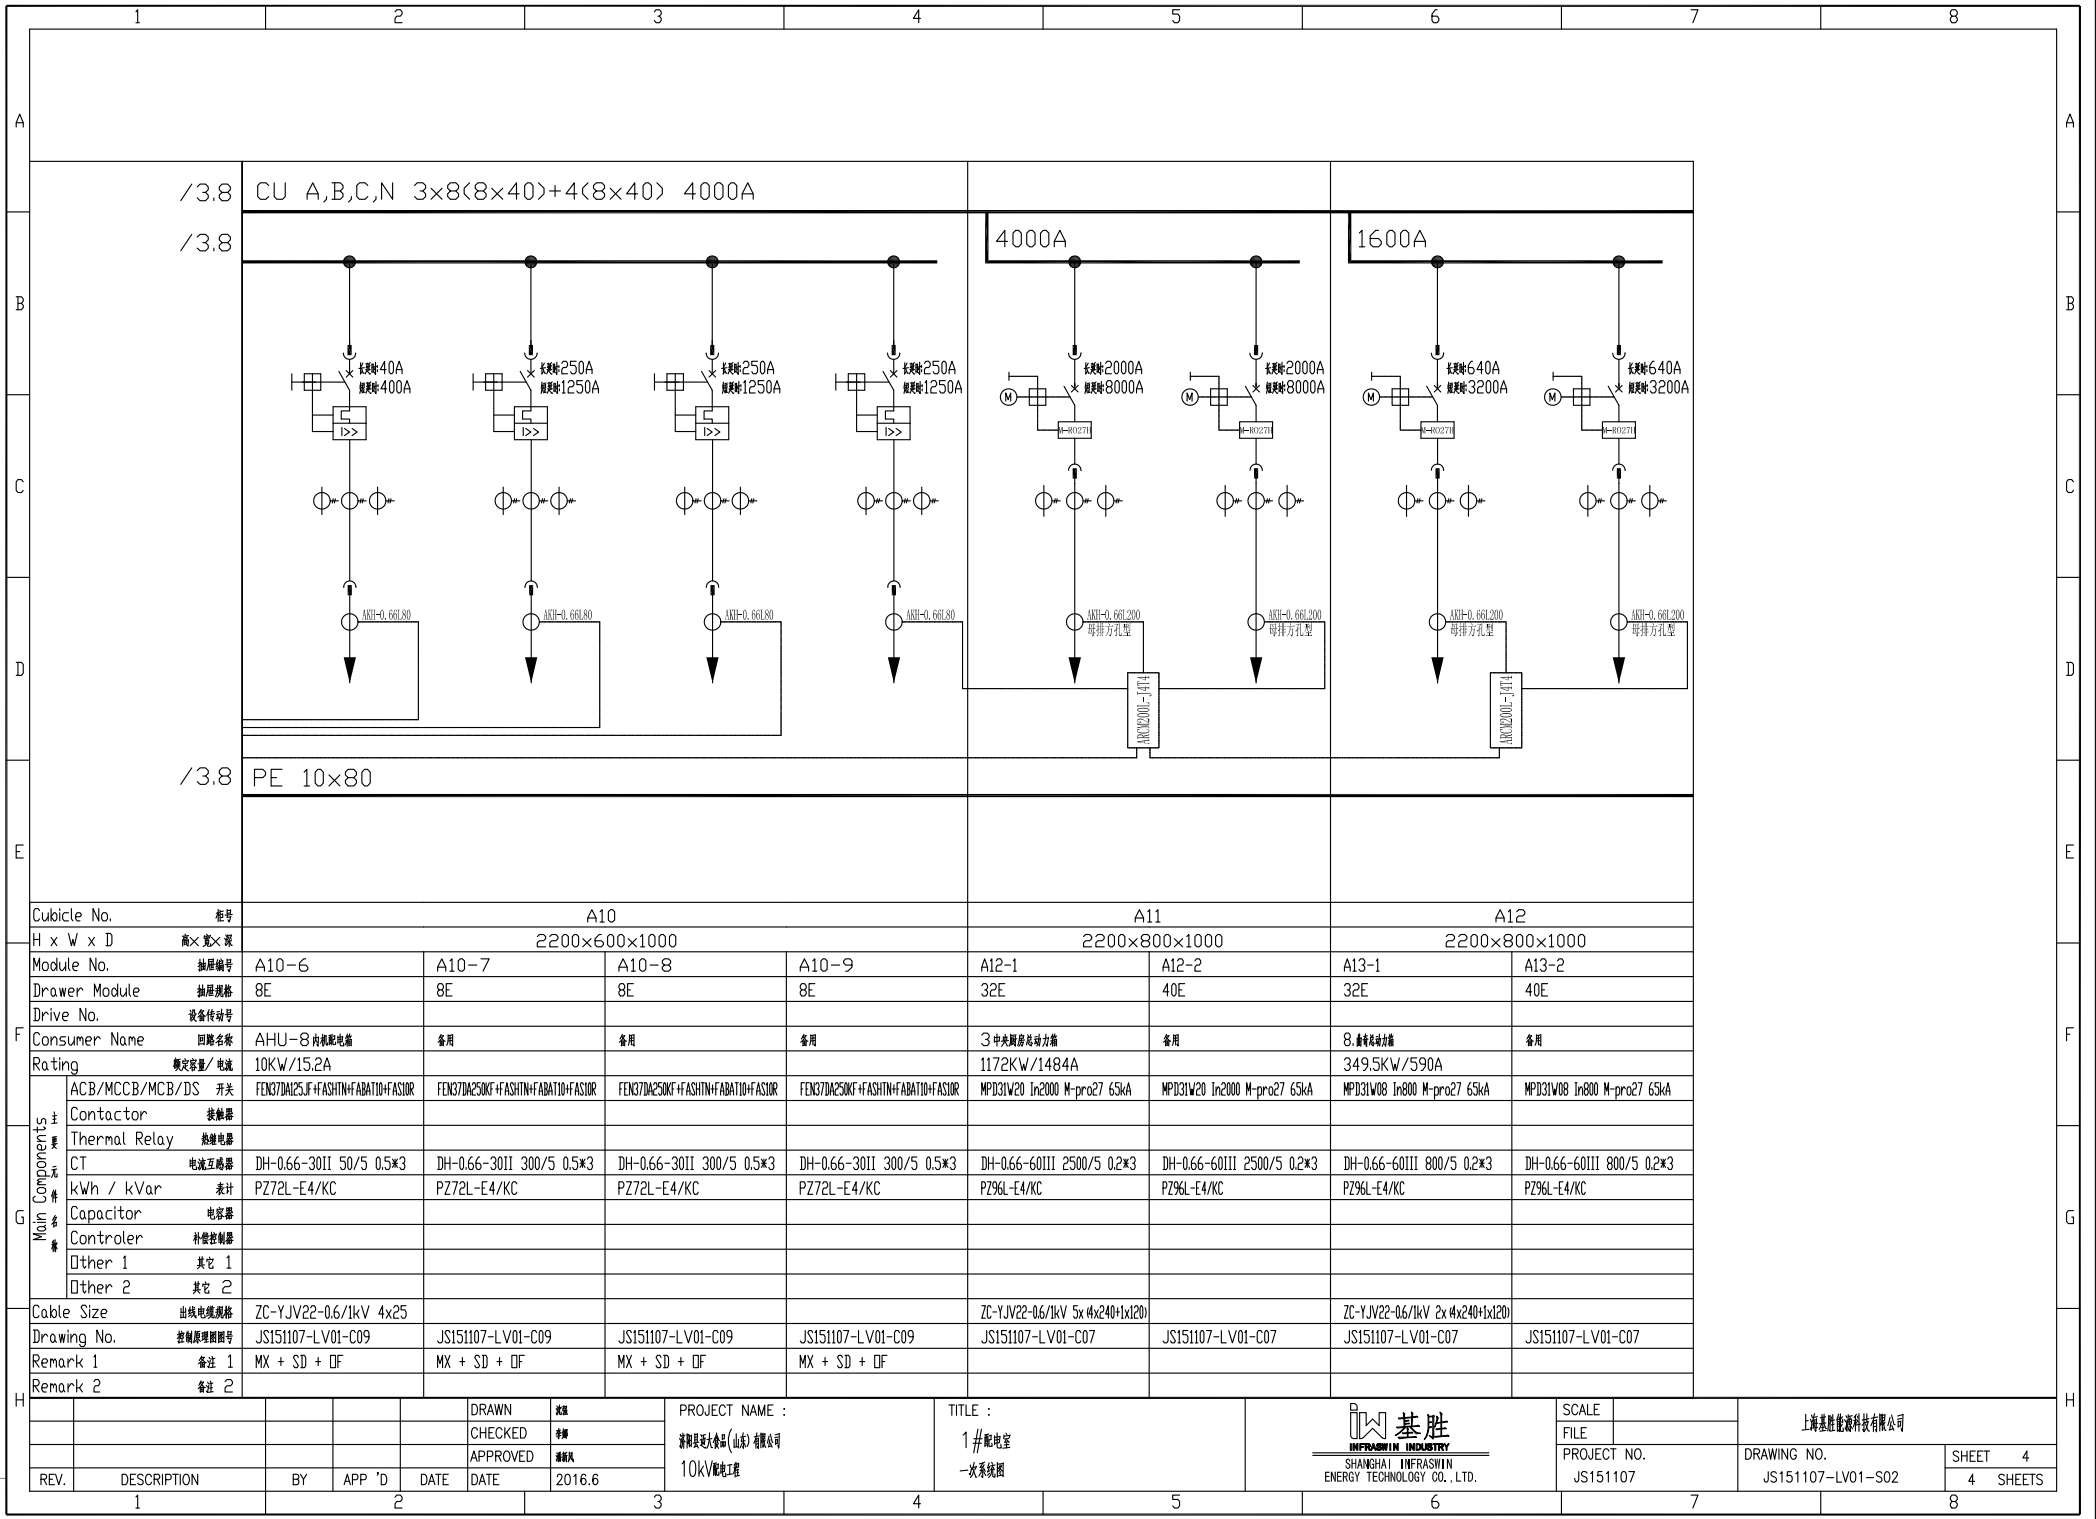

SCALE	FILE	DRAWING NO.	SHEET
PROJECT NO.	JS151107	JS151107-LV01-S02	4
DRAWING NO.		SHEET	
JS151107		4	

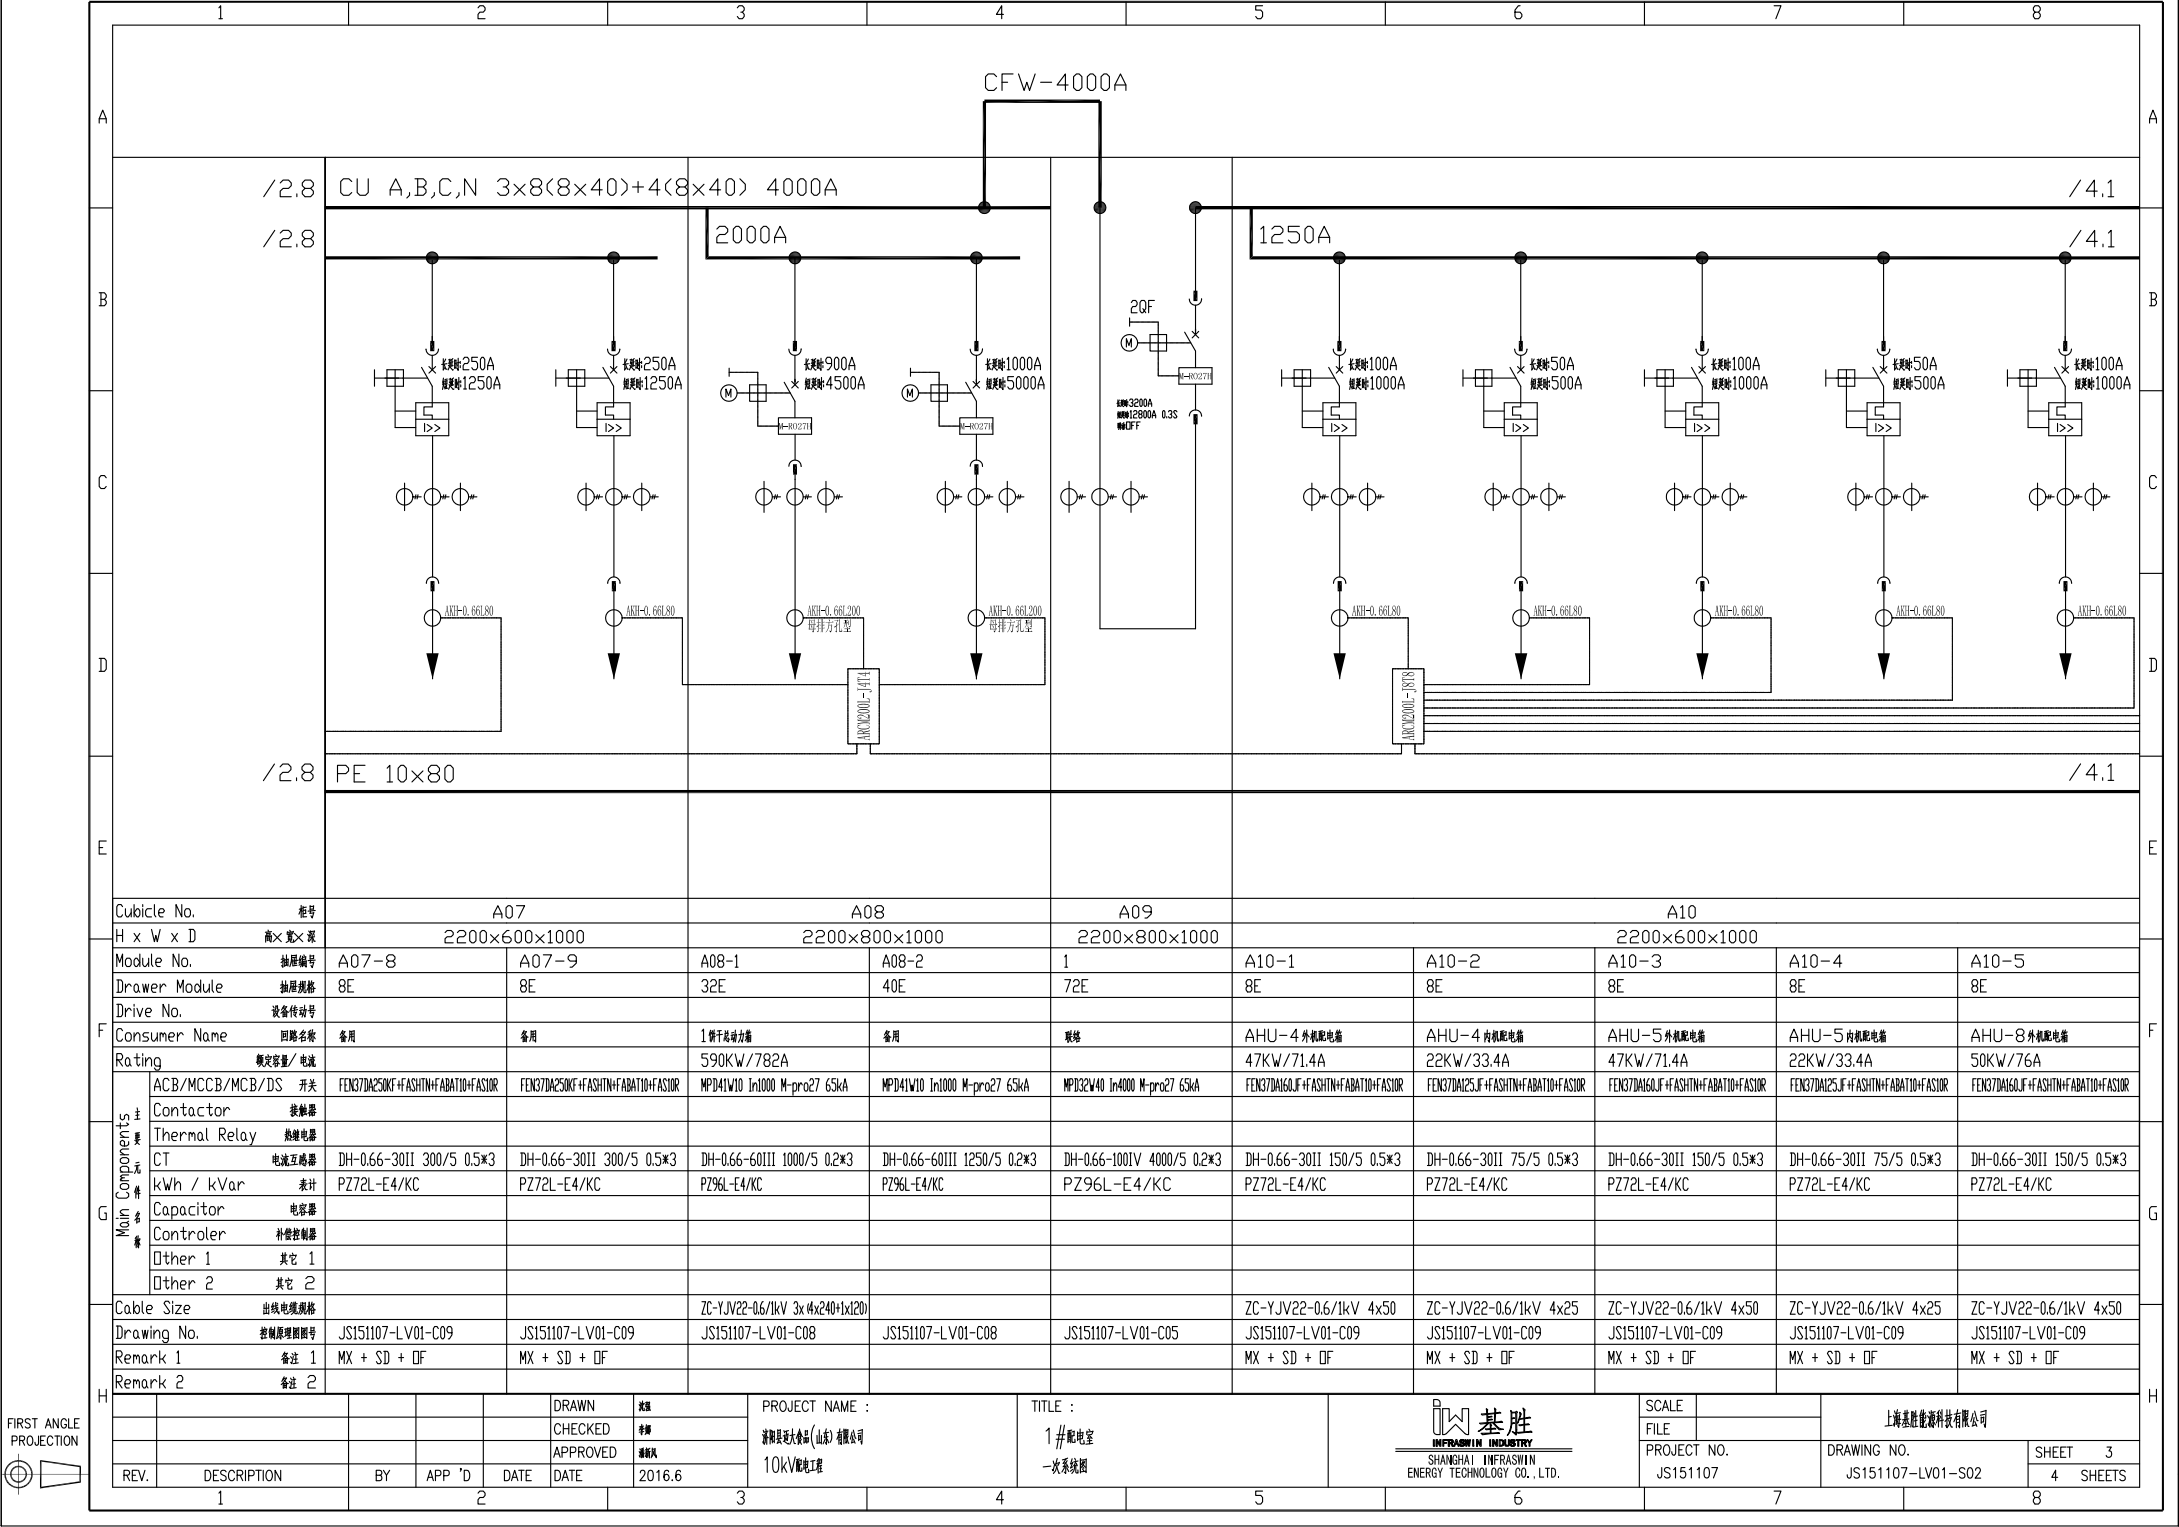




FIRST ANGLE
PROJECTION

1		2		3		4		5		6		7		8											
A																A									
		/1.8				/3.1																			
		/1.8				/3.1																			
B																B									
C																C									
D																D									
		/1.8				/3.1																			
		/1.8				/3.1																			
E		PE 10×80														E									
		Cubicle No. 柜号				A07																			
		H x W x D 高×宽×深				2200×600×1000																			
		Module No. 抽屉编号		A06-3		A06-4		A06-5		A07-1		A07-2		A07-3		A07-4		A07-5		A07-6		A07-7			
		Drawer Module 抽屉规格		8E		8E		24E		8E		8E		8E		8E		8E		8E		8E			
		Drive No. 设备传动号																							
F		Consumer Name 回路名称		空压机会T1配电箱		备用		备用		升降平台配电箱		检修车间配电箱		冷藏库配电箱		AHU-2外机配电箱		AHU-2内机配电箱		AHU-3外机配电箱		AHU-3内机配电箱			
		Rating 额定容量/电流		66KW/100.3A						25KW/47.5A		30KW/57A		30KW/57A		123KW/186.9A		55KW/83.6A		38KW/57.7A		55KW/83.6A			
G		ACB/MCCB/MCB/DS 开关		FEN37DA250KF+FSHTN+FABATID+FSUR		FEN37DA250KF+FSHTN+FABATID+FSUR		FEN37DA630NF+FSHTN+FABATID+FSUR		FEN37DA125JF+FSHTN+FABATID+FSUR		FEN37DA125JF+FSHTN+FABATID+FSUR		FEN37DA125JF+FSHTN+FABATID+FSUR		FEN37DA250KF+FSHTN+FABATID+FSUR		FEN37DA160JF+FSHTN+FABATID+FSUR		FEN37DA125JF+FSHTN+FABATID+FSUR		FEN37DA160JF+FSHTN+FABATID+FSUR			
		Contactor 接触器																							
		Thermal Relay 热继电器																							
		CT 电流互感器		DH-0.66-30II 150/5 0.5*3		DH-0.66-30II 300/5 0.5*3		DH-0.66-40II 750/5 0.5*3		DH-0.66-30II 75/5 0.5*3		DH-0.66-30II 100/5 0.5*3		DH-0.66-30II 100/5 0.5*3		DH-0.66-30II 250/5 0.5*3		DH-0.66-30II 150/5 0.5*3		DH-0.66-30II 100/5 0.5*3		DH-0.66-30II 150/5 0.5*3			
		kWh / kVar 表计		PZ72L-E4/KC		PZ72L-E4/KC		PZ72L-E4/KC		PZ72L-E4/KC		PZ72L-E4/KC		PZ72L-E4/KC		PZ72L-E4/KC		PZ72L-E4/KC		PZ72L-E4/KC		PZ72L-E4/KC			
		Capacitor 电容器																							
		Controler 补偿控制器																							
		Other 1 其它 1																							
		Other 2 其它 2																							
		Cable Size 出线电缆规格		ZC-YJV22-0.6/1kV 4x50						ZC-YJV22-0.6/1kV 4x25		ZC-YJV22-0.6/1kV 4x35		ZC-YJV22-0.6/1kV 4x35		ZC-YJV22-0.6/1kV 4x70		ZC-YJV22-0.6/1kV 4x50		ZC-YJV22-0.6/1kV 4x35		ZC-YJV22-0.6/1kV 4x35			
		Drawing No. 控制原理图编号		JS151107-LV01-C09		JS151107-LV01-C09		JS151107-LV01-C09		JS151107-LV01-C09		JS151107-LV01-C09		JS151107-LV01-C09		JS151107-LV01-C09		JS151107-LV01-C09		JS151107-LV01-C09		JS151107-LV01-C09			
		Remark 1 备注 1		MX + SD + OF		MX + SD + OF		MX + SD + OF		MX + SD + OF		MX + SD + OF		MX + SD + OF		MX + SD + OF		MX + SD + OF		MX + SD + OF		MX + SD + OF			
H		Remark 2 备注 2																							
				DRAWN 制图		PROJECT NAME :		TITLE :		SHANGHAI INFRASWIN ENERGY TECHNOLOGY CO., LTD.		SCALE		PROJECT NO.		DRAWING NO.		SHEET 2							
				CHECKED 审核		济阳县老农会(山东)有限公司		1#配电室		一次系统图		FILE		JS151107		JS151107-LV01-S02		4 SHEETS							
		REV. DESCRIPTION		BY APP 'D DATE		2016.6																			
		1		2		3		4		5		6		7		8									



SCALE		PROJECT NO. JS151107		DRAWING NO. JS151107-LV01-S02		SHEET 2 4 SHEETS	
-------	--	----------------------	--	-------------------------------	--	------------------	--

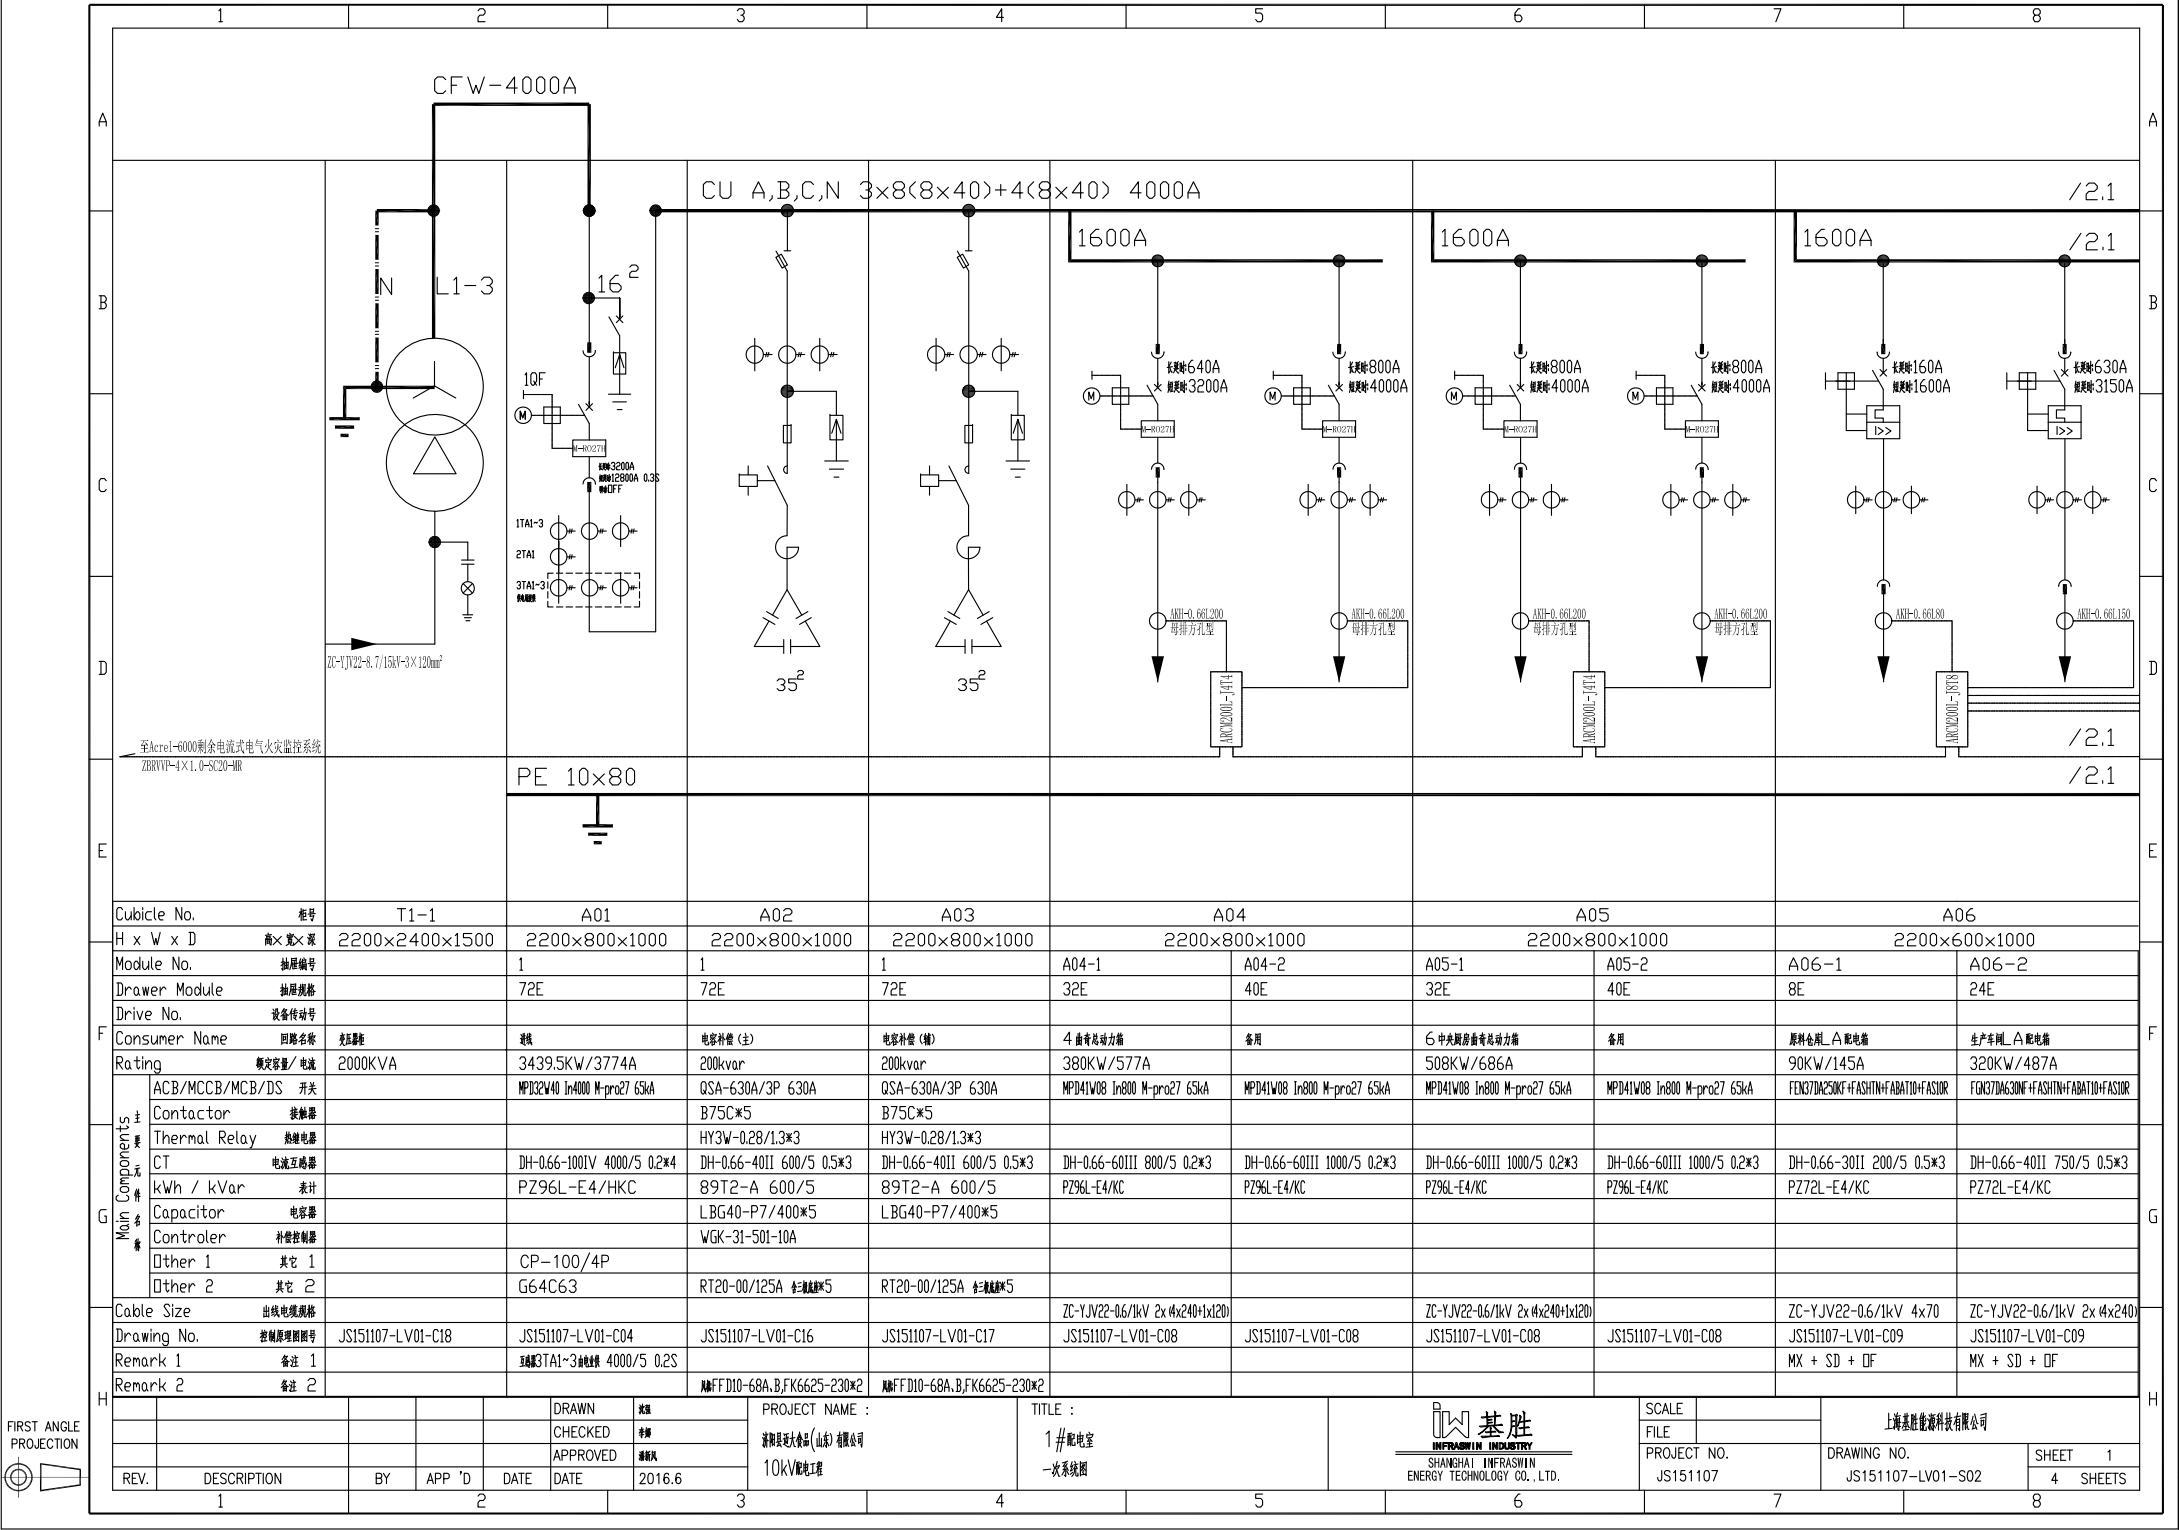

至Mcrel-6000剩余电流式电气火灾监控系统
ZB88VVP-4X1.0-50(20)-HR

Cubicle No.		柜号	T1-1	A01	A02	A03	A04		A05		A06	
H x W x D		高×宽×深	2200×2400×1500	2200×800×1000	2200×800×1000	2200×800×1000	2200×800×1000		2200×800×1000		2200×600×1000	
Module No.		抽屉编号	1	1	1		A04-1	A04-2	A05-1	A05-2	A06-1	A06-2
Drawer Module		抽屉规格	72E	72E	72E		32E	40E	32E	40E	8E	24E
Drive No.		设备传动号										
Consumer Name		回路名称	高压柜	进线	电容补偿 (主)	电容补偿 (辅)	4 座中压站动力箱		6 中央厨房前中压站动力箱		原料仓储_△配电箱	
Rating		额定容量/ 电流	2000KVA	3439.5KW/3774A	200kvar	200kvar	380KW/577A		508KW/686A		90KW/145A	
Main Components	ACB/MCCB/MCB/DS 开关			NP1032W40 In4000 M-pro27 65kA	QSA-630A/3P 630A	QSA-630A/3P 630A	MPD41W08 In800 M-pro27 65kA		MPD41W08 In800 M-pro27 65kA		FEN37DA250NF+ASHTN+FABAT10+FASIOR	
	Contactor 接触器				B75C*5	B75C*5					FEN37DA250NF+ASHTN+FABAT10+FASIOR	
	Thermal Relay 热继电器				HY3W-0.28/1.3*3	HY3W-0.28/1.3*3						
	CT 电流互感器			DH-0.66-100IV 4000/5 0.2*4	DH-0.66-40III 600/5 0.5*3	DH-0.66-40III 600/5 0.5*3	DH-0.66-60III 800/5 0.2*3		DH-0.66-60III 1000/5 0.2*3		DH-0.66-30III 200/5 0.5*3	
	kWh / kVar 表计			PZ96L-E4/HKC	89T2-A 600/5	89T2-A 600/5	PZ96L-E4/KC		PZ96L-E4/KC		PZ72L-E4/KC	
	Capacitor 电容器				LBG40-P7/400*5	LBG40-P7/400*5						
	Controler 补偿控制器				WGK-3I-50I-10A							
	Other 1 其它 1			CP-100/4P								
	Other 2 其它 2			G64C63	RT20-00/125A 全3级脱扣*5	RT20-00/125A 全3级脱扣*5						
Cable Size		出线电缆规格					ZC-YJV22-0.6/1kV 2x4x240+1x120		ZC-YJV22-0.6/1kV 2x4x240+1x120		ZC-YJV22-0.6/1kV 4x70	
Drawing No.		控制原理图编号	JS151107-LV01-C18	JS151107-LV01-C04	JS151107-LV01-C16	JS151107-LV01-C17	JS151107-LV01-C08		JS151107-LV01-C08		JS151107-LV01-C09	
Remark 1		备注 1		至Mcrel-6000剩余电流式电气火灾监控系统								
Remark 2		备注 2			至Mcrel-6000剩余电流式电气火灾监控系统						MX + SD + DF	

FIRST ANGLE PROJECTION

REV.

DESCRIPTION

BY

APP 'D

DATE

DRAWN

CHECKED

APPROVED

DATE

2016.6

PROJECT NAME :

1# 配电室

一次系统图

TITLE :

1# 配电室

一次系统图

基胜

SHANGHAI INFRAWIN ENERGY TECHNOLOGY CO., LTD.

SCALE

FILE

PROJECT NO.

JS151107

上海基胜能源科技有限公司

DRAWING NO.

JS151107-LV01-S02

SHEET 1

4 SHEETS



FIRST ANGLE
PROJECTION

1		2		3		4		5		6		7		8	
A		B		C		D		E		F		G		H	
/1.8		/1.8		CU A,B,C,N 4×2(8×30) 100DA											
/1.8		/1.8		PE 8×40											
Cubicle No.		柜号		D4		D5		D6		T					
H x W x D		高×宽×深		2200×600×1000		2200×800×1000		2200×800×1000		2200×1600×1200					
Module No.		抽屉编号		D4-4		D4-5		1		1					
Drawer Module		抽屉规格		16E		16E		72E		72E					
Drive No.		设备传动号													
Consumer Name		回路名称		备用		备用		电容补偿		电容补偿		电容补偿			
Rating		额定容量/电流				150kvar				500KVA					
Main Components	主要元件名称	ACB/MCCB/MCB/DS 开关		FGK37DM400LF+ASHTN+FBAT10+FASSOR		FGK37DM400LF+ASHTN+FBAT10+FASSOR		QSA-400A/3P 400A		MPD3LV10 In1000 M-pro27 65kA					
		Contactor 接触器													
		Thermal Relay 热继电器				HY3W-0.28/1.3*3									
		CT 电流互感器		DH-0.66-301I 400/5 0.5*3		DH-0.66-301I 400/5 0.5*3		DH-0.66-301I 400/5 0.5*3		DH-0.66-601III 1000/5 0.2*6					
		kWh / kVar 表计		PZ72L-E4/KC		PZ72L-E4/KC		8972-A 400/5		PZ96L-E4/KC					
		Capacitor 电容器													
		Controler 补偿控制				WGK-31-201-F									
		Other 1 其它 1						CP-100/4P							
		Other 2 其它 2						G64C63							
Cable Size		出线电缆规格													
Drawing No.		控制原理图图号		JS151107-LV01-C09		JS151107-LV01-C09		JS151107-LV01-C15		JS151107-LV01-C03		JS151107-LV01-C18			
Remark 1		备注 1		MX + SD + OF		MX + SD + OF									
Remark 2		备注 2				MFDD10-68A,B,FK6625-230*2									