





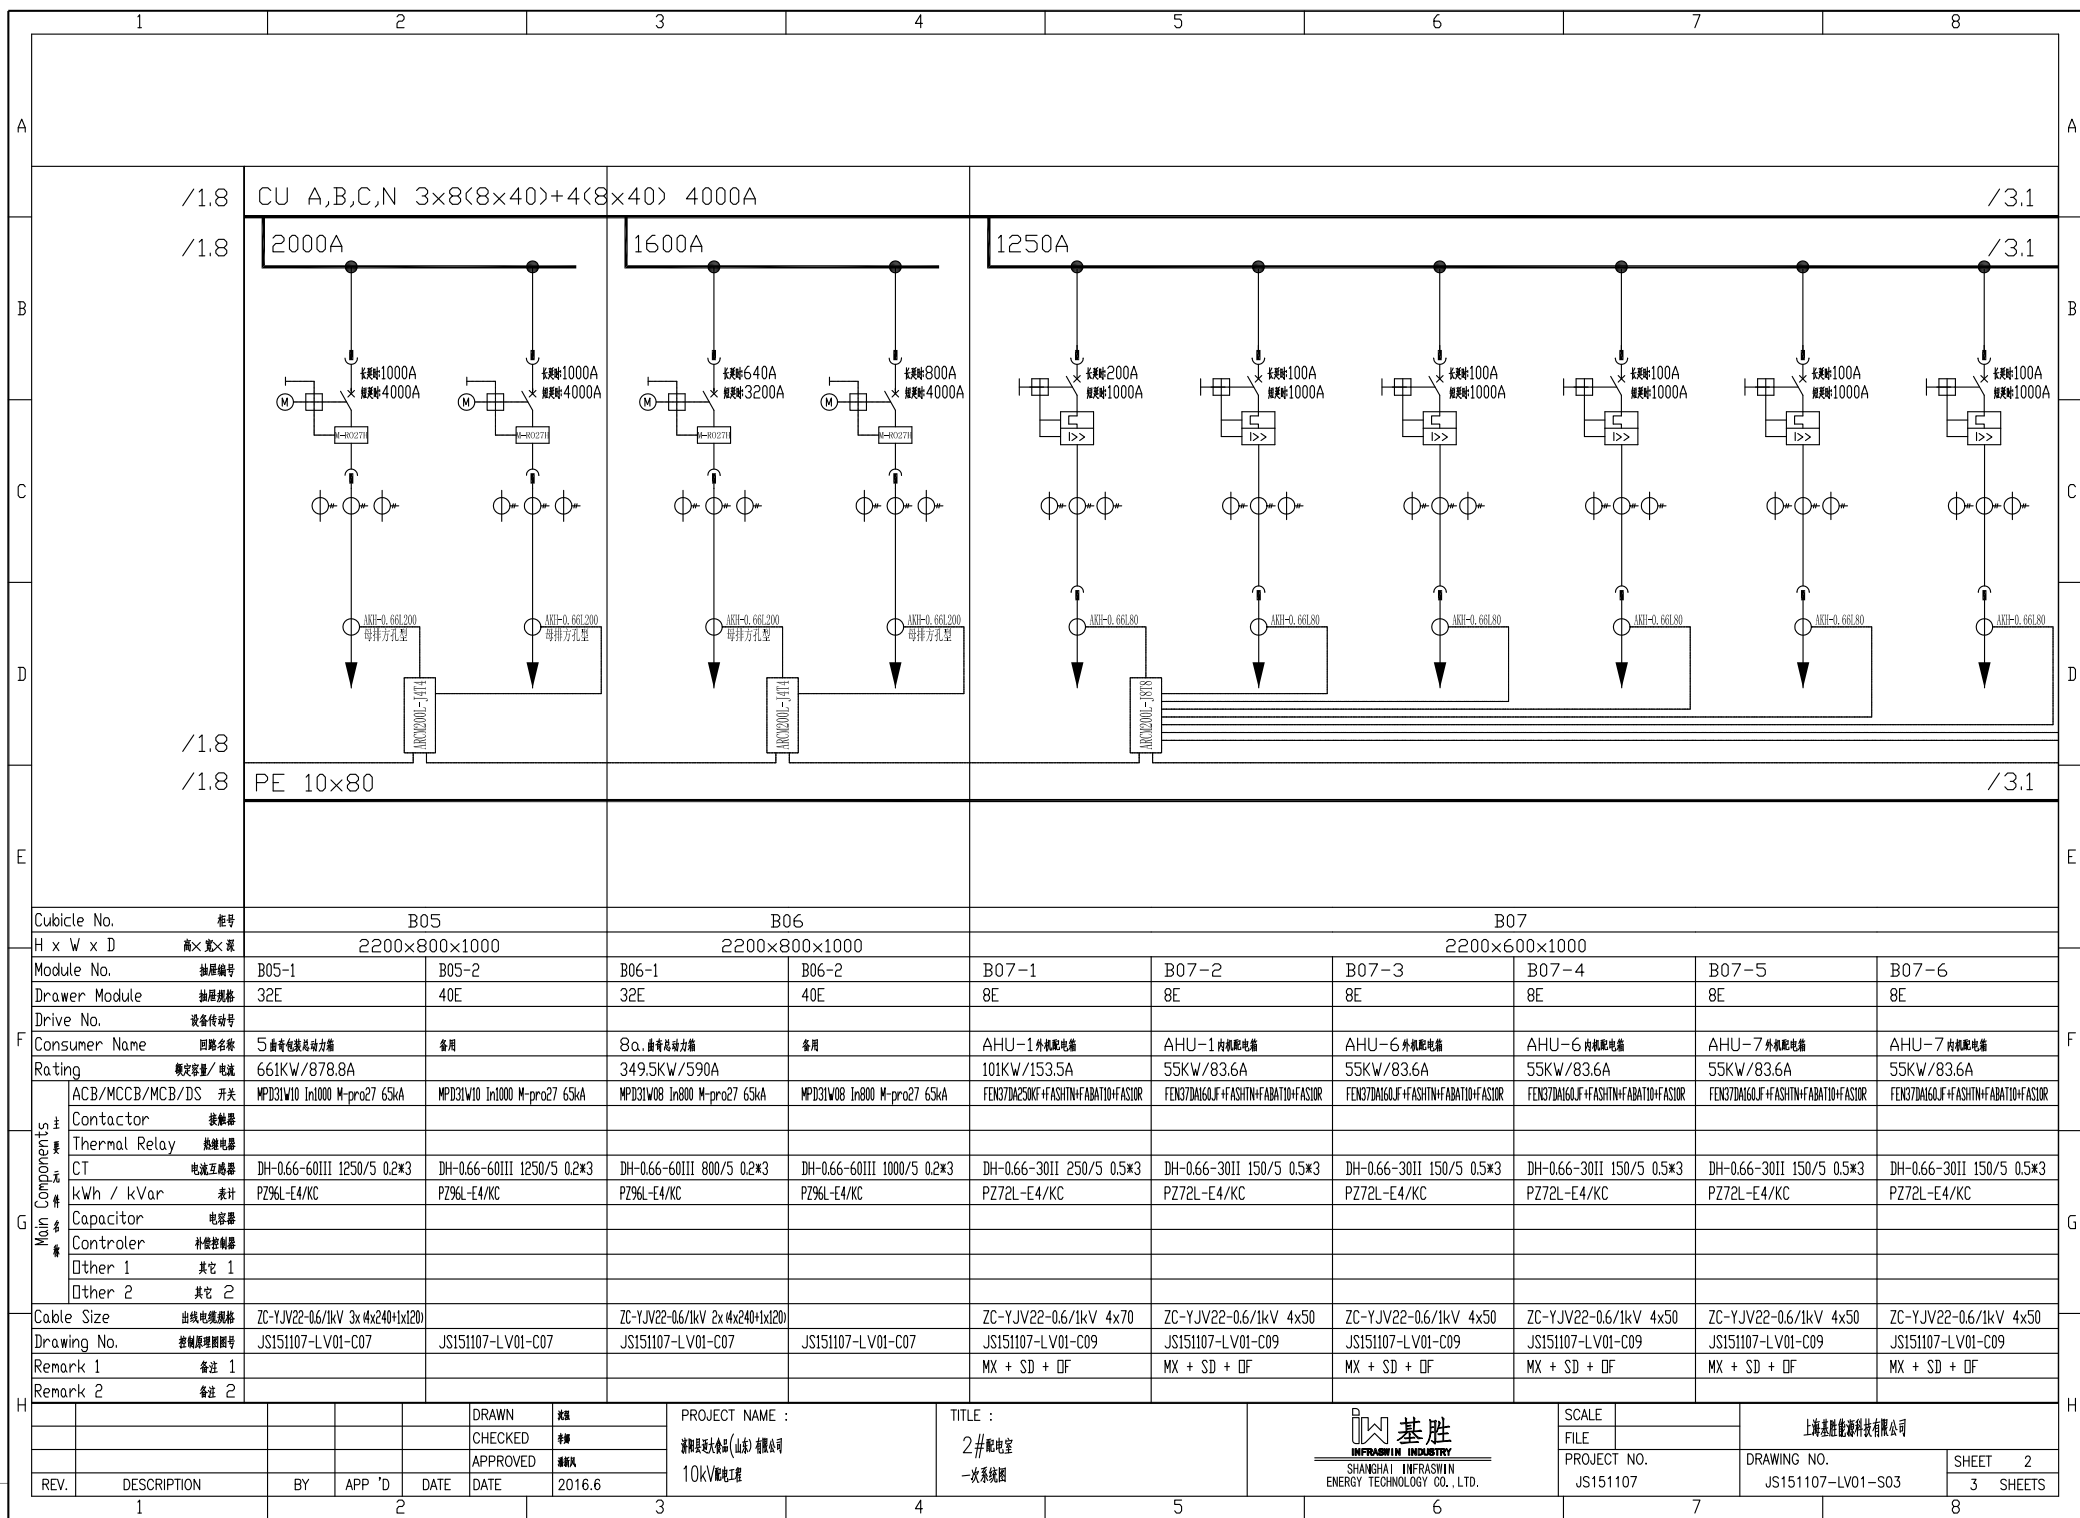


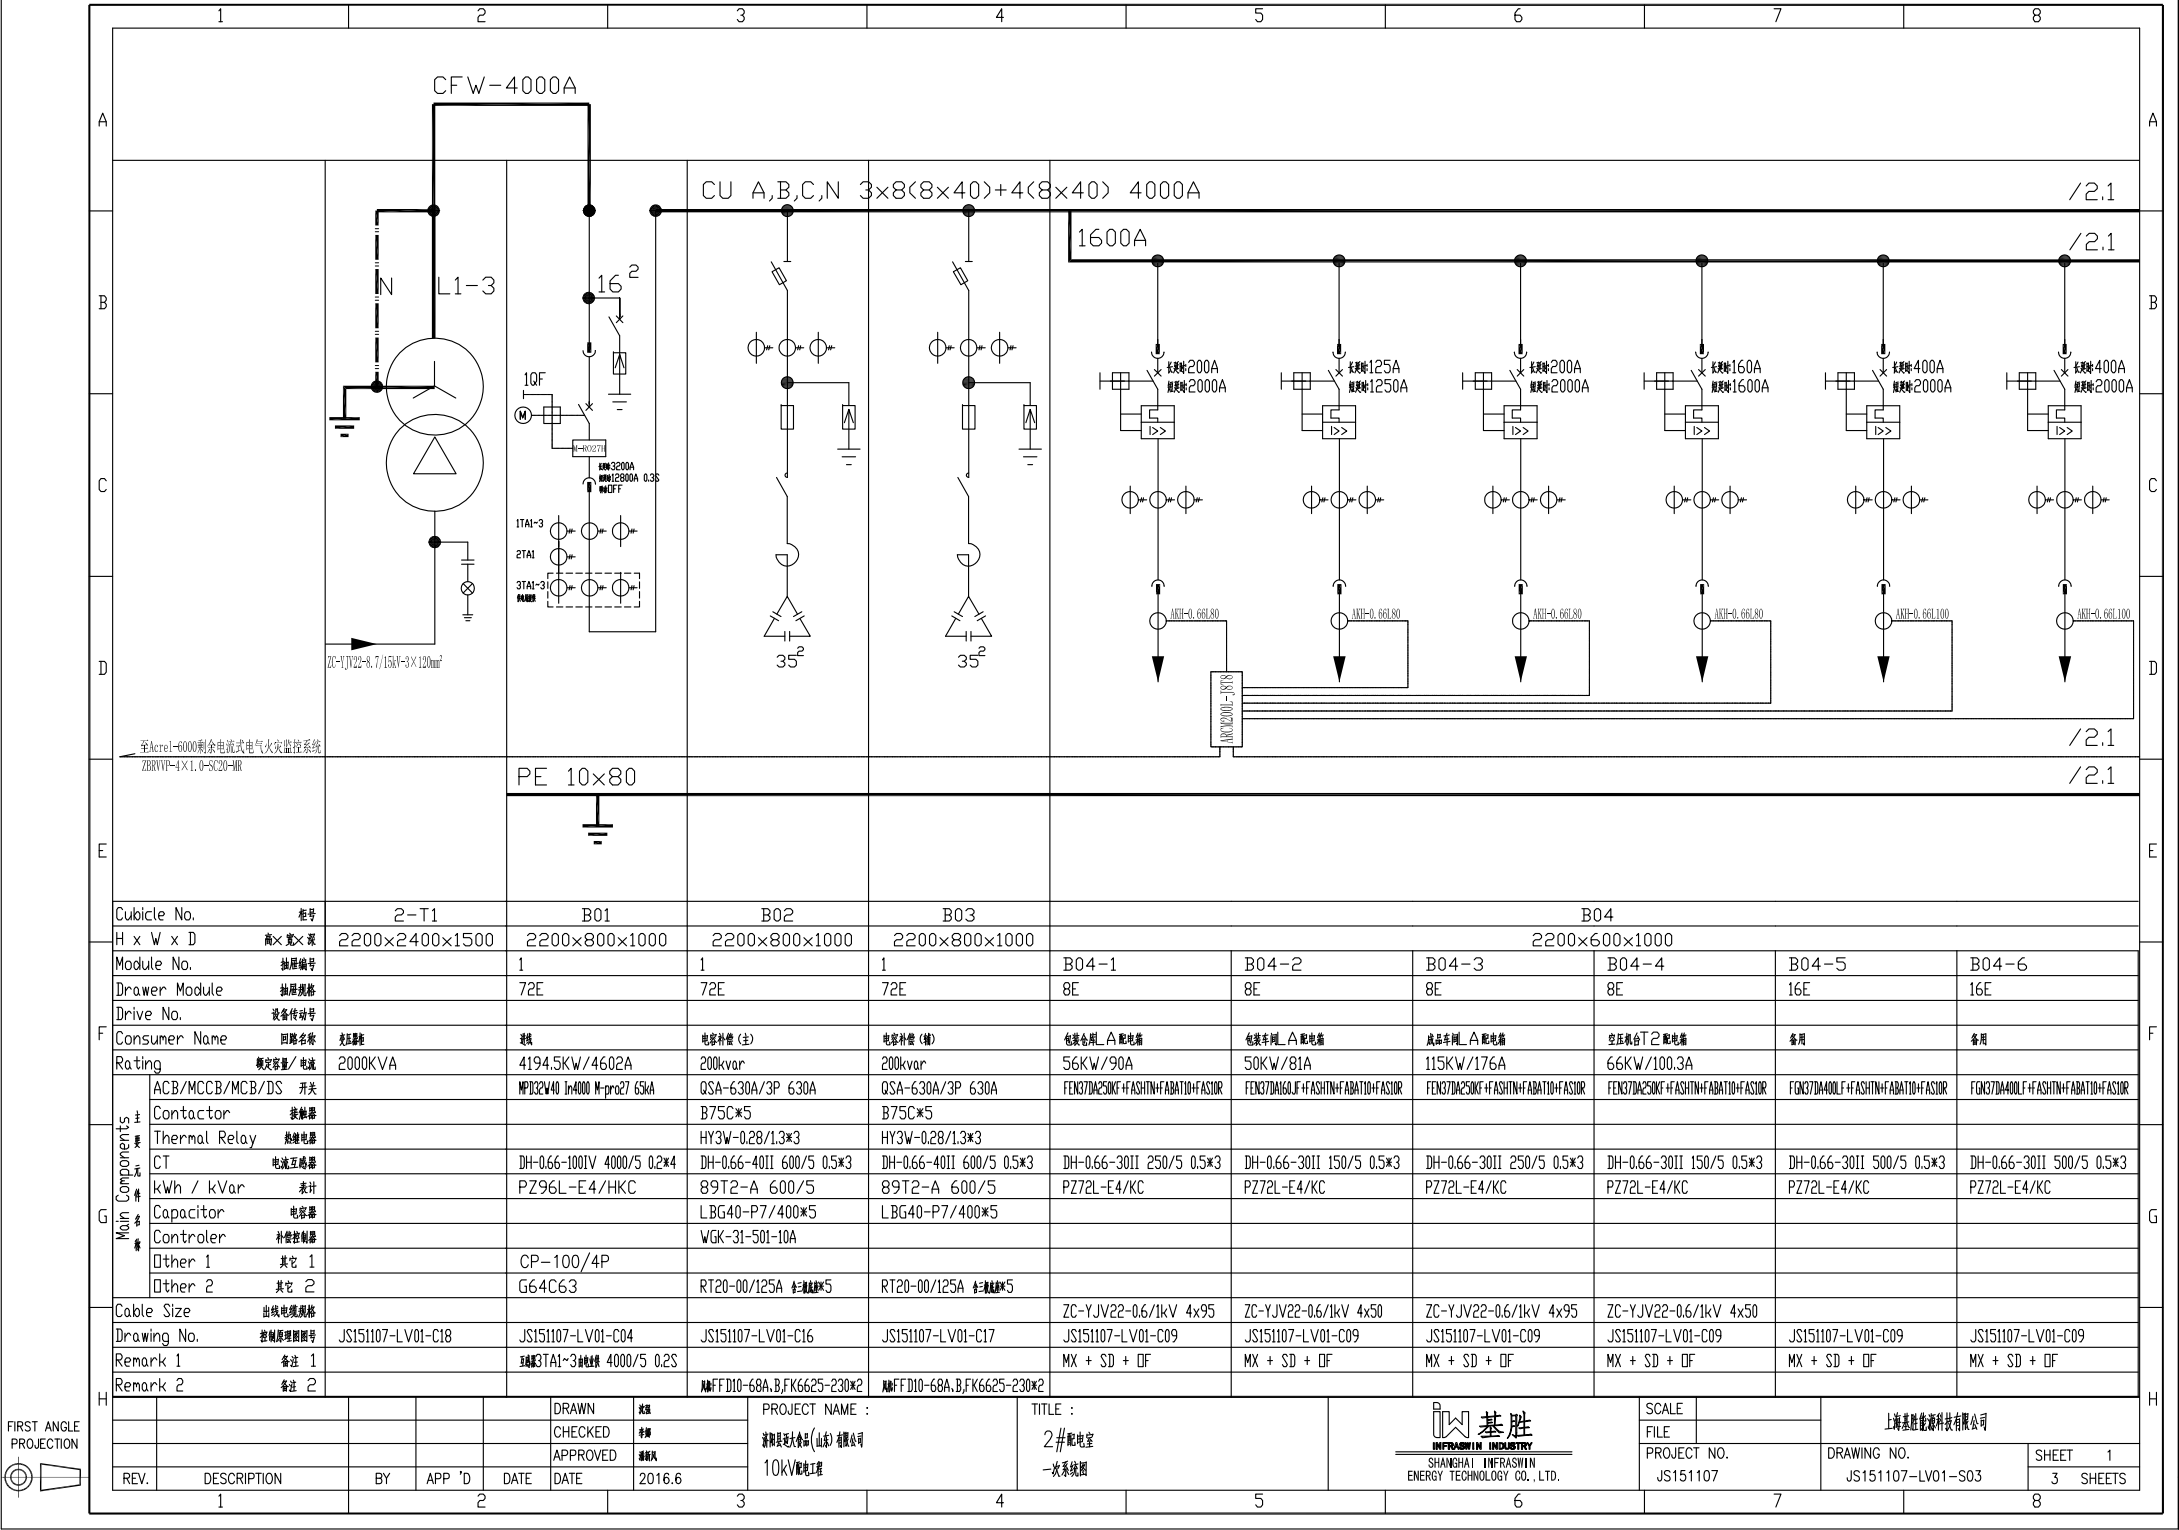

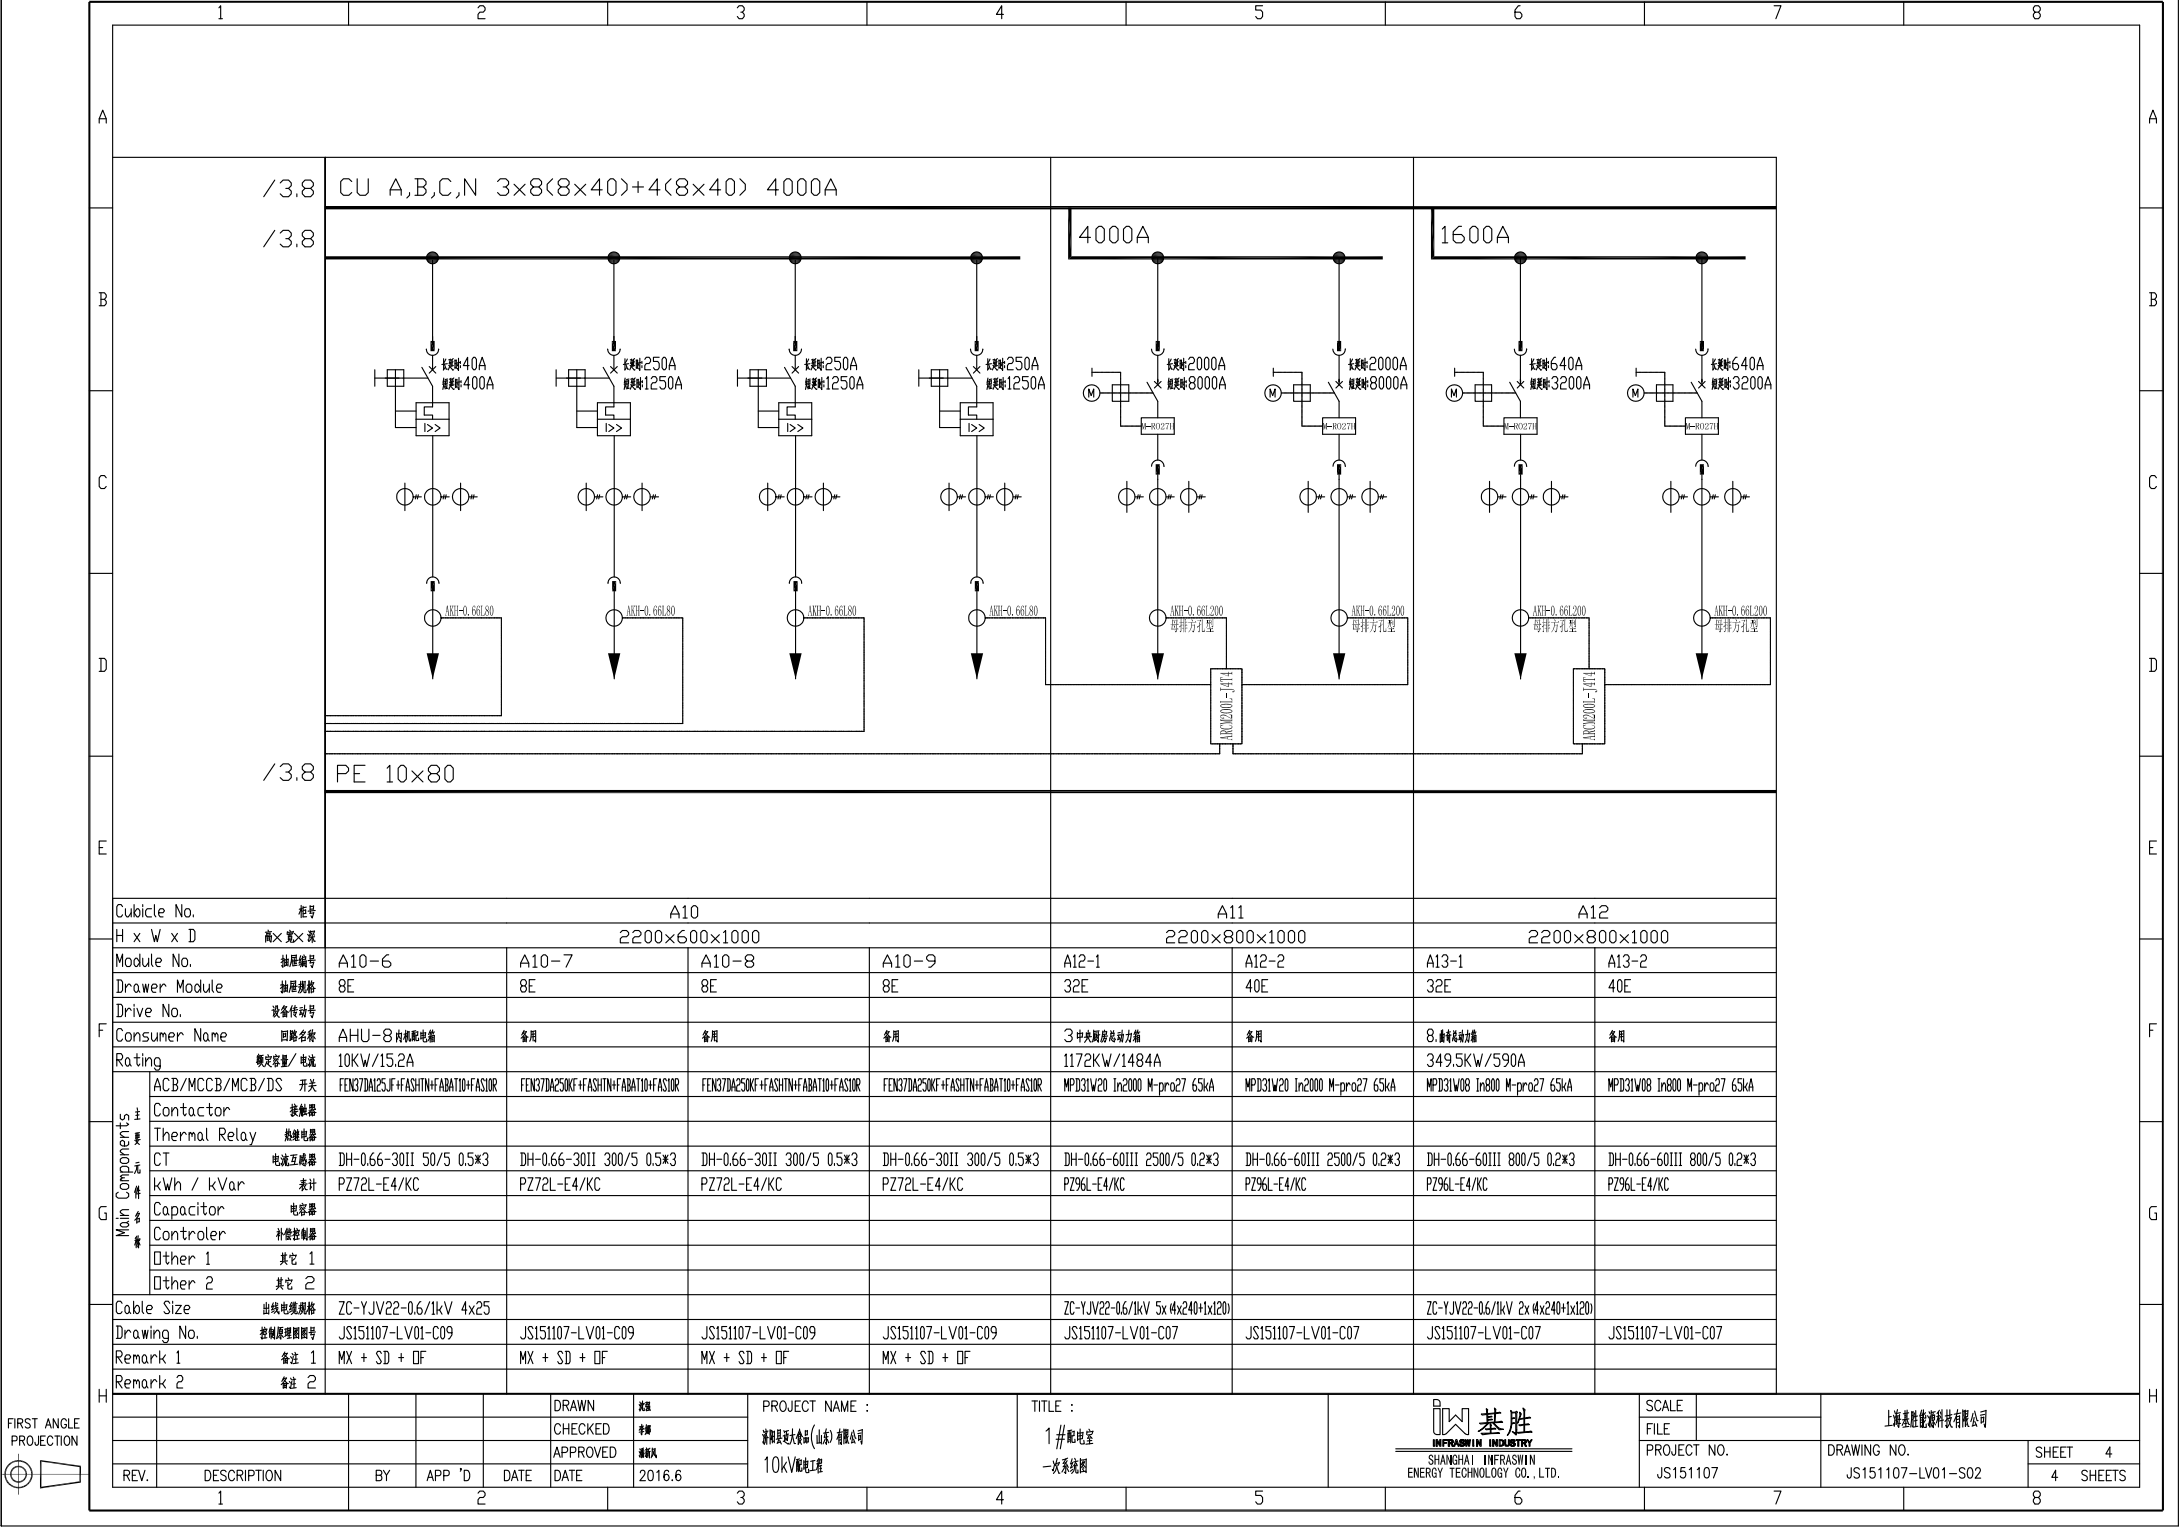


SHANGHAI INFRASIN ENERGY TECHNOLOGY CO., LTD.	上海基胜能源科技有限公司
PROJECT NO. JS151107	DRAWING NO. JS151107-LV01-S02
SHEET 4	4 SHEETS

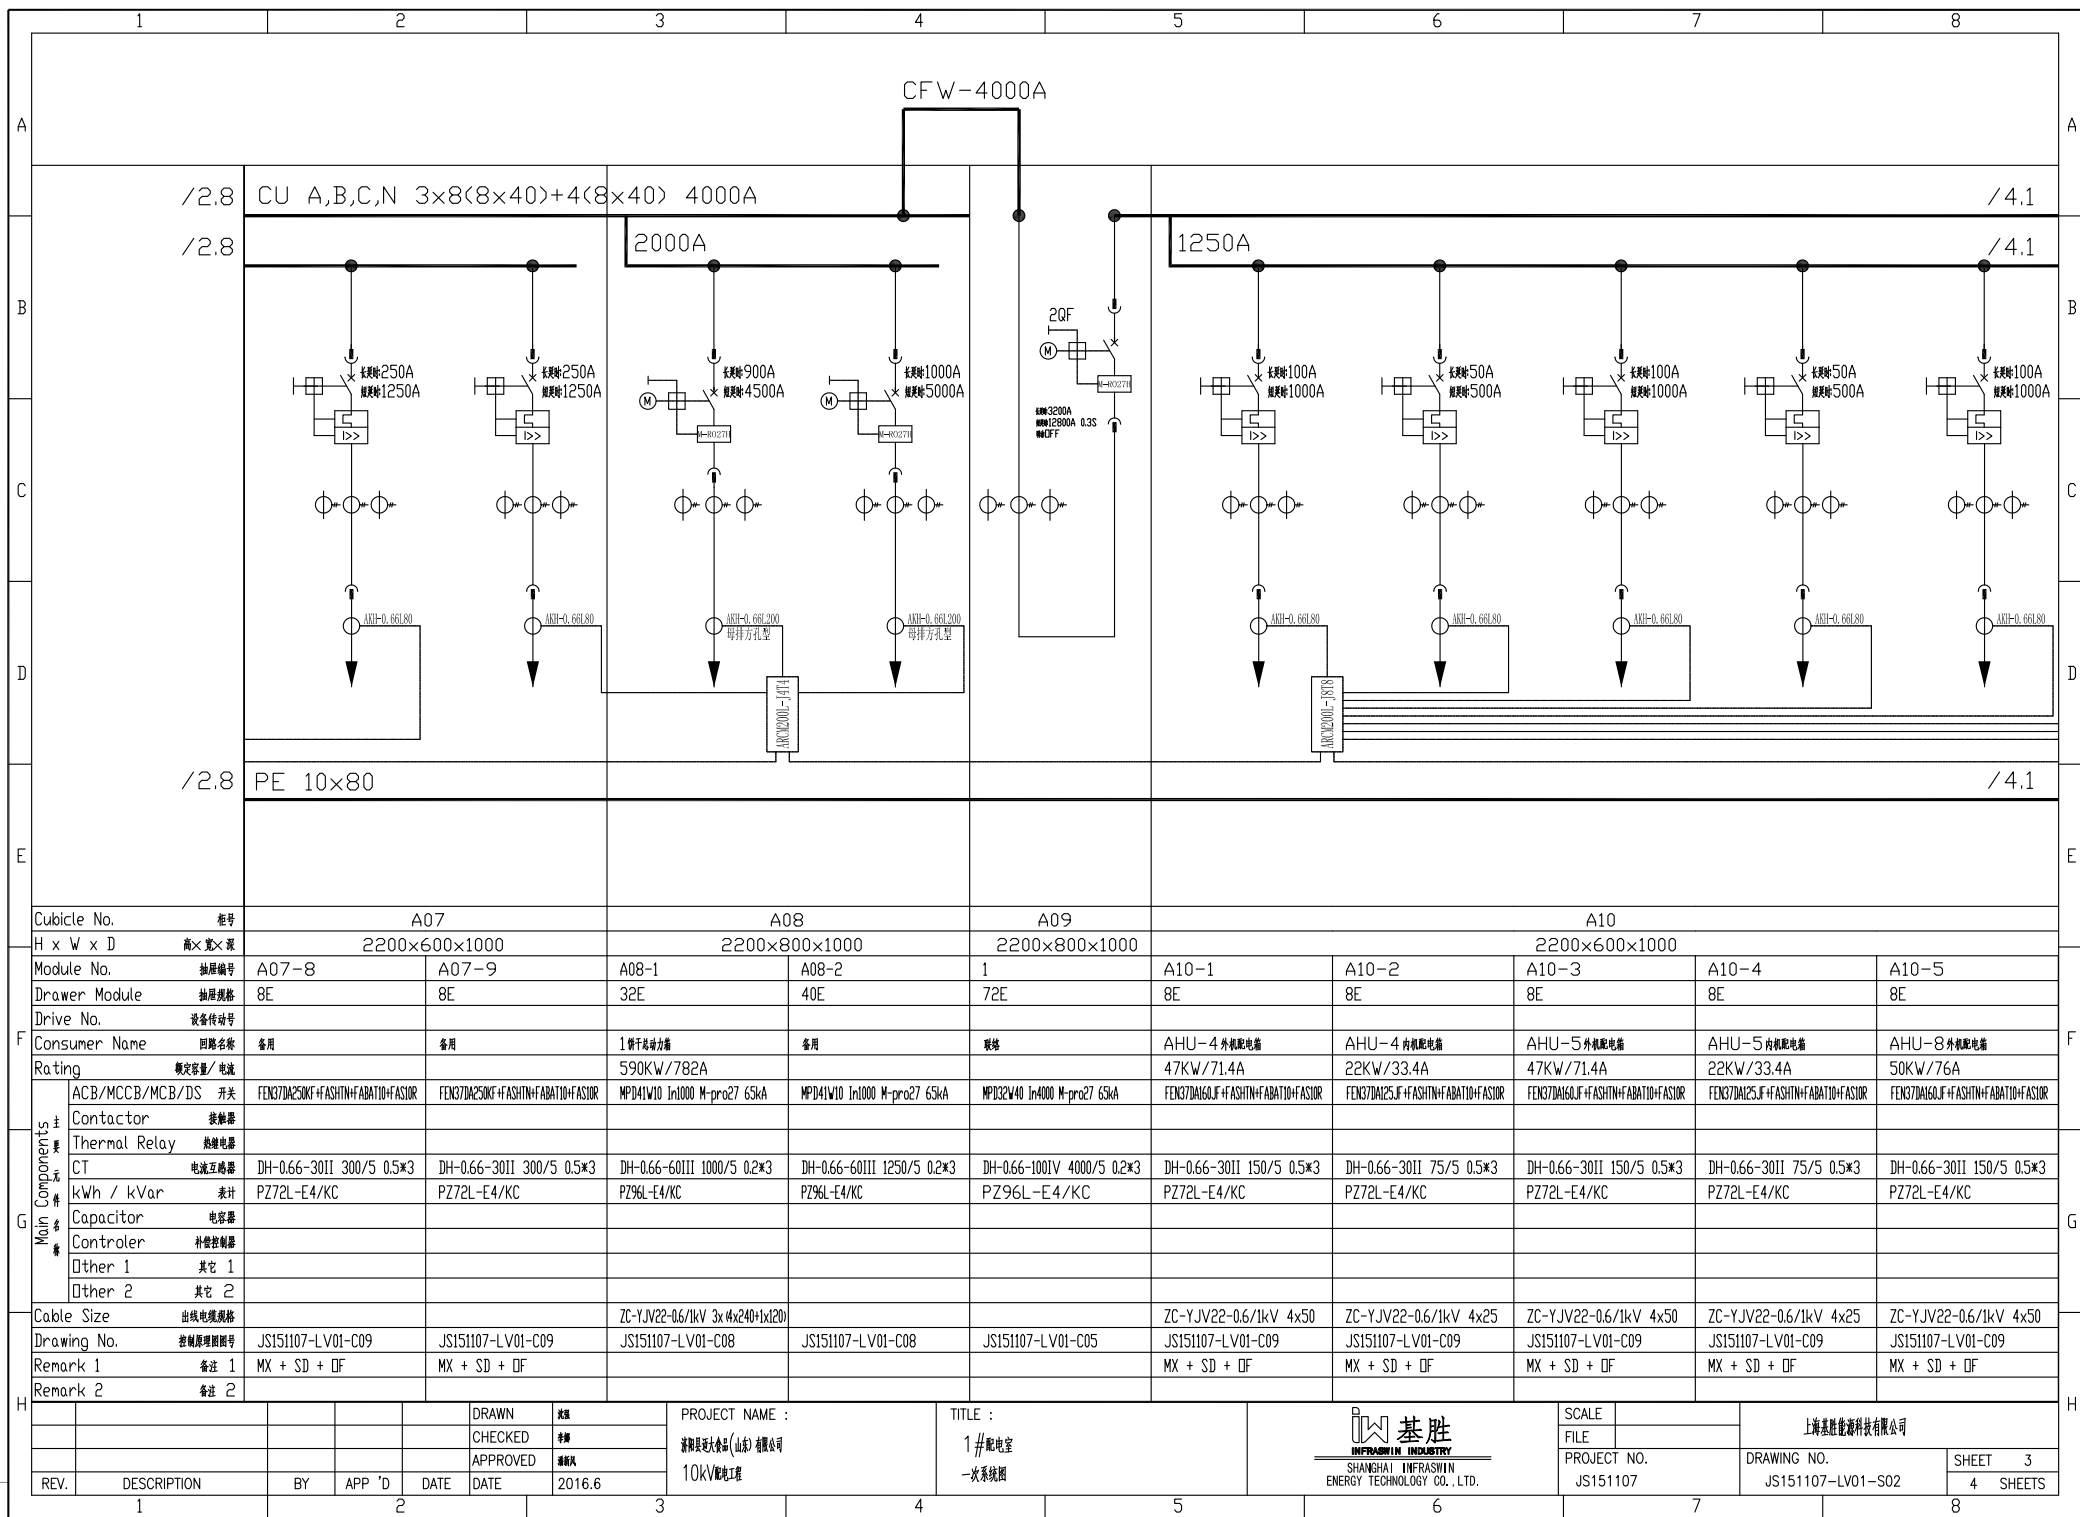

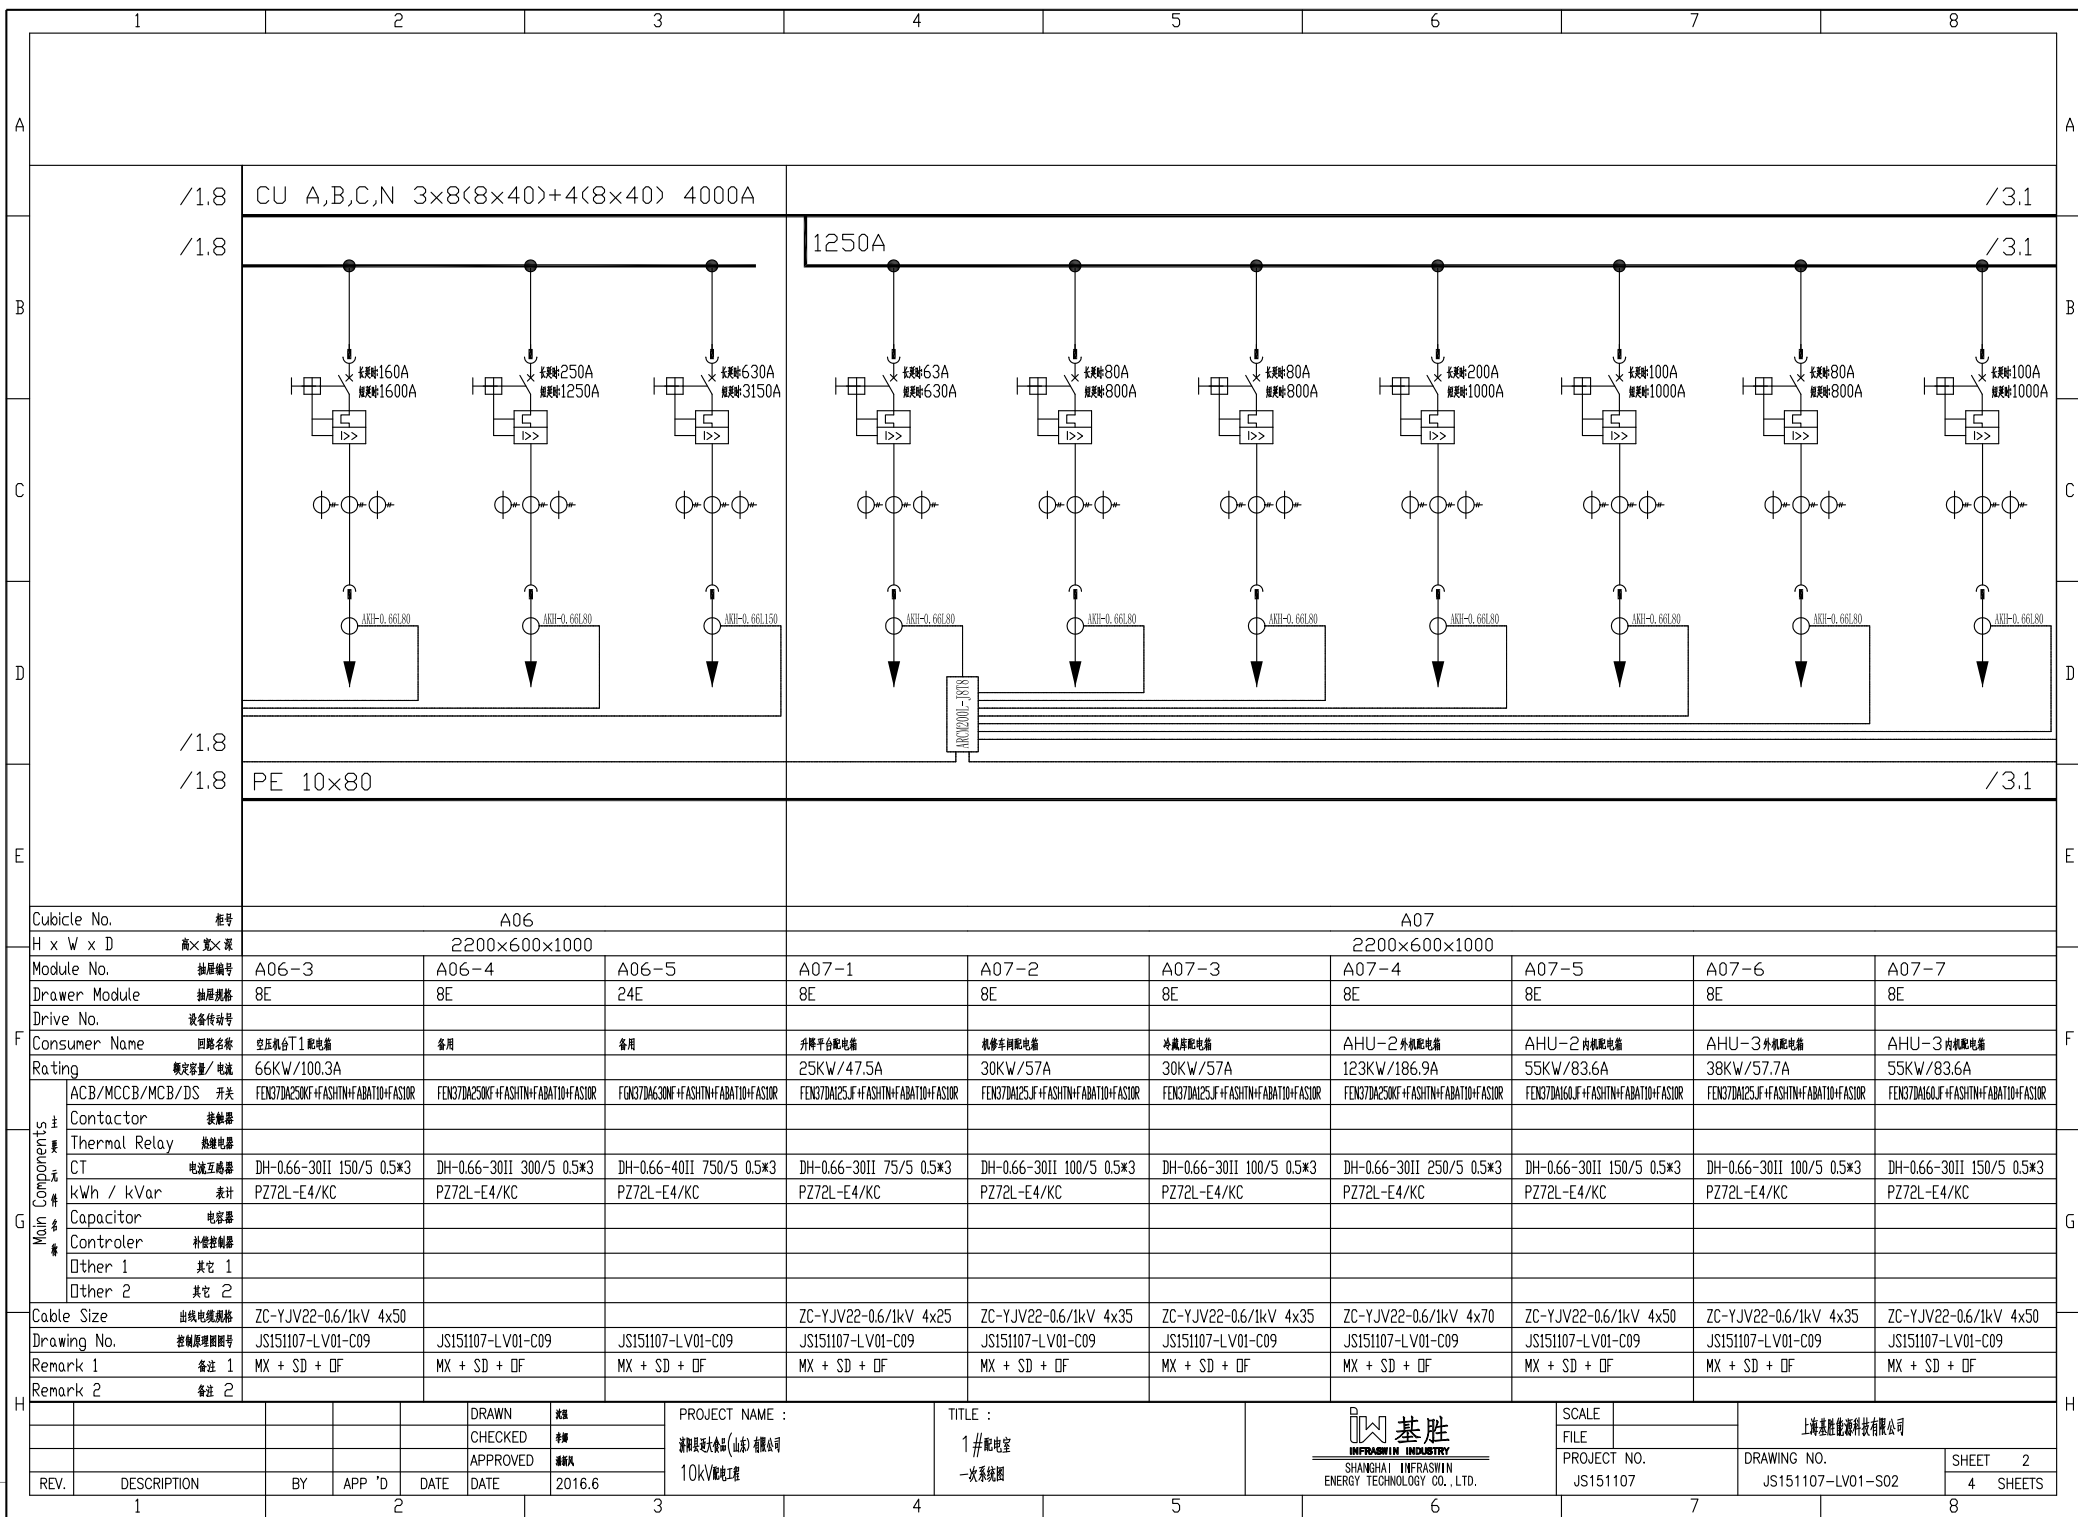

FIRST ANGLE
PROJECTION

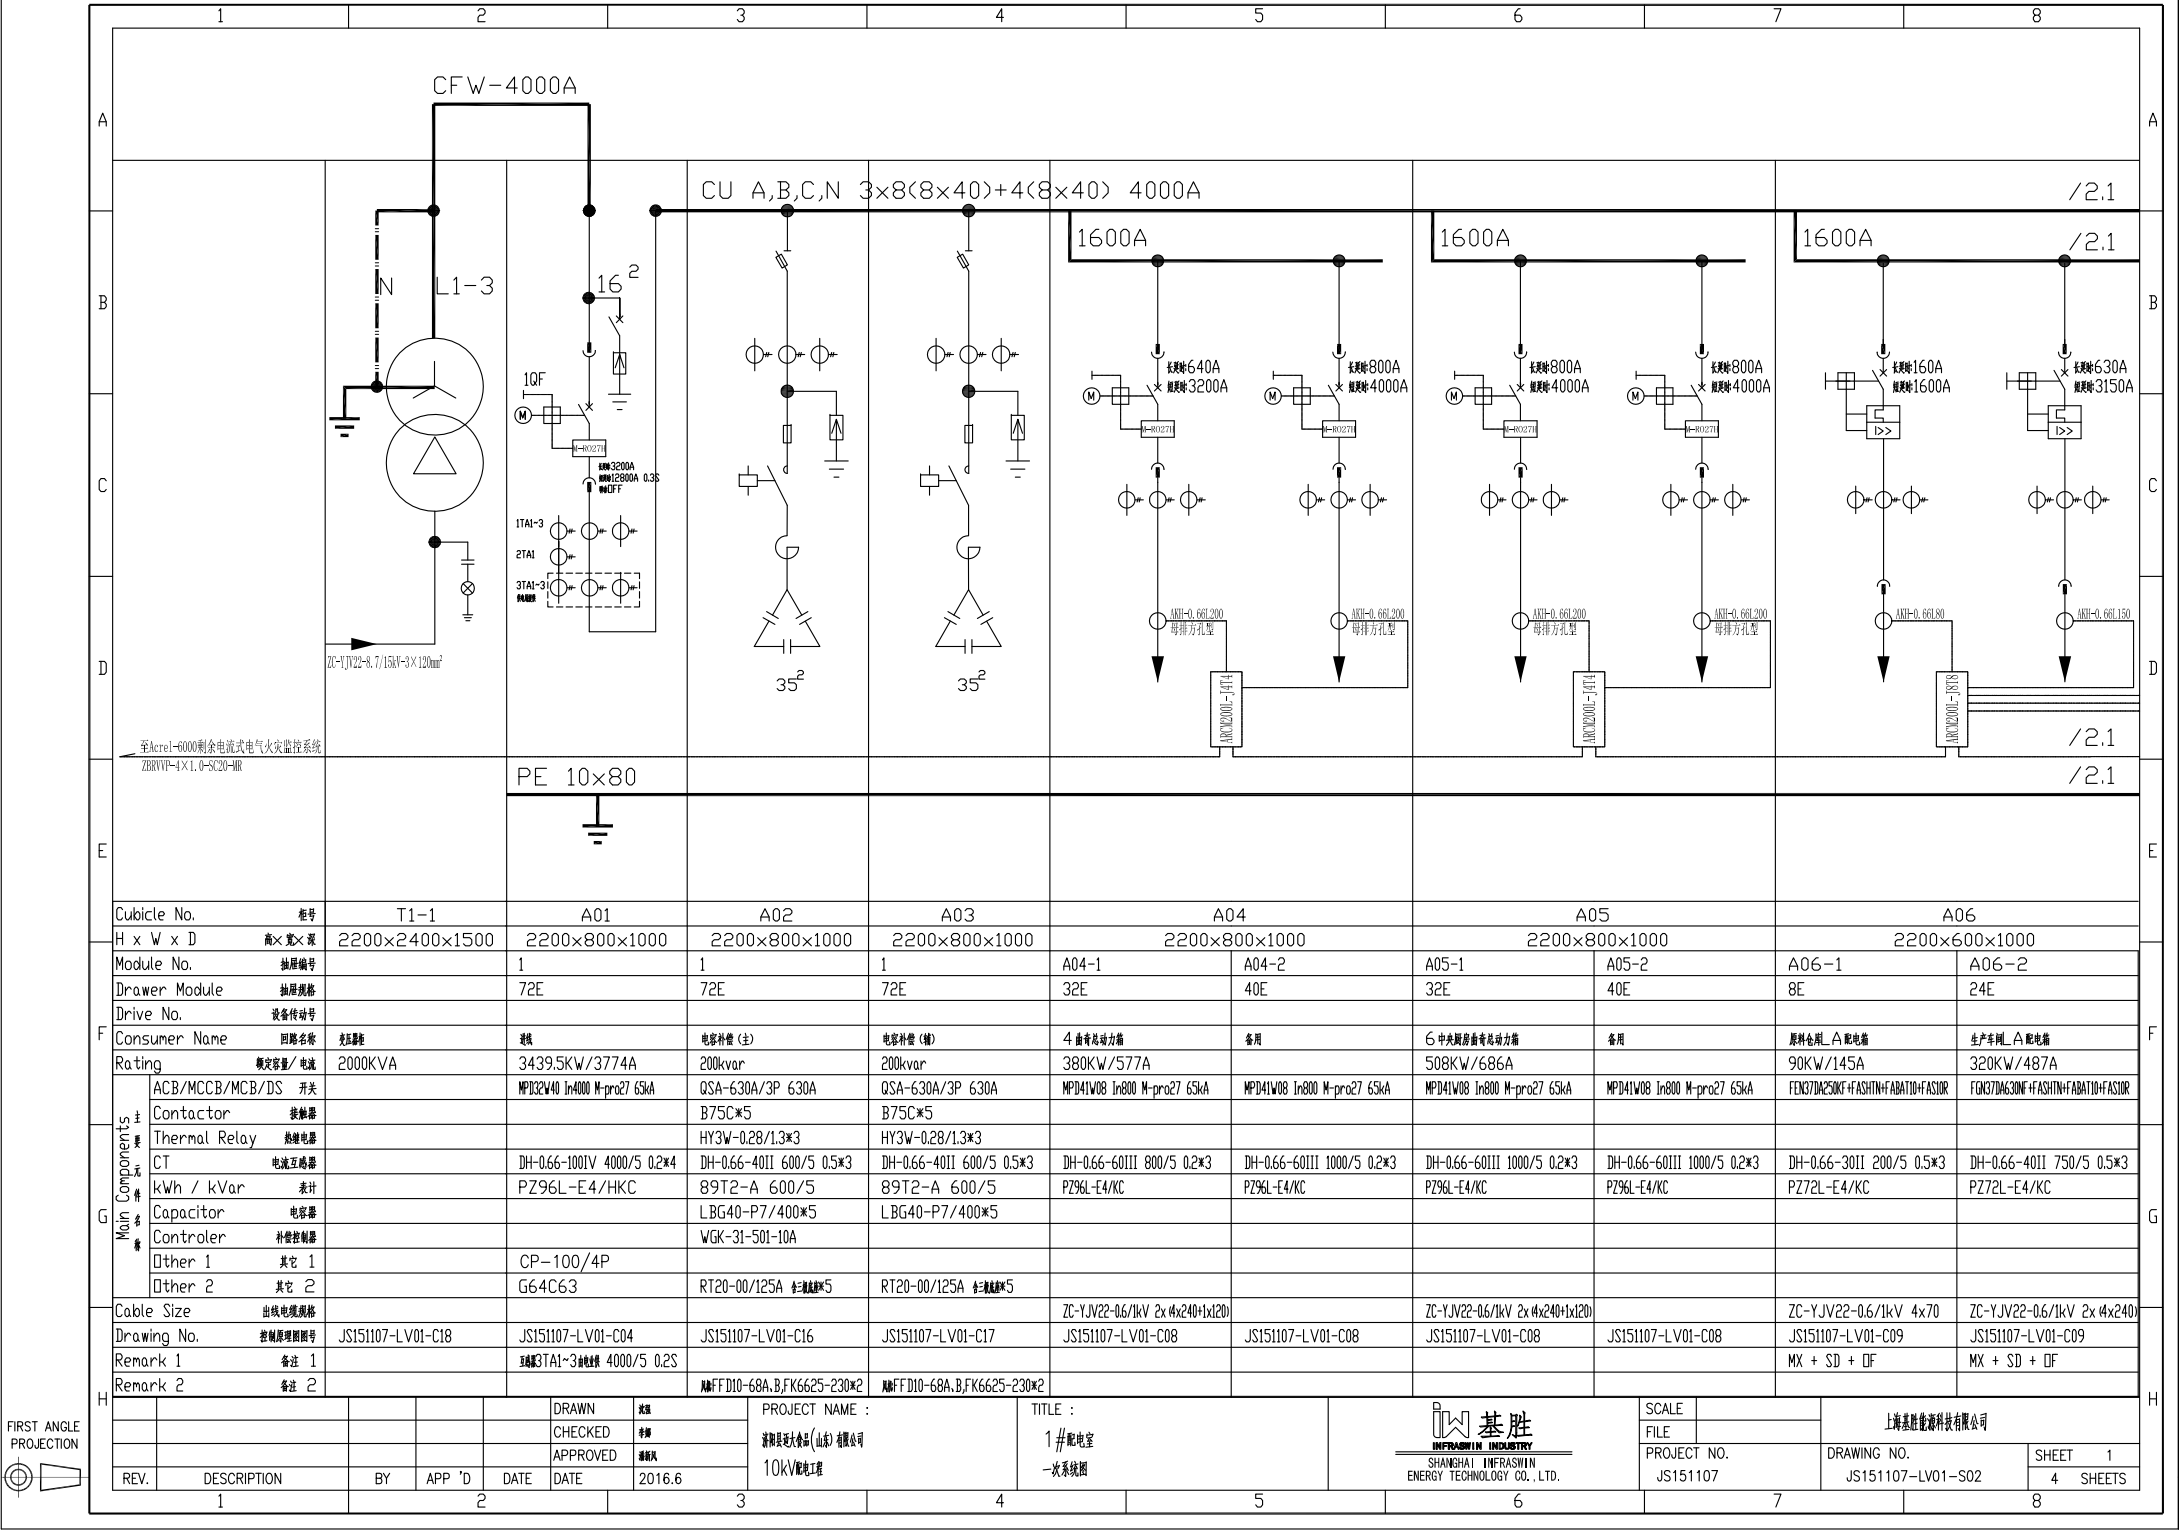

Cubicle No.		柜号	T1-1	A01	A02	A03	A04		A05		A06	
H x W x D		高×宽×深	2200×2400×1500	2200×800×1000	2200×800×1000	2200×800×1000	2200×800×1000		2200×800×1000		2200×600×1000	
Module No.		抽屉编号	1	1	1	1	A04-1	A04-2	A05-1	A05-2	A06-1	A06-2
Drawer Module		抽屉规格	72E	72E	72E	72E	32E	40E	32E	40E	8E	24E
Drive No.		设备传动号										
Consumer Name		回路名称	高压柜	进线	电容补偿 (主)	电容补偿 (辅)	4 座中压站动力箱		6 中央厨房前中压站动力箱		原料仓储_△配电箱	
Rating		额定容量/ 电流	2000KVA	3439.5KW/3774A	200kvar	200kvar	380KW/577A		508KW/686A		90KW/145A	
Main Components	ACB/MCCB/MCB/DS 开关			MPD32W40 In4000 M-pro27 65kA	QSA-630A/3P 630A	QSA-630A/3P 630A	MPD41W08 In800 M-pro27 65kA		MPD41W08 In800 M-pro27 65kA		FEN37DA250K+FASHTN+FABAT10+FASIOR	
	Contactor 接触器				B75C*5	B75C*5					FEN37DA250K+FASHTN+FABAT10+FASIOR	
	Thermal Relay 热继电器				HY3W-0.28/1.3*3	HY3W-0.28/1.3*3						
	CT 电流互感器			DH-0.66-100IV 4000/5 0.2*4	DH-0.66-40II 600/5 0.5*3	DH-0.66-40II 600/5 0.5*3	DH-0.66-60III 800/5 0.2*3		DH-0.66-60III 1000/5 0.2*3		DH-0.66-30II 200/5 0.5*3	
	kWh / kVar 表计			PZ96L-E4/HKC	89T2-A 600/5	89T2-A 600/5	PZ96L-E4/KC		PZ96L-E4/KC		PZ72L-E4/KC	
	Capacitor 电容器				LBG40-P7/400*5	LBG40-P7/400*5						
	Controler 补偿控制器				WGK-3I-50I-10A							
	Other 1 其它 1			CP-100/4P								
	Other 2 其它 2			G64C63	RT20-00/125A 全塑断路器*5	RT20-00/125A 全塑断路器*5						
Cable Size		出线电缆规格					ZC-YJV22-0.6/1kV 2x4x240+1x120		ZC-YJV22-0.6/1kV 2x4x240+1x120		ZC-YJV22-0.6/1kV 4x70	
Drawing No.		控制原理图编号	JS151107-LV01-C18	JS151107-LV01-C04	JS151107-LV01-C16	JS151107-LV01-C17	JS151107-LV01-C08		JS151107-LV01-C08		JS151107-LV01-C09	
Remark 1		备注 1		至3TAI-3的电缆 4000/5 0.2S								
Remark 2		备注 2			至FFD10-68A,B,FK6625-230*2	至FFD10-68A,B,FK6625-230*2					MX + SD + DF	

						DRAWN		沈强		PROJECT NAME :		TITLE :				SCALE				上海基胜能源科技有限公司	
						CHECKED		李峰		济阳县远大食品(山东)有限公司		1#配电室		INFRASWIN INDUSTRY		FILE					
						APPROVED		潘朝凤		10kV配电工程		一次系统图		SHANGHAI INFRASWIN ENERGY TECHNOLOGY CO.,LTD.		PROJECT NO.		DRAWING NO.		SHEET 1	
REV.		DESCRIPTION		BY		APP 'D		DATE		2016.6						JS151107		JS151107-LV01-S02		4 SHEETS	



FIRST ANGLE
PROJECTION

1		2		3		4		5		6		7		8	
A		B		C		D		E		F		G		H	
/1.8		/1.8		CU A,B,C,N 4×2(8×30) 100DA											
/1.8		PE 8×40													
/1.8															
Cubicle No.		柜号		D4		D5		D6		T					
H x W x D		高×宽×深		2200×600×1000		2200×800×1000		2200×800×1000		2200×1600×1200					
Module No.		抽屉编号		D4-4		D4-5		1		1					
Drawer Module		抽屉规格		16E		16E		72E		72E					
Drive No.		设备传动号													
Consumer Name		回路名称		备用		备用		电容补偿		电容补偿		电容补偿			
Rating		额定容量/ 电流				150kvar				500KVA					
Main Components	主要元件名称	ACB/MCCB/MCB/DS 开关		FGK37DM400LF+ASHTN+FBAT10+FASSOR		FGK37DM400LF+ASHTN+FBAT10+FASSOR		QSA-400A/3P 400A		MPD31W10 In1000 M-pro27 63kA					
		Contactor 接触器													
		Thermal Relay 热继电器				HY3W-0.28/1.3*3									
		CT 电流互感器		DH-0.66-301I 400/5 0.5*3		DH-0.66-301I 400/5 0.5*3		DH-0.66-301I 400/5 0.5*3		DH-0.66-601III 1000/5 0.2*6					
		kWh / kVar 表计		PZ72L-E4/KC		PZ72L-E4/KC		8972-A 400/5		PZ96L-E4/KC					
		Capacitor 电容器													
		Controler 补偿控制				WGK-31-201-F									
		Other 1 其它 1						CP-100/4P							
Cable Size		出线电缆规格								G64C63					
Drawing No.		控制原理图图号		JS151107-LV01-C09		JS151107-LV01-C09		JS151107-LV01-C15		JS151107-LV01-C03		JS151107-LV01-C18			
Remark 1		备注 1		MX + SD + OF		MX + SD + OF									
Remark 2		备注 2				MFDD10-68A,B,FK6625-230*2									