


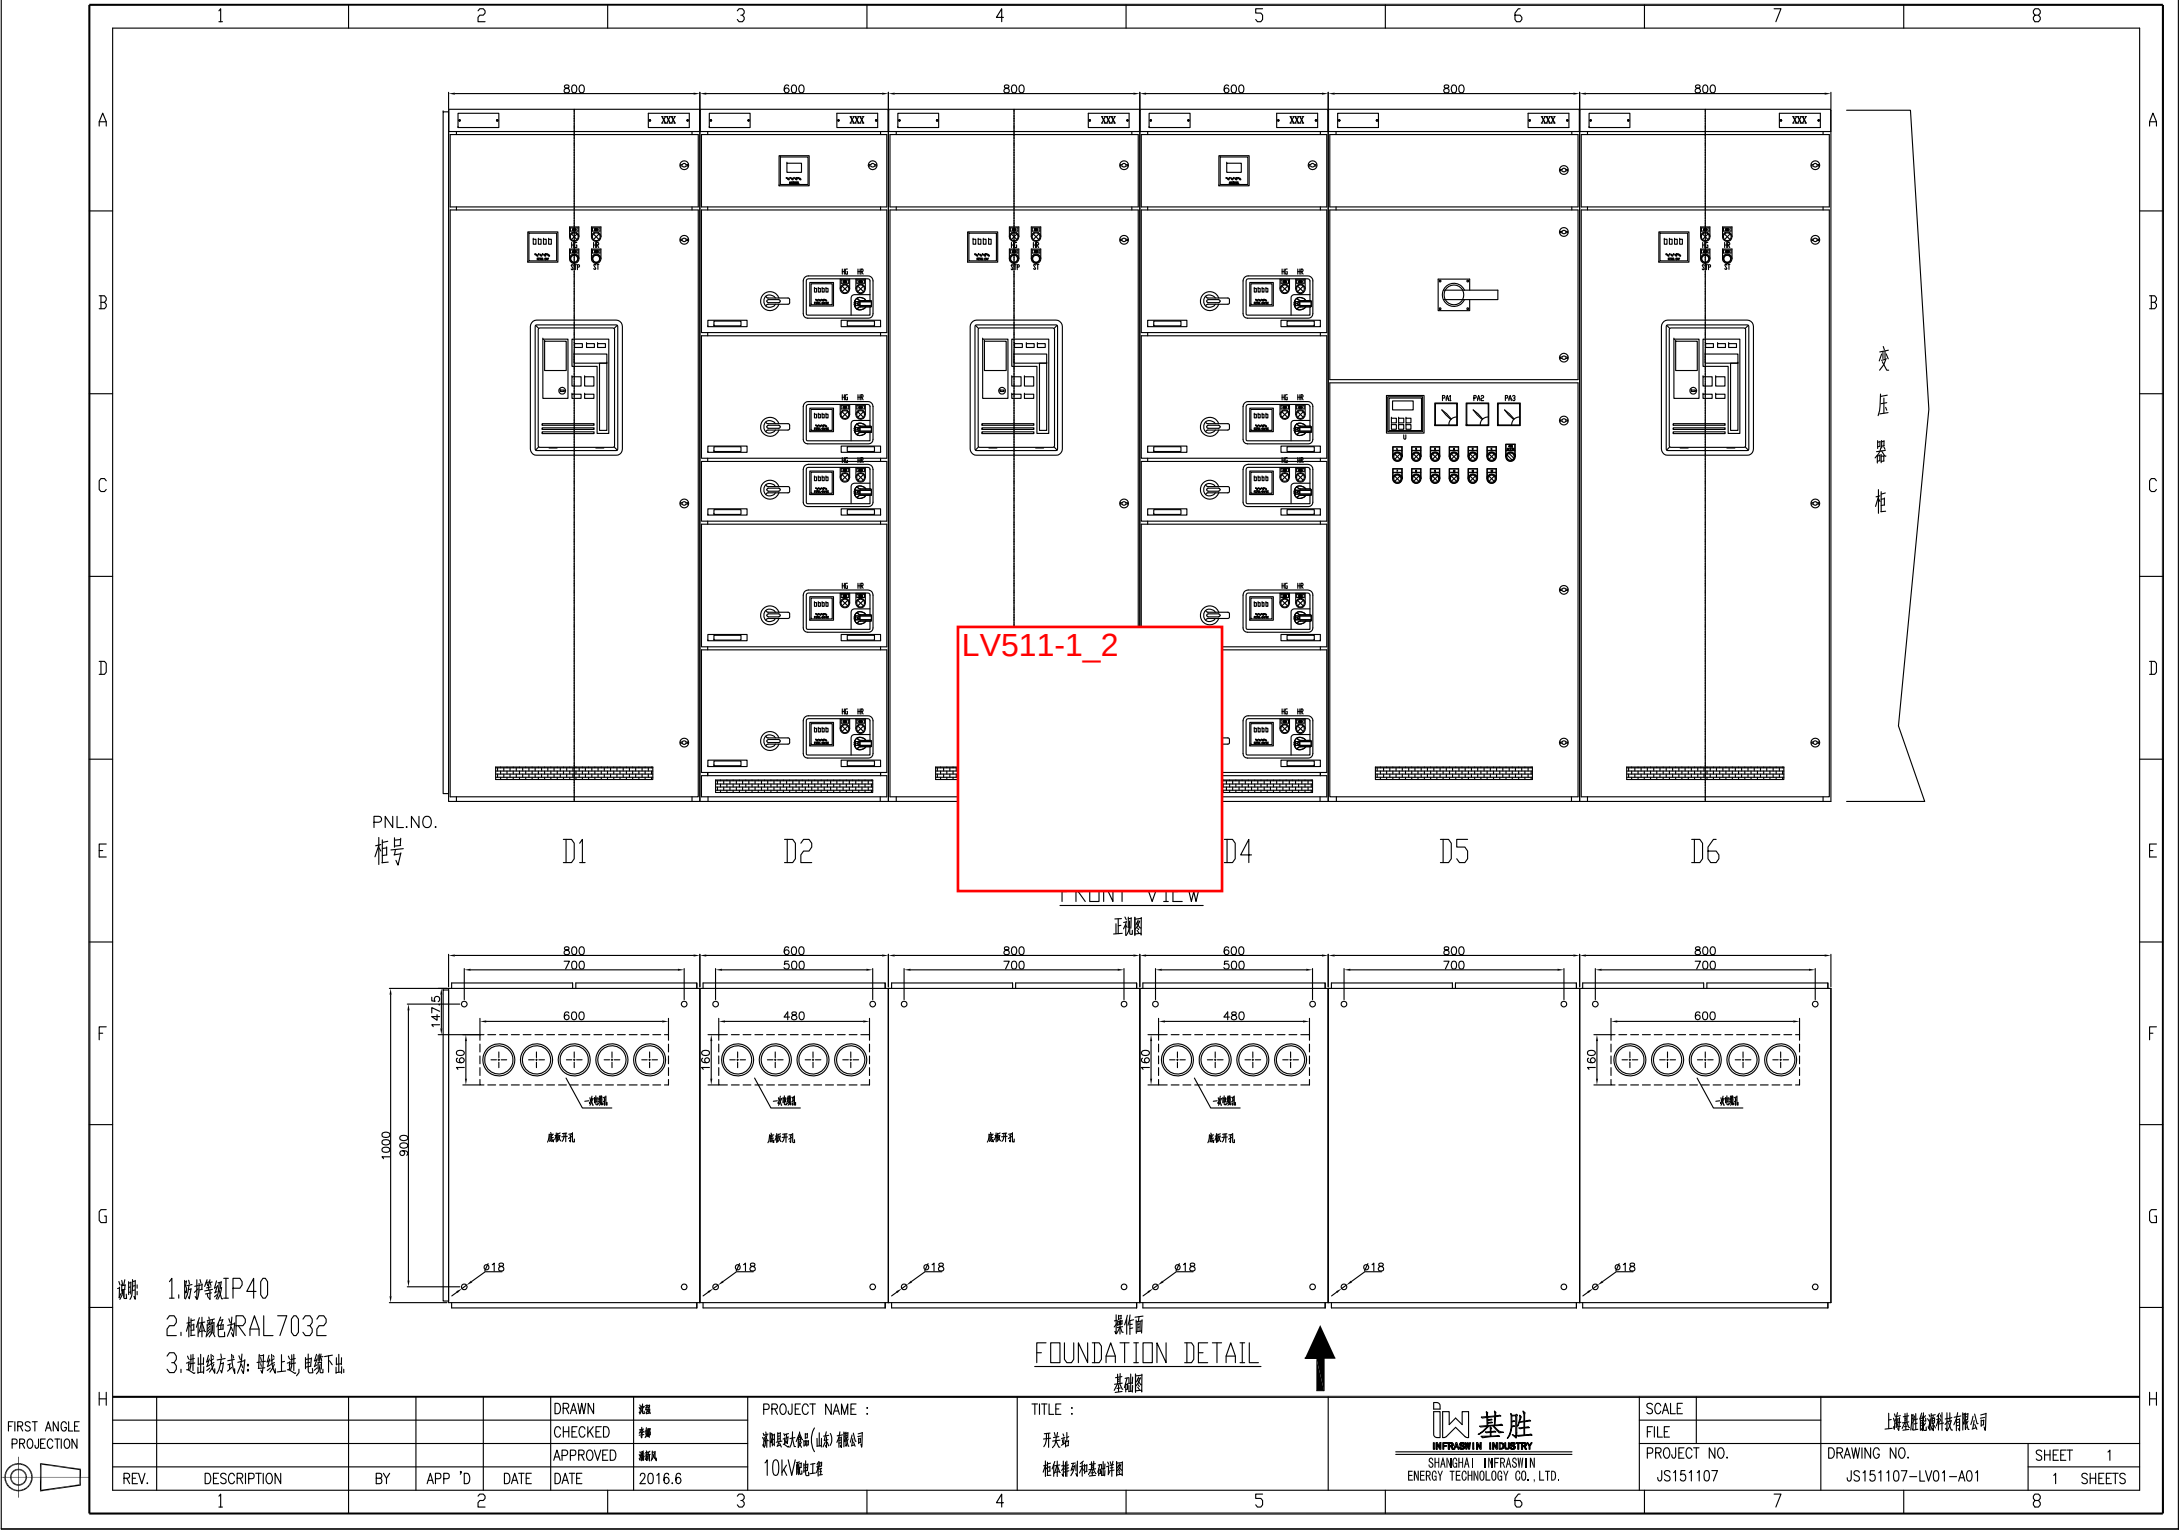

LV511-1\_2

FRONT VIEW

正视图


FOUNDATION DETAIL  
基础图


- 说明
- 1. 防护等级IP40
  - 2. 柜体颜色为RAL7032
  - 3. 进出线方式为: 母线上进, 电缆下出




FIRST ANGLE  
PROJECTION

|          |             |                                                |     |           |      |             |  |              |  |          |  |
|----------|-------------|------------------------------------------------|-----|-----------|------|-------------|--|--------------|--|----------|--|
| DRAWN    |             | PROJECT NAME :                                 |     | TITLE :   |      | SCALE       |  | DRAWING NO.  |  | SHEET 1  |  |
| CHECKED  |             | SHANGHAI INFRASWIN ENERGY TECHNOLOGY CO., LTD. |     | 开关站       |      | FILE        |  | JS151107-A01 |  | 1 SHEETS |  |
| APPROVED |             | 10KV配电工程                                       |     | 柜体排列和基础详图 |      | PROJECT NO. |  |              |  |          |  |
| DATE     |             | 2016.6                                         |     |           |      | JS151107    |  |              |  |          |  |
| REV.     | DESCRIPTION | BY                                             | APP | D         | DATE |             |  |              |  |          |  |
| 1        |             |                                                |     |           |      |             |  |              |  |          |  |

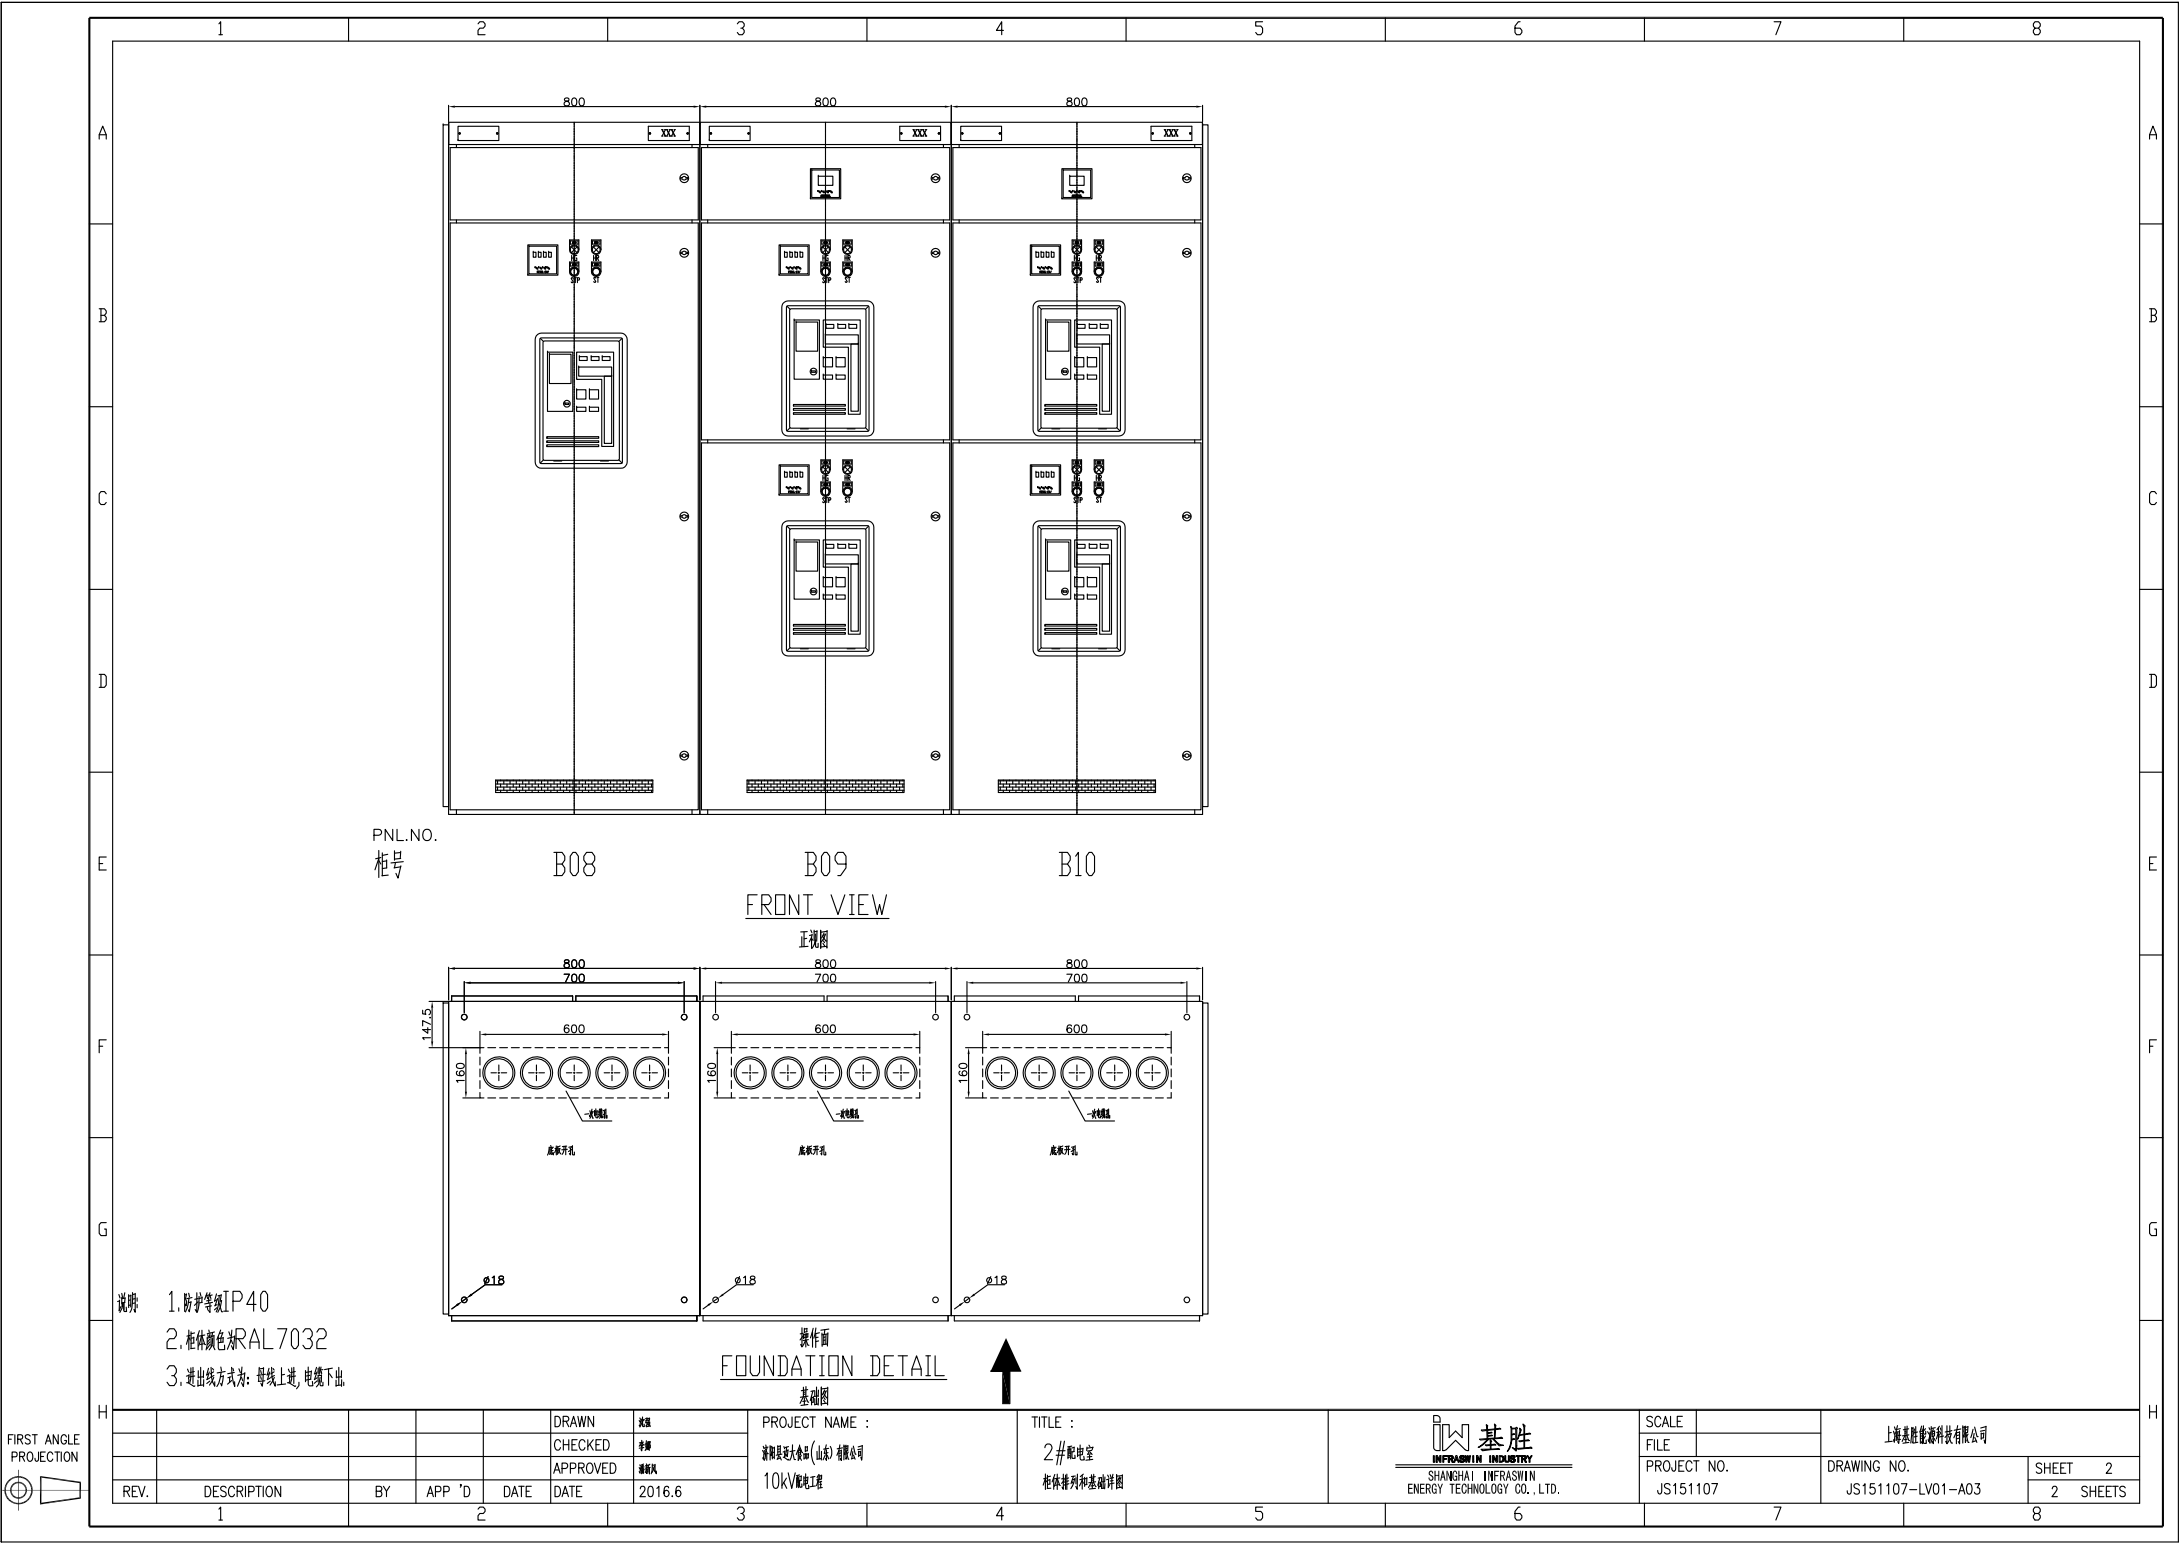

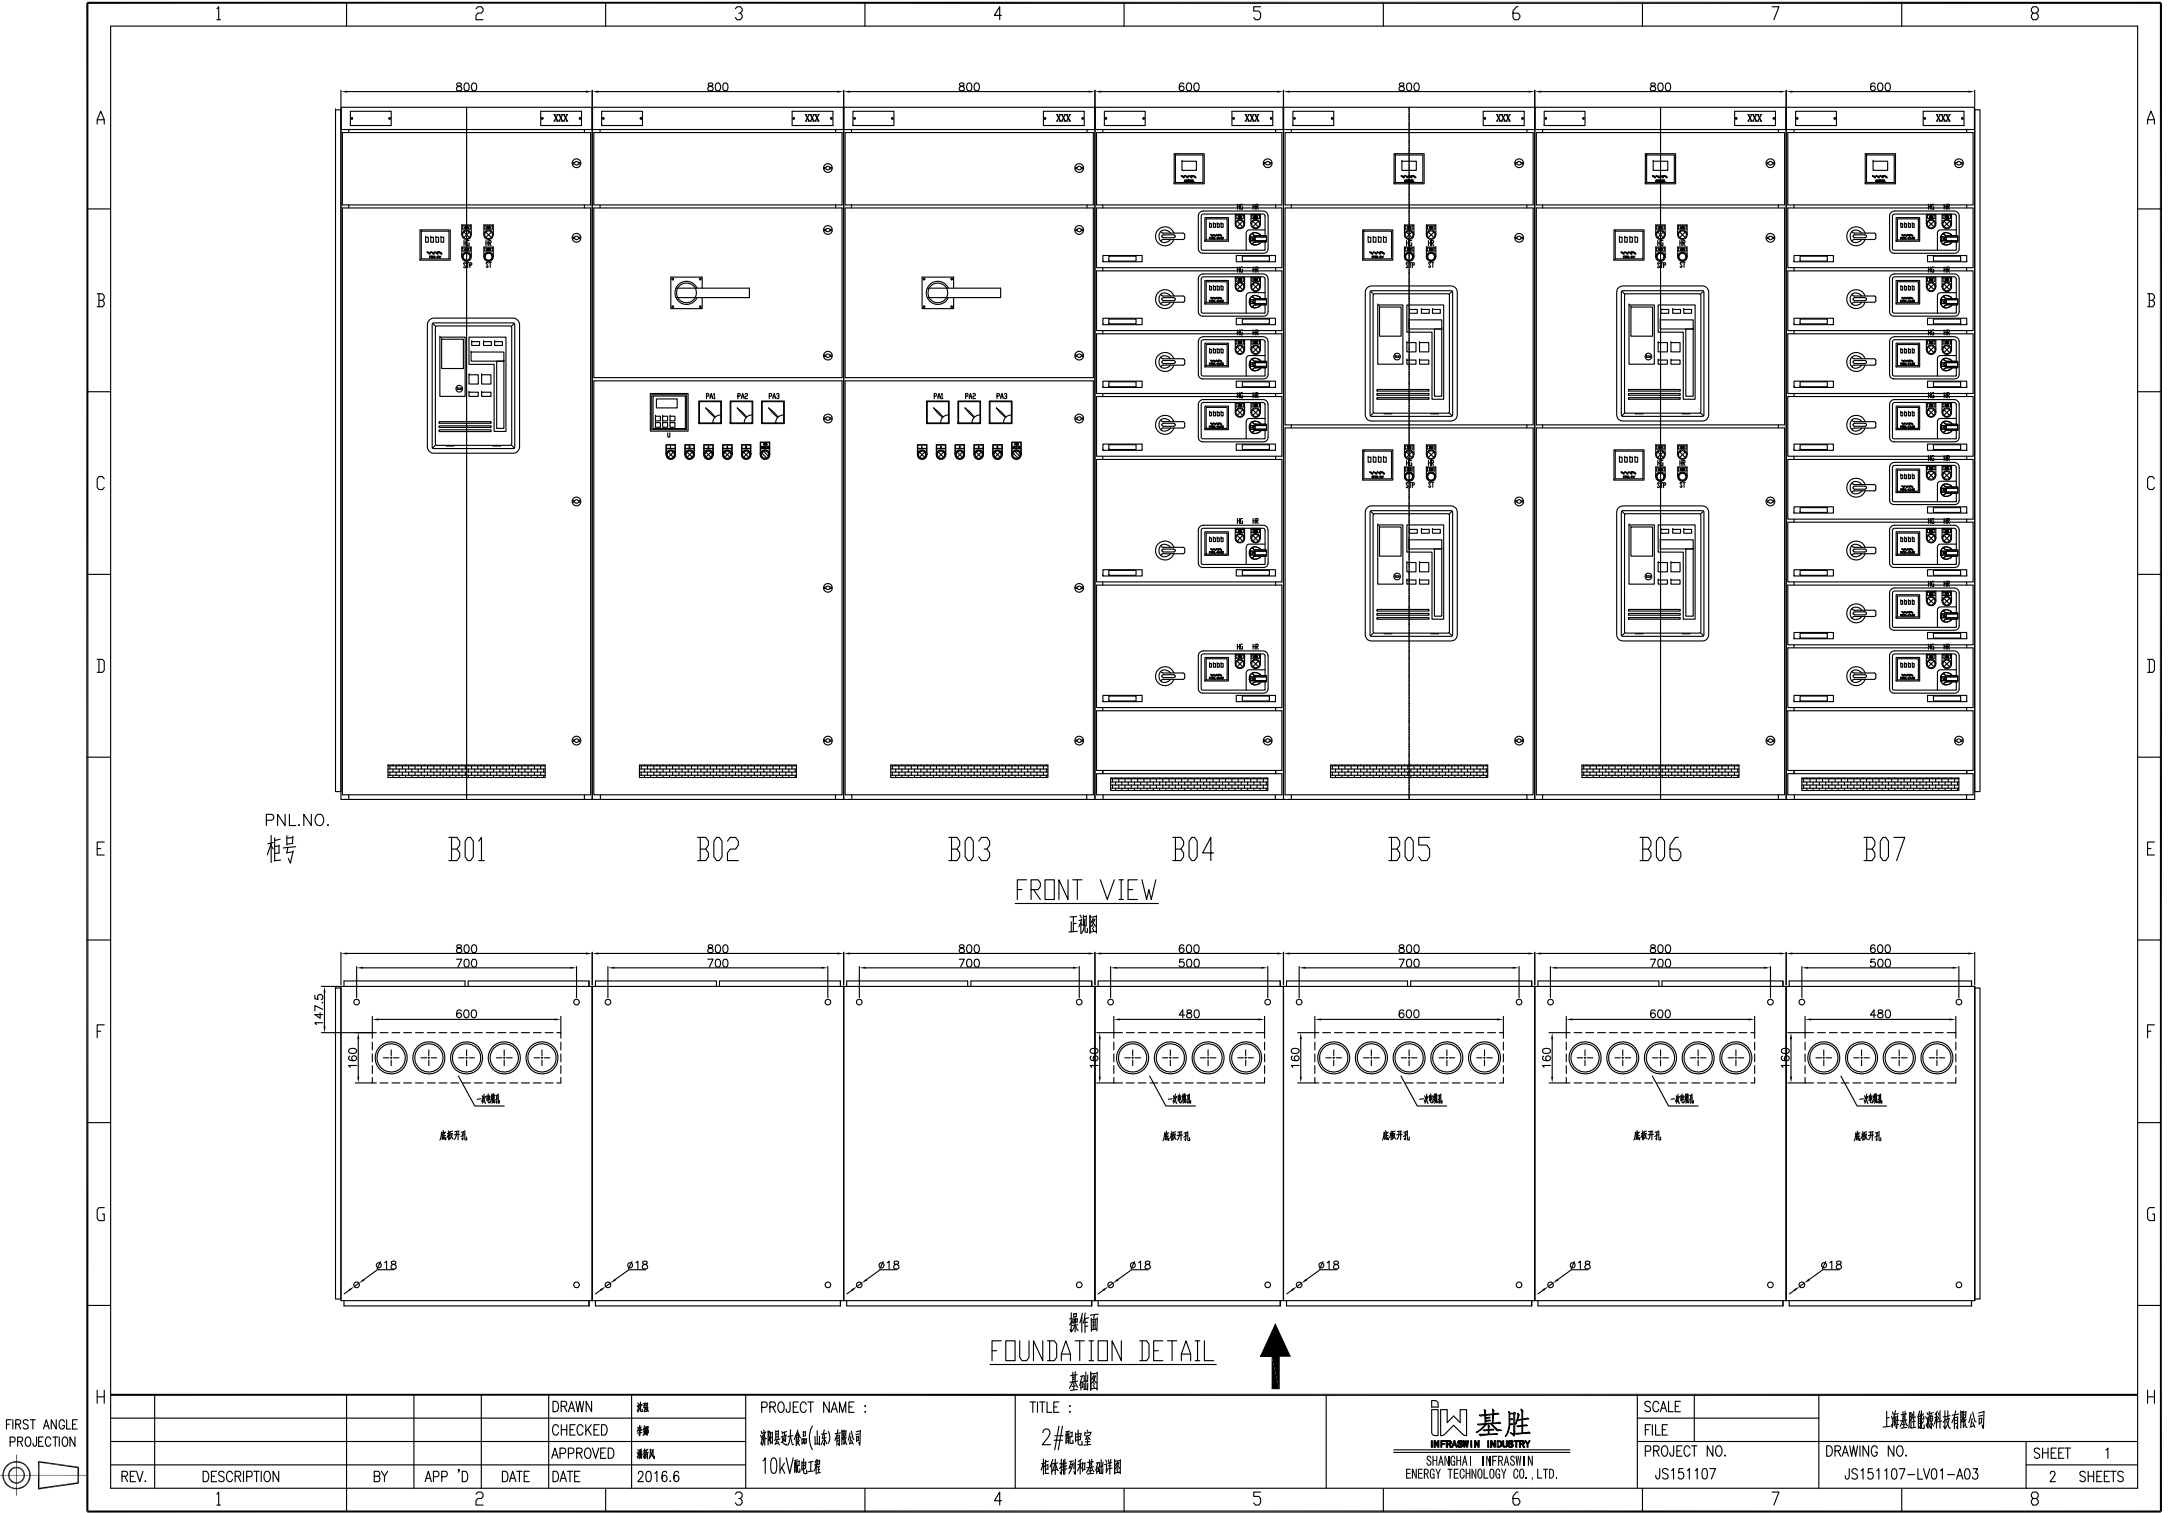

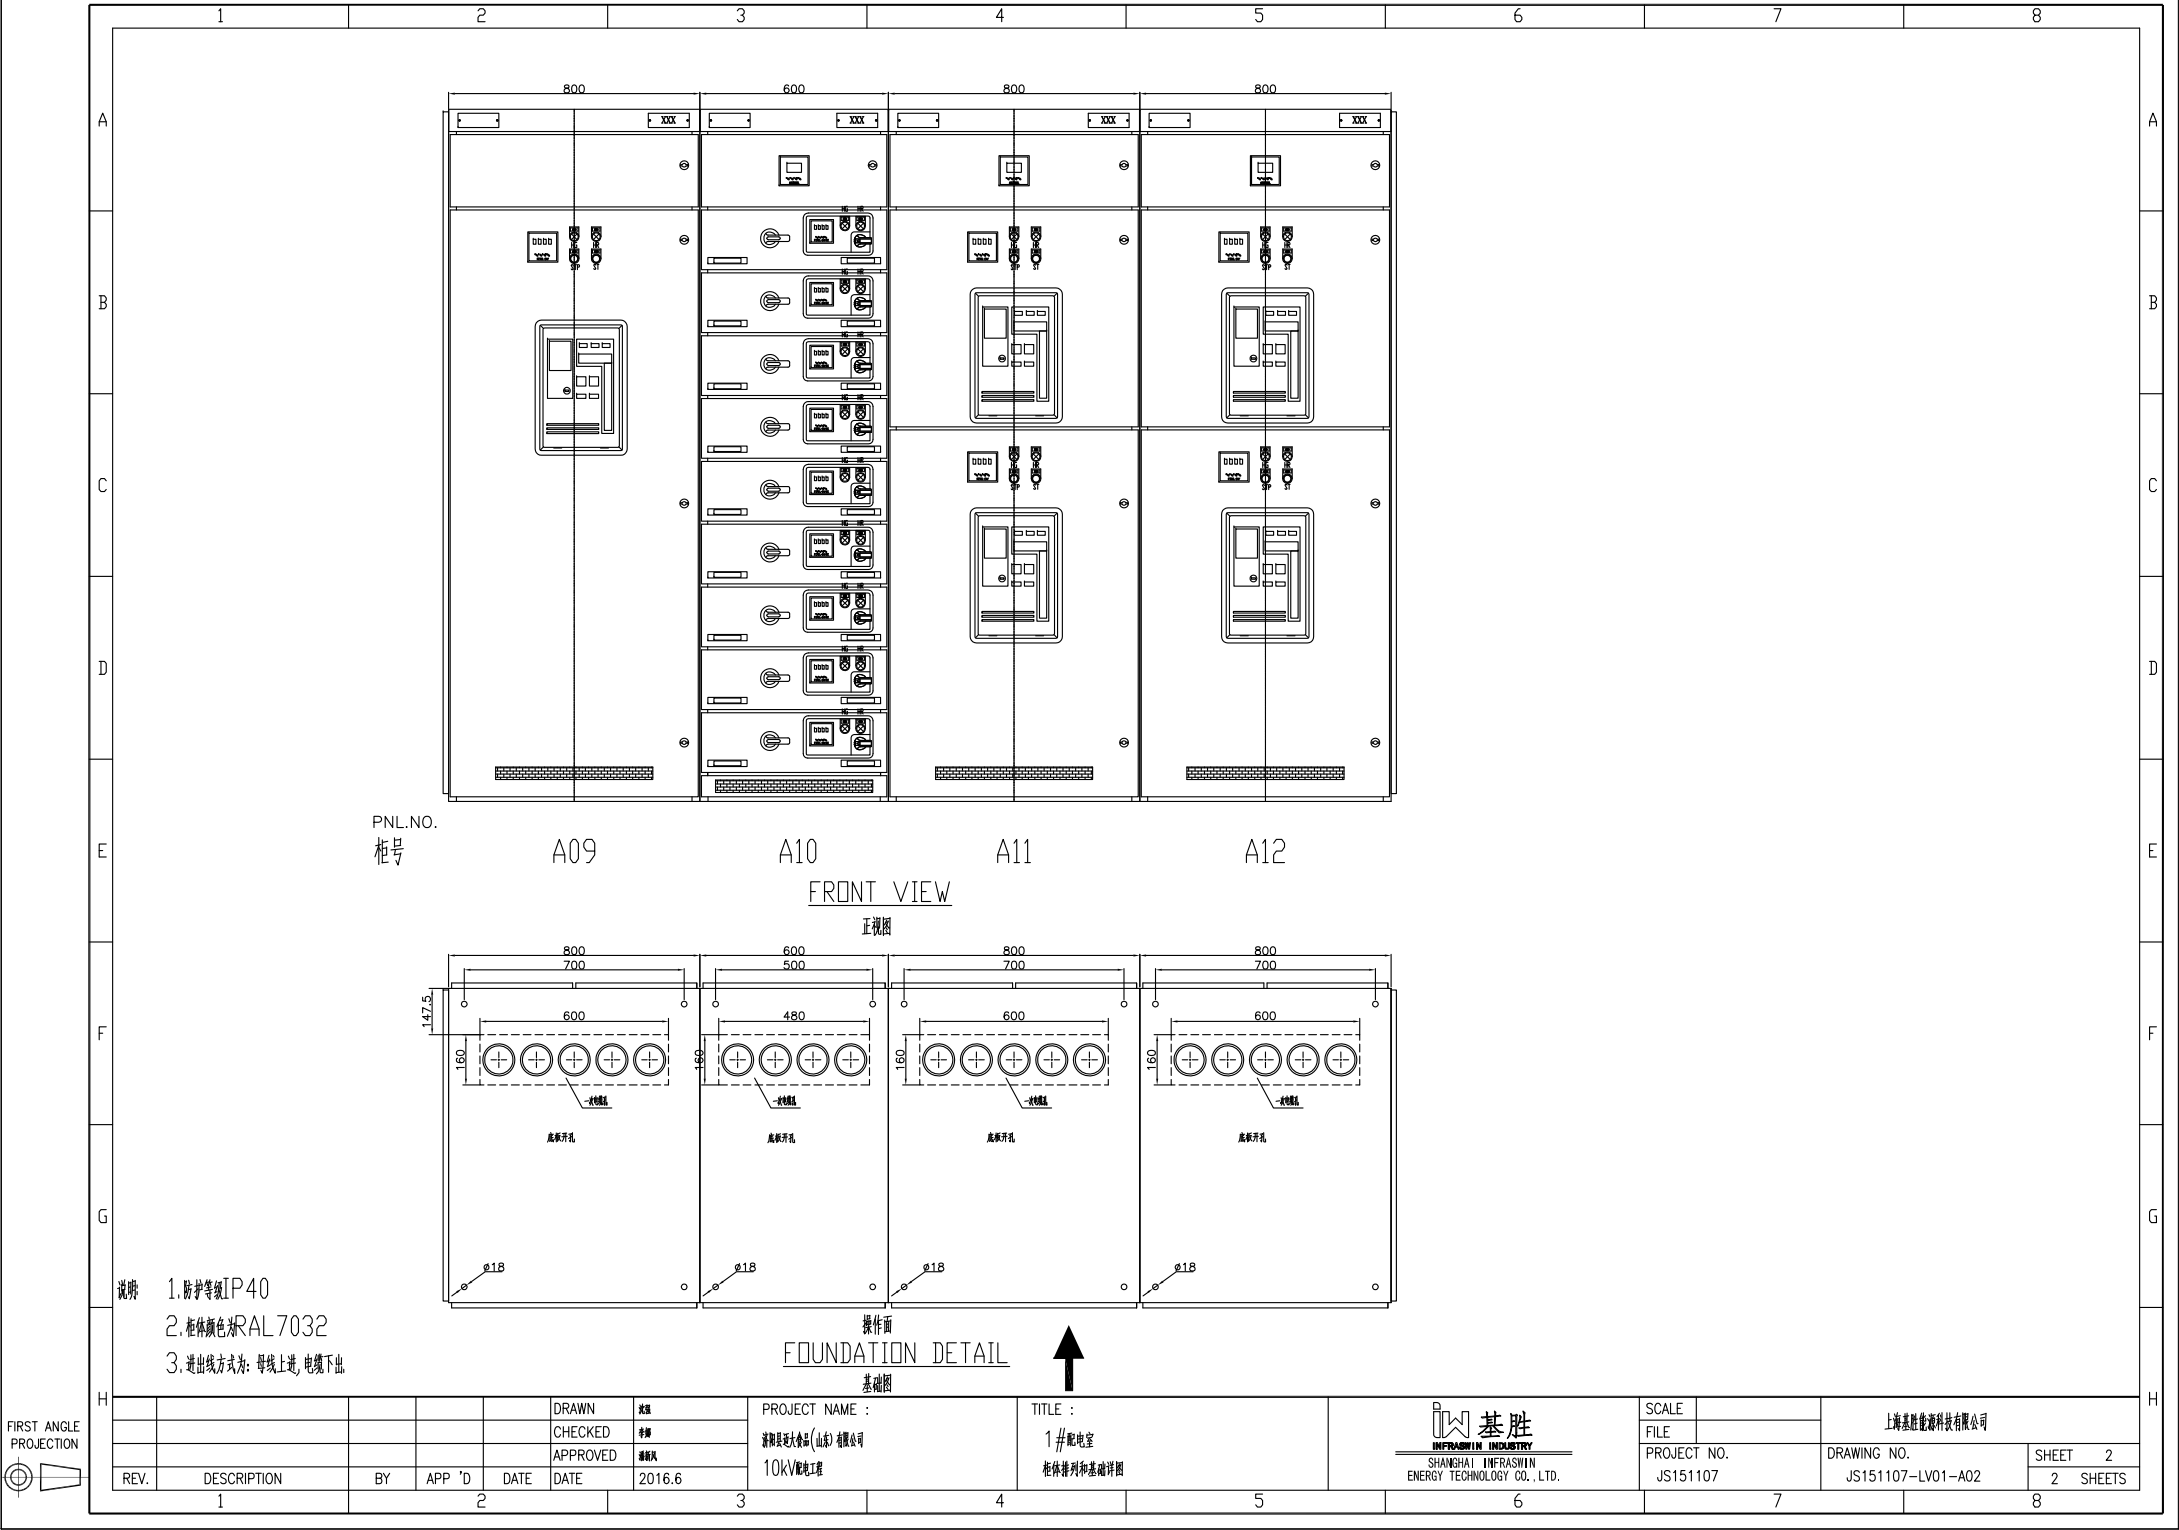

PNL.NO.  
柜号

A09


A10

A11

A12

FRONT VIEW

正视图

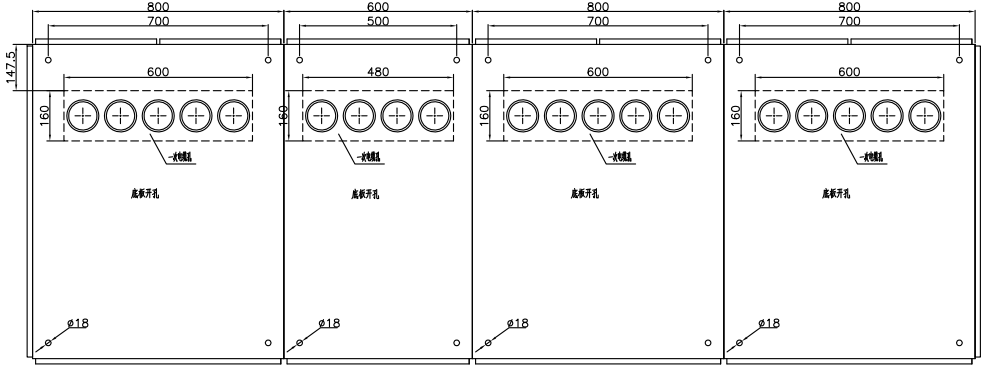

操作面  
FOUNDATION DETAIL


基础图

- 说明
1. 防护等级IP40
  2. 柜体颜色为RAL7032
  3. 进出线方式为: 母线上进, 电缆下出




FIRST ANGLE  
PROJECTION

|      |  |------|--|-------------|--|----|--|----------|--|------|--|----------------|--|--|--|-----------|--|--|--|------------------------------------------------------------------------------------------------------------------------------------------------------------|--|--|--|-------------------|--|-------|--|--------------|--|---|--|
|      |  |             |  |    |  | DRAWN    |  | 审核   |  | PROJECT NAME : |  |  |  | TITLE :   |  |  |  | <div><div><div></div><div></div><div></div></div><div>基胜</div><div>INFRASWIN INDUSTRY</div><div>SHANGHAI INFRASWIN ENERGY TECHNOLOGY CO., LTD.</div></div> |  |  |  | SCALE             |  |       |  | 上海基胜能源科技有限公司 |  |   |  |
|      |  |             |  |    |  | CHECKED  |  | 审核   |  | 项目             |  |  |  | 1#配电室     |  |  |  | FILE                                                                                                                                                       |  |  |  |                   |  |       |  |              |  |   |  |
|      |  |             |  |    |  | APPROVED |  | 审核   |  | 项目             |  |  |  | 柜体排列和基础详图 |  |  |  | PROJECT NO.                                                                                                                                                |  |  |  | DRAWING NO.       |  | SHEET |  |              |  |   |  |
| REV. |  | DESCRIPTION |  | BY |  | APP 'D   |  | DATE |  | 2016.6         |  |  |  |           |  |  |  | JS151107                                                                                                                                                   |  |  |  | JS151107—LV01—A02 |  | 2     |  |              |  |   |  |
| 1    |  |             |  | 2  |  |          |  |      |  | 3              |  |  |  | 4         |  |  |  | 5                                                                                                                                                          |  |  |  | 6                 |  |       |  | 7            |  | 8 |  |

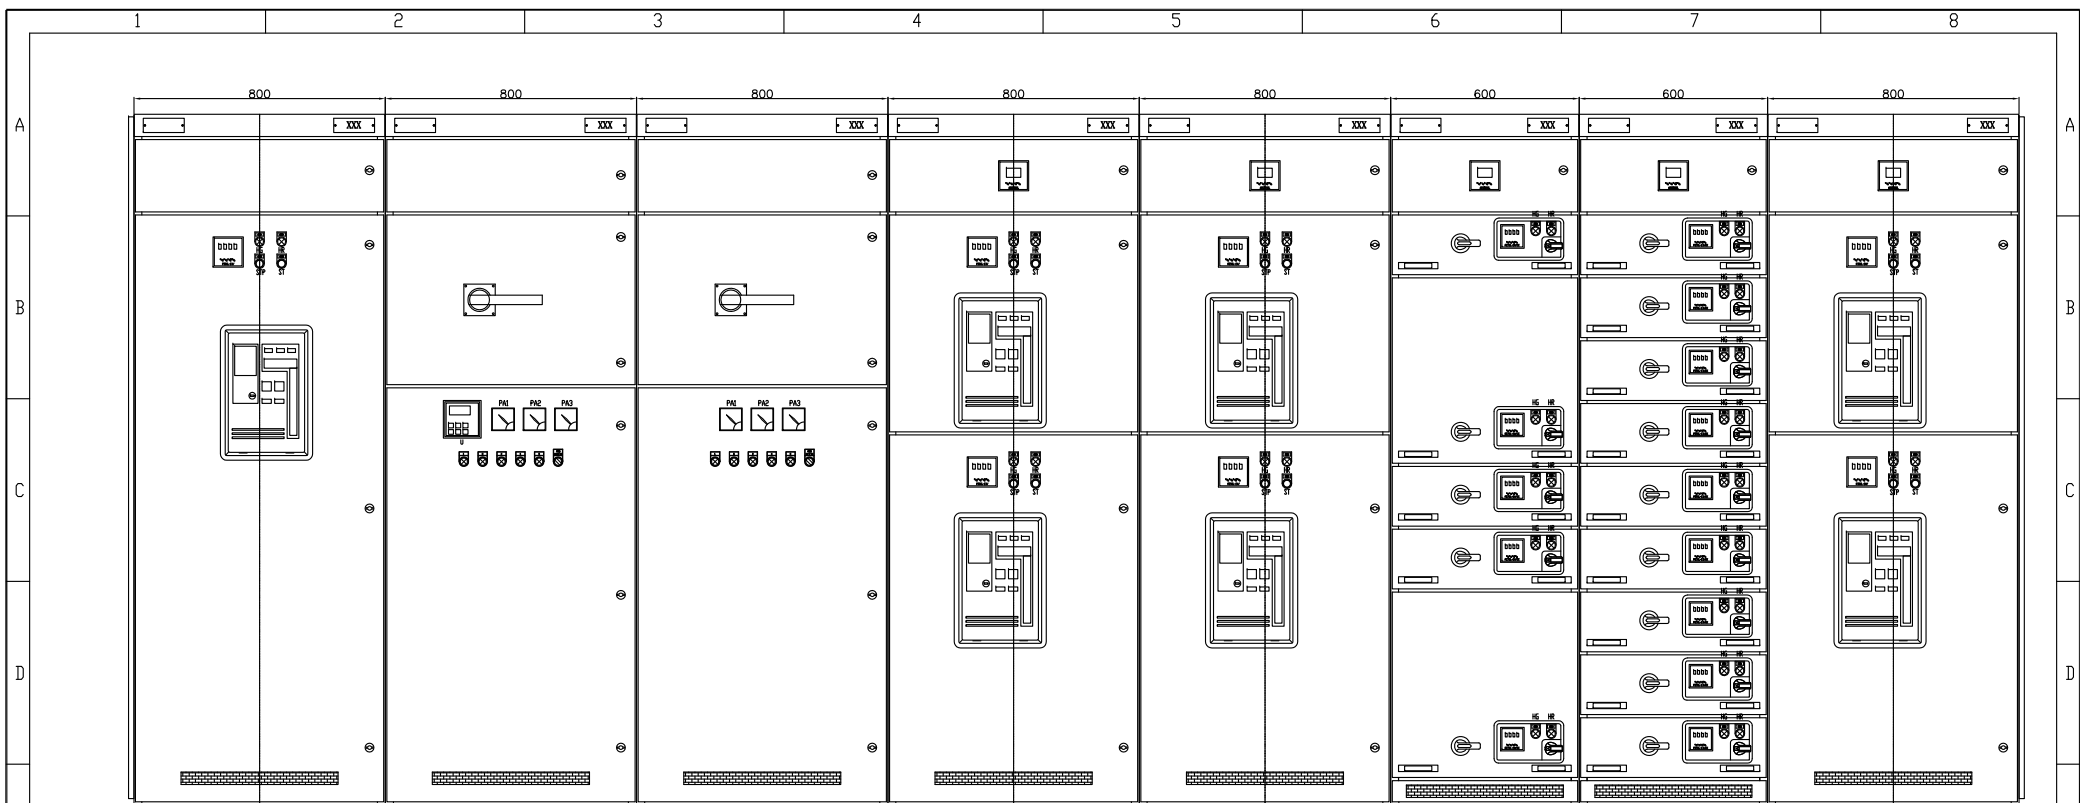

PNL.NO. 柜号 A01 A02 A03 A04 A05 A06 A07 A08

FRONT VIEW  
正视图

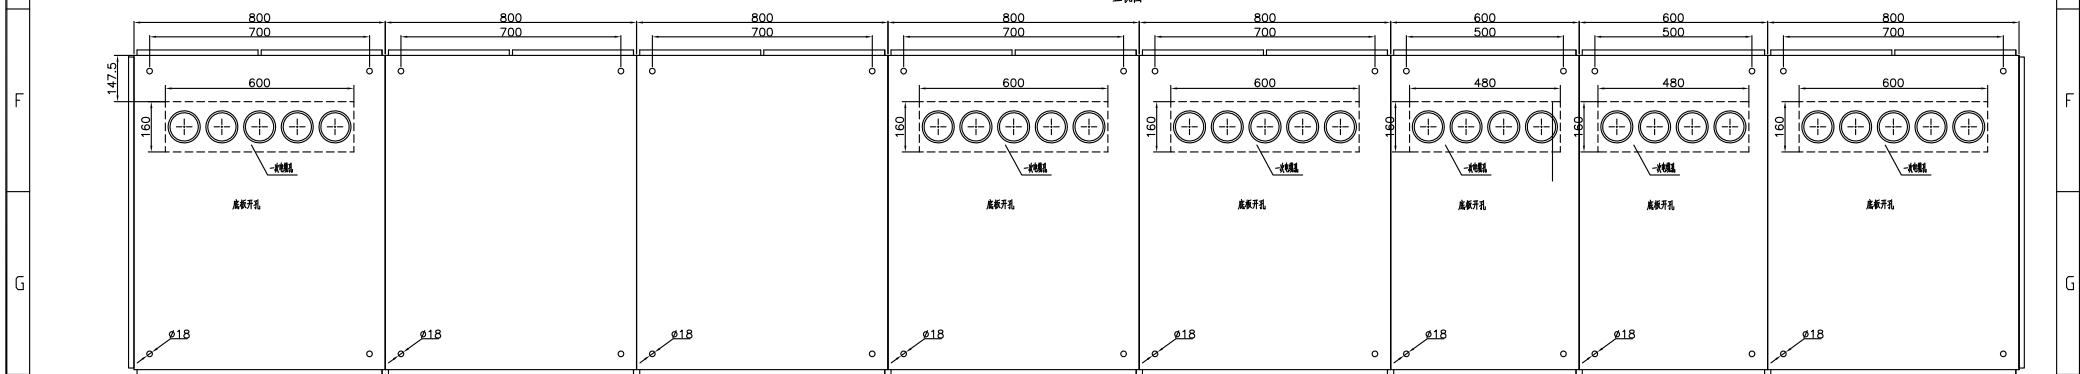

FOUNDATION DETAIL  
基础图



FIRST ANGLE  
PROJECTION

|       |  |             |  |          |  |        |  |                |  |         |  |                                                |  |             |  |          |  |
|-------|--|-------------|--|----------|--|--------|--|----------------|--|---------|--|------------------------------------------------|--|-------------|--|----------|--|
| DRAWN |  | CHECKED     |  | APPROVED |  | DATE   |  | PROJECT NAME : |  | TITLE : |  | SCALE                                          |  | DRAWING NO. |  | SHEET 1  |  |
| REV.  |  | DESCRIPTION |  | BY       |  | APP 'D |  | DATE           |  | 2016.6  |  | SHANGHAI INFRASWIN ENERGY TECHNOLOGY CO., LTD. |  | JS151107    |  | 2 SHEETS |  |
| 1     |  | 2           |  | 3        |  | 4      |  | 5              |  | 6       |  | 7                                              |  | 8           |  |          |  |