


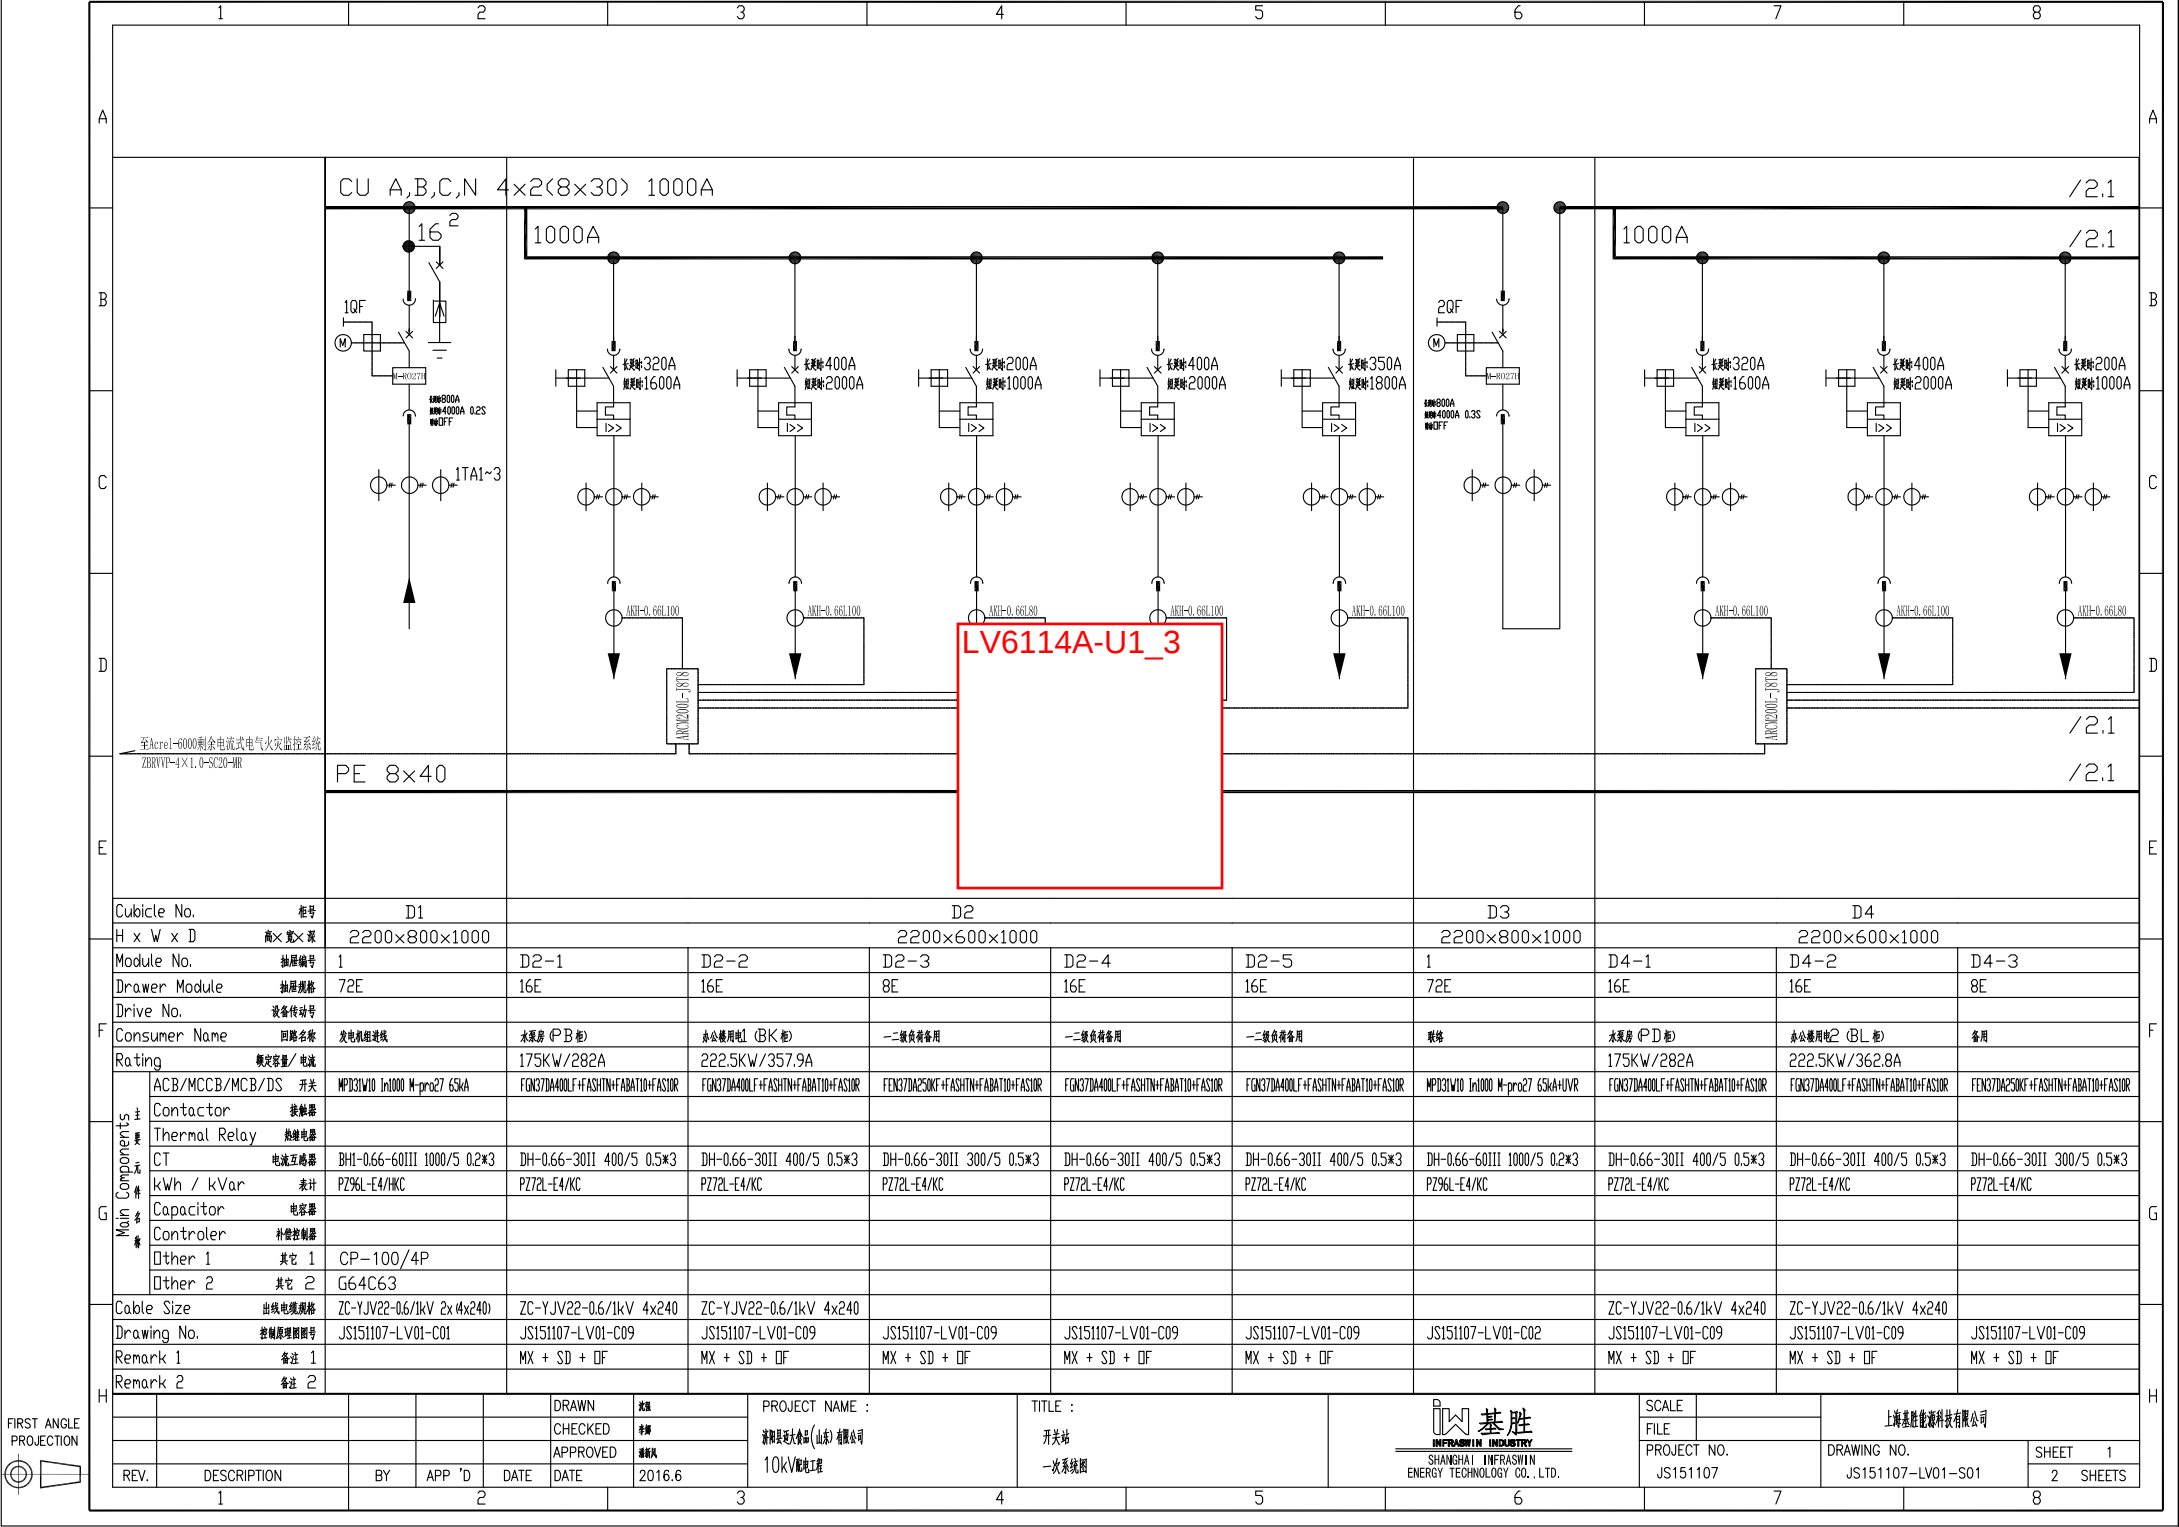

Cubicle No.		柜号	D1		D2					D3		D4		
H x W x D		高×宽×深	2200×800×1000		2200×600×1000					2200×800×1000		2200×600×1000		
Module No.		抽屉编号	1	D2-1	D2-2	D2-3	D2-4	D2-5	1	D4-1	D4-2	D4-3		
Drawer Module		抽屉规格	72E	16E	16E	8E	16E	16E	72E	16E	16E	8E		
Drive No.		设备传动号												
Consumer Name		回路名称	发电机进线	水泵房 (PB柜)	办公楼用电1 (BK柜)	一二级负荷备用	一二级负荷备用	一二级负荷备用	联络	水泵房 (PD柜)	办公楼用电2 (BL柜)	备用		
Rating		额定容量/ 电流		175KW/282A	222.5KW/357.9A					175KW/282A	222.5KW/362.8A			
Main Components 主元件多备	ACB/MCCB/MCB/DS	开关	MPD31W10 1x1000 M-pro27 65kA	F0K37DA400LF+ASHTN+ABATID+ASJ0R	F0K37DA400LF+ASHTN+ABATID+ASJ0R	F0K37DA250KF+ASHTN+ABATID+ASJ0R	F0K37DA400LF+ASHTN+ABATID+ASJ0R	F0K37DA400LF+ASHTN+ABATID+ASJ0R	MPD31W10 1x1000 M-pro27 65kA+UVR	F0K37DA400LF+ASHTN+ABATID+ASJ0R	F0K37DA400LF+ASHTN+ABATID+ASJ0R	F0K37DA250KF+ASHTN+ABATID+ASJ0R		
	Contactors	接触器												
	Thermal Relay	热继电器												
	CT	电流互感器	BH1-0.66-60III 1000/5 0.2*3	DH-0.66-30II 400/5 0.5*3	DH-0.66-30II 400/5 0.5*3	DH-0.66-30II 300/5 0.5*3	DH-0.66-30II 400/5 0.5*3	DH-0.66-30II 400/5 0.5*3	DH-0.66-60III 1000/5 0.2*3	DH-0.66-30II 400/5 0.5*3	DH-0.66-30II 400/5 0.5*3	DH-0.66-30II 300/5 0.5*3		
	kWh / kVar	表计	PZ96L-E4/KC	PZ72L-E4/KC	PZ72L-E4/KC	PZ72L-E4/KC	PZ72L-E4/KC	PZ72L-E4/KC	PZ96L-E4/KC	PZ72L-E4/KC	PZ72L-E4/KC	PZ72L-E4/KC		
	Capacitor	电容器												
	Controler	补偿控制器												
	Other 1	其它 1	CP-100/4P											
	Other 2	其它 2	G64C63											
Cable Size		出线电缆规格	ZC-YJV22-0.6/1kV 2x (4x240)	ZC-YJV22-0.6/1kV 4x240						ZC-YJV22-0.6/1kV 4x240	ZC-YJV22-0.6/1kV 4x240			
Drawing No.		控制原理图号	JS151107-LV01-C01	JS151107-LV01-C09	JS151107-LV01-C09	JS151107-LV01-C09	JS151107-LV01-C09	JS151107-LV01-C09	JS151107-LV01-C02	JS151107-LV01-C09	JS151107-LV01-C09	JS151107-LV01-C09		
Remark 1		备注 1		MX + SD + OF	MX + SD + OF	MX + SD + OF	MX + SD + OF	MX + SD + OF		MX + SD + OF	MX + SD + OF	MX + SD + OF		
Remark 2		备注 2												

REV.		DESCRIPTION		BY	APP 'D	DATE	DRAWN		审核	PROJECT NAME :		TITLE :		SCALE		FILE		PROJECT NO.		DRAWING NO.		SHEET	
1							2016.6		2016.6	10KV配电工程		一次系统图		1:1				JS151107		JS151107-LV01-S01		2	





上海基胜能源科技有限公司


DRAWING NO. JS151107-LV01-S01


SHEET 1


2 SHEETS

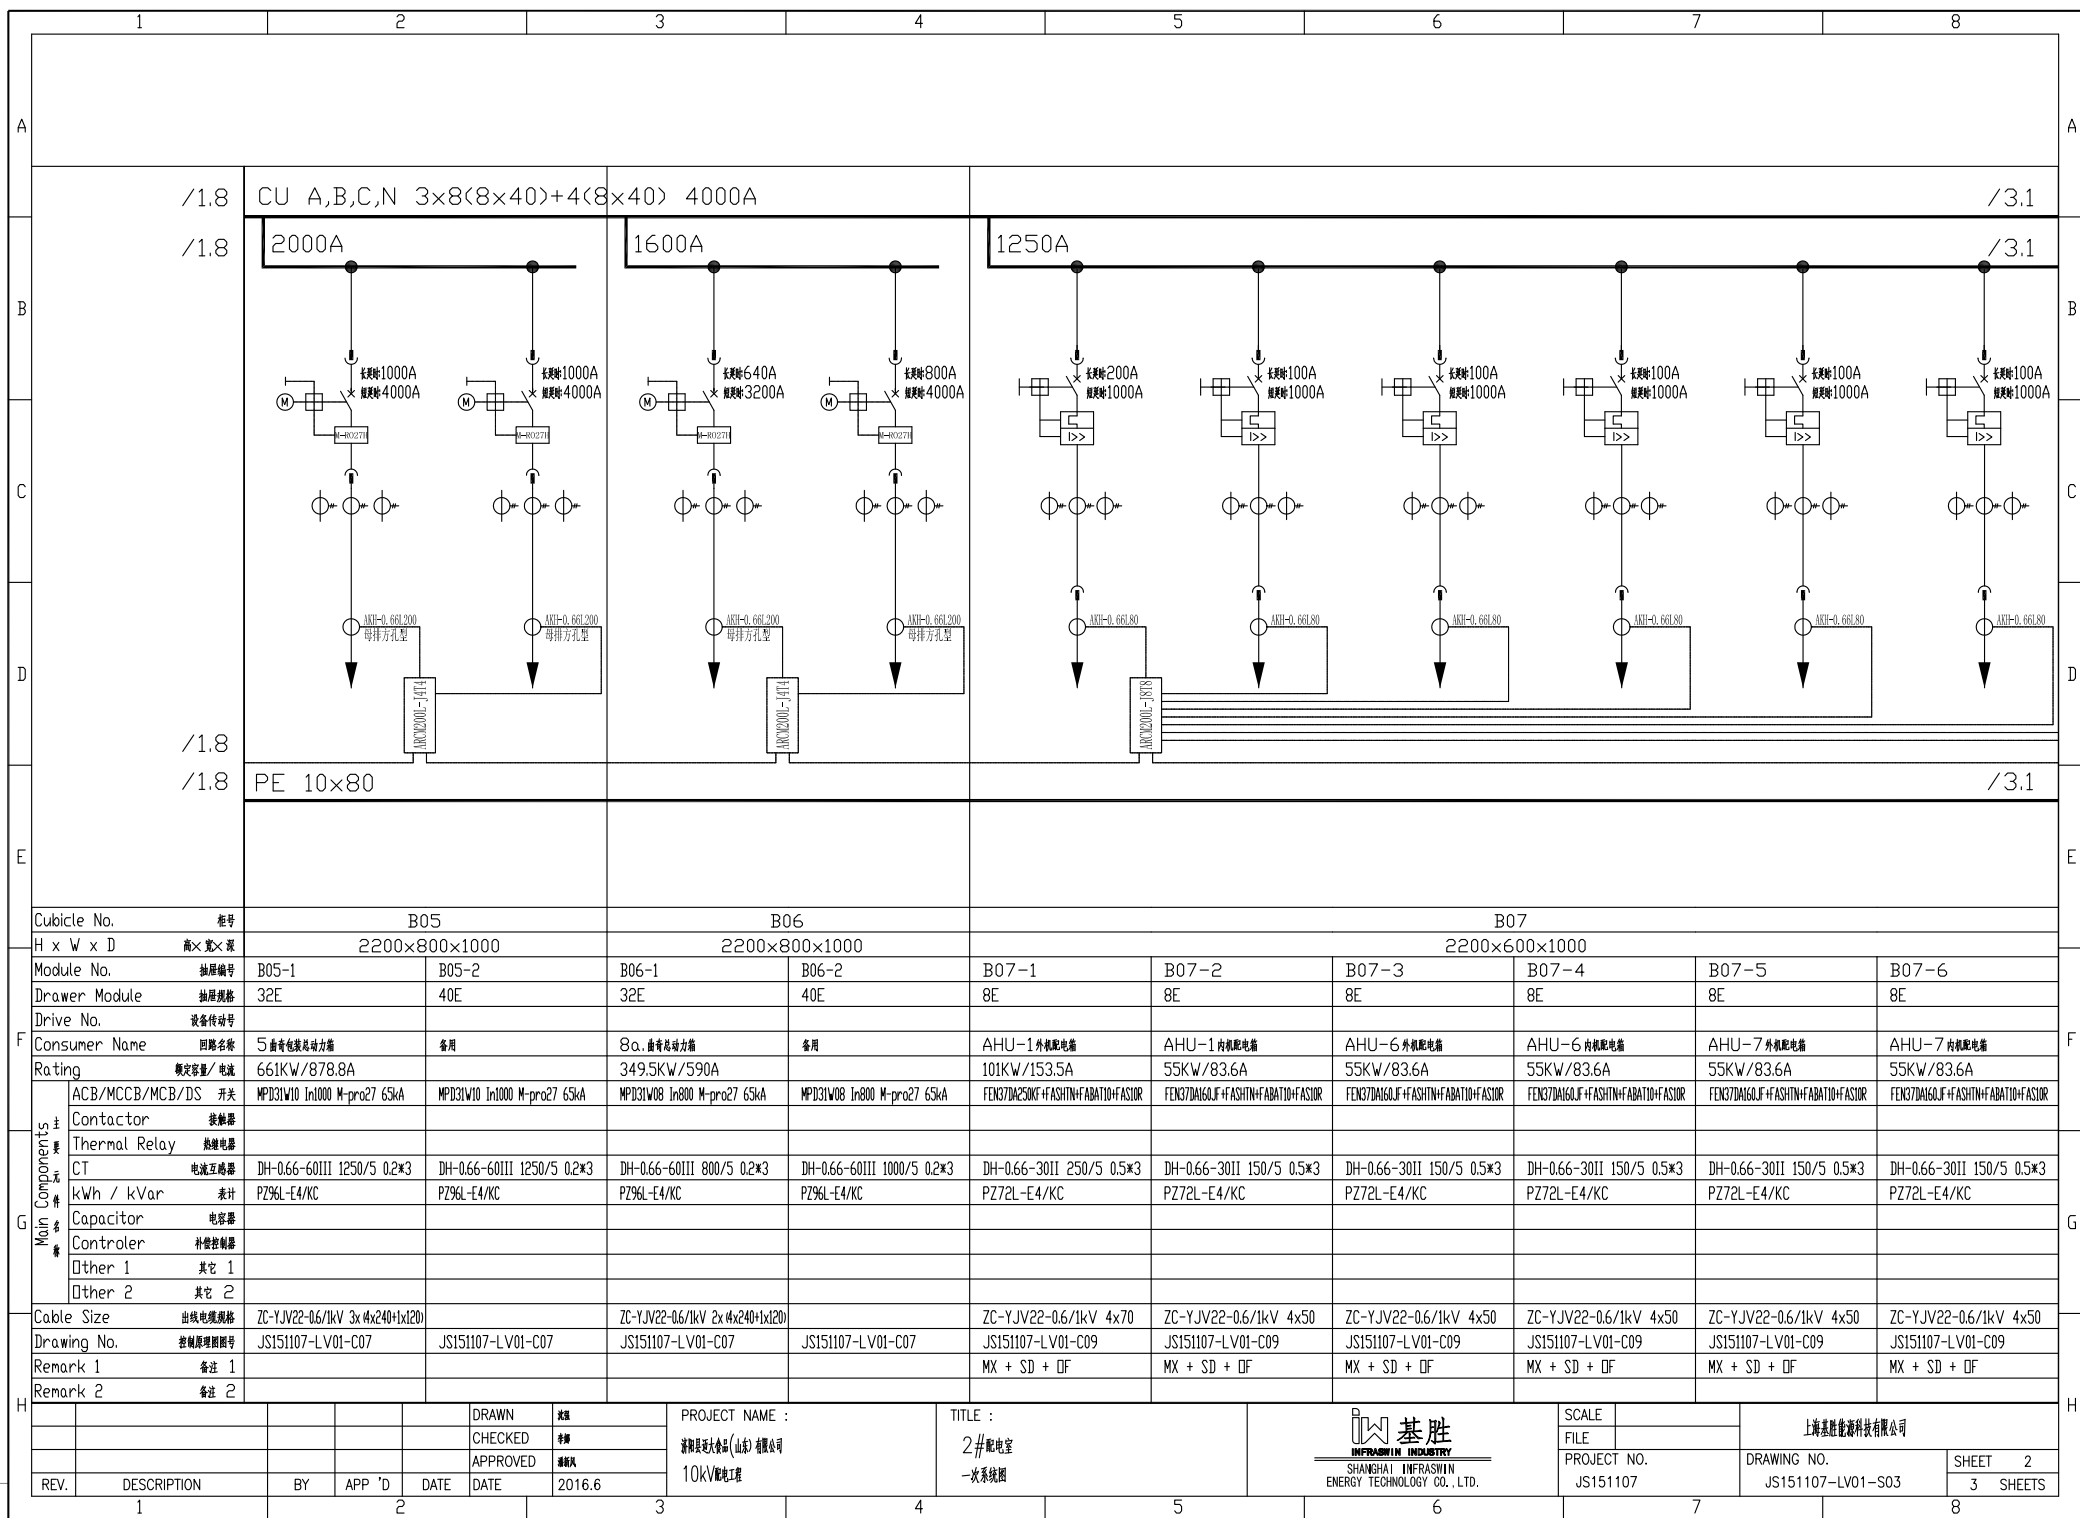


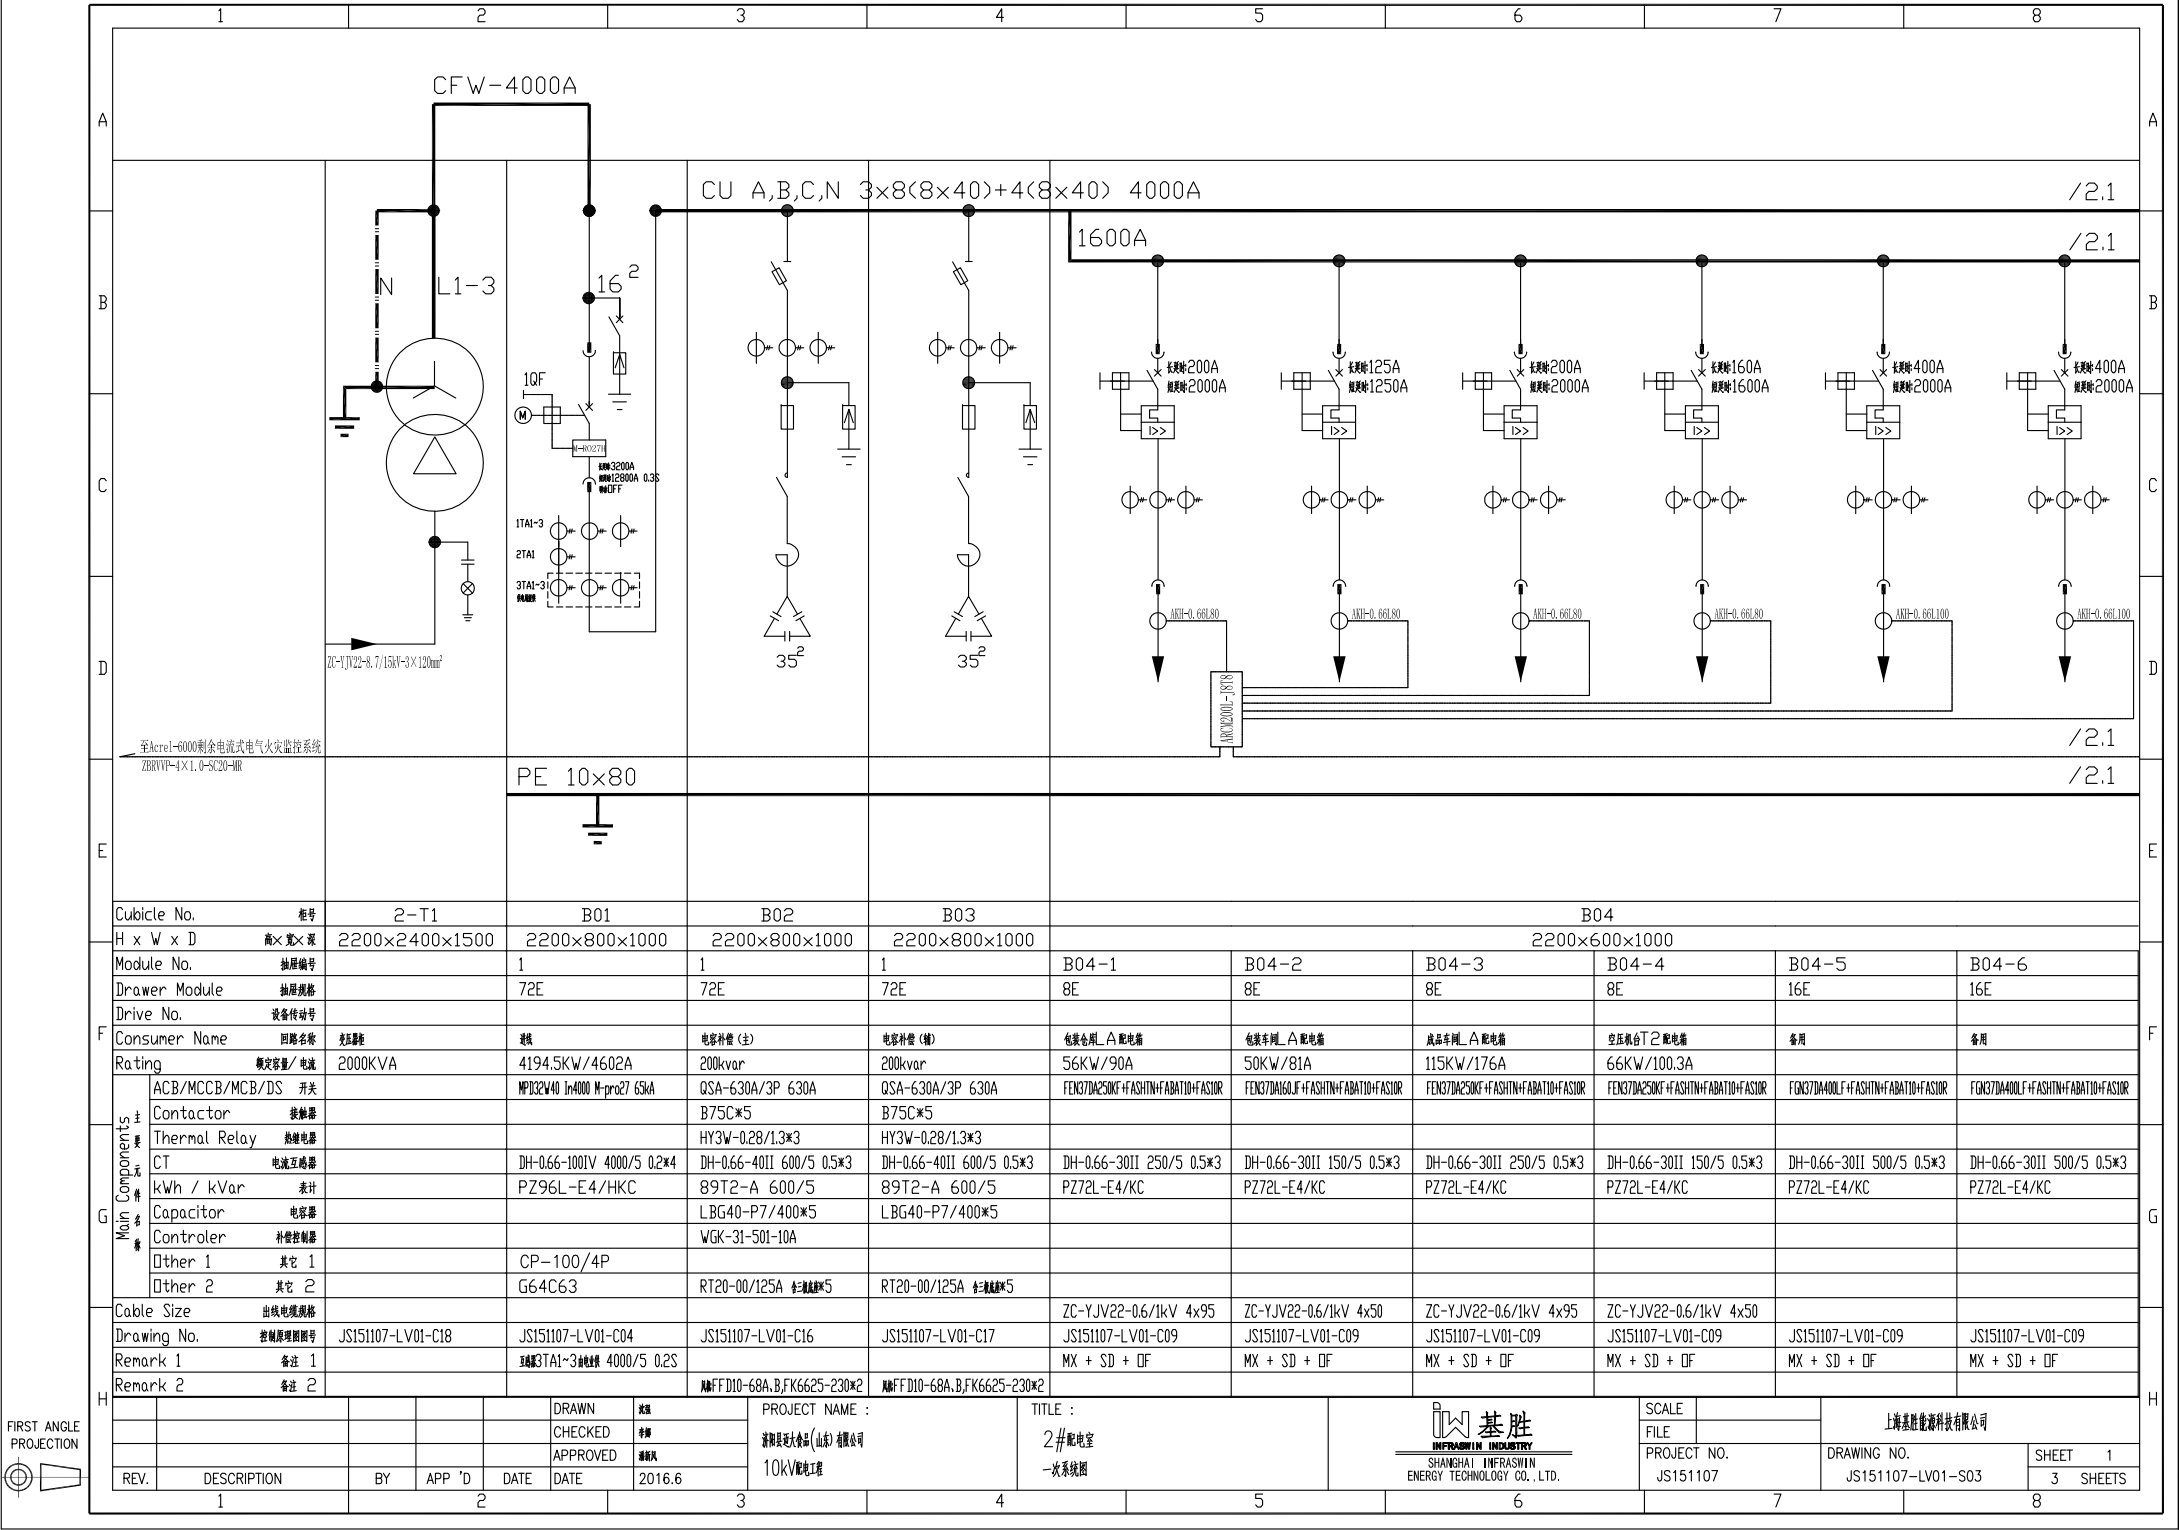

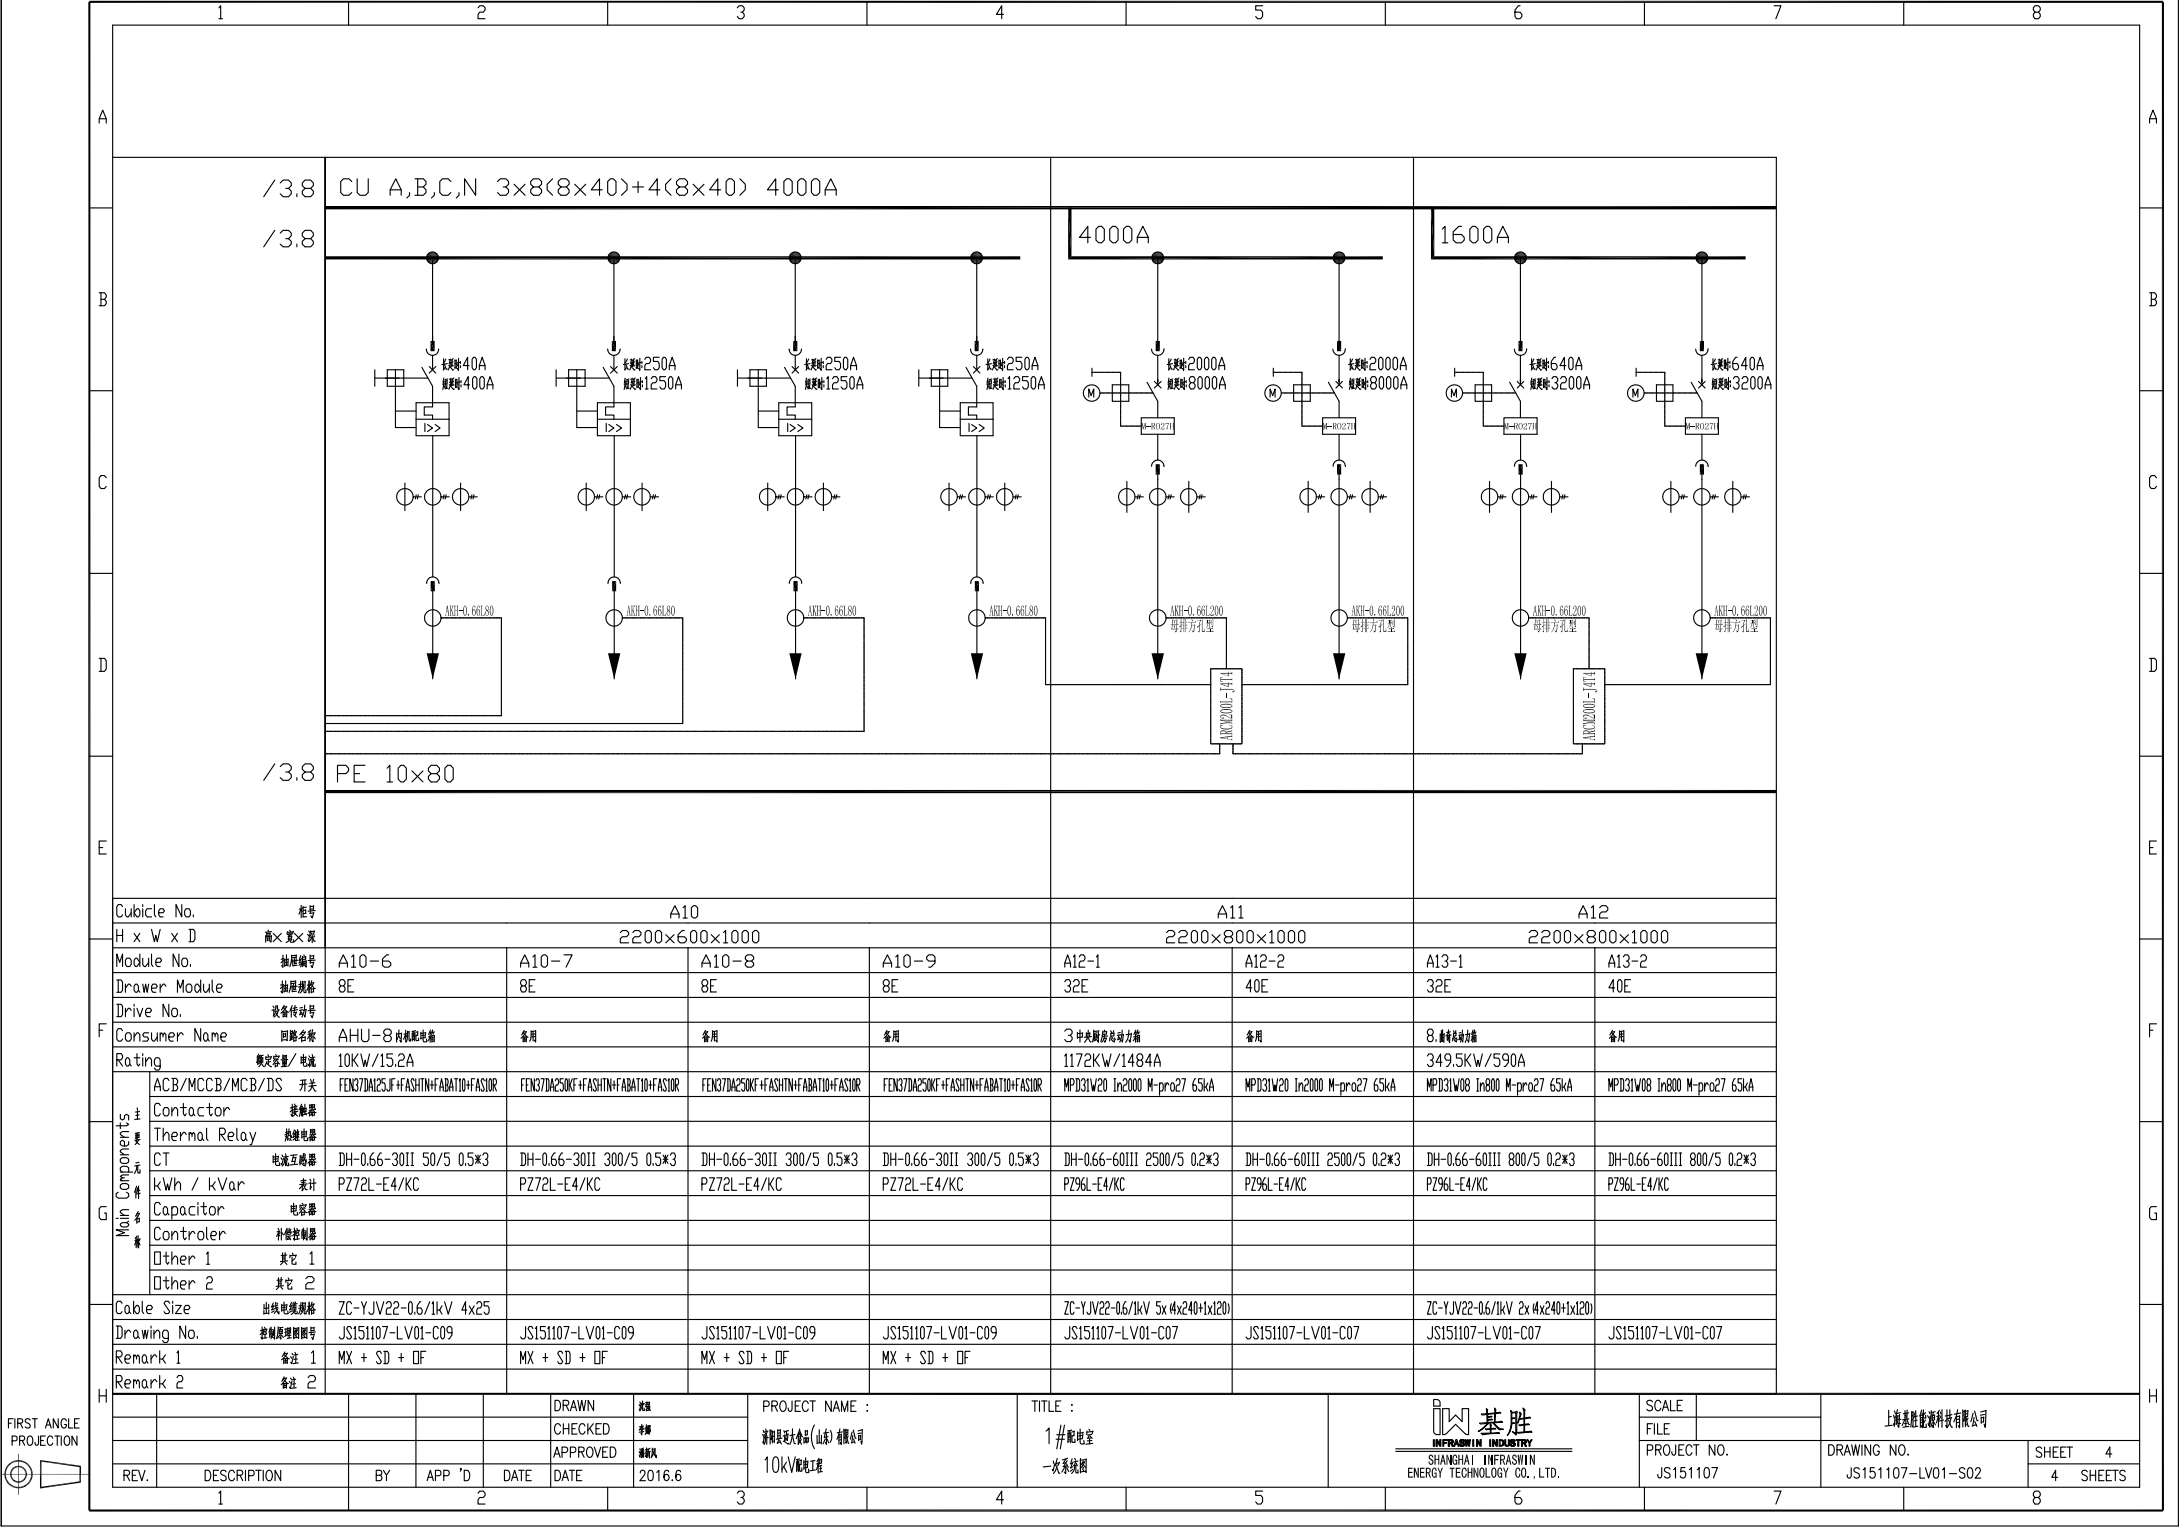

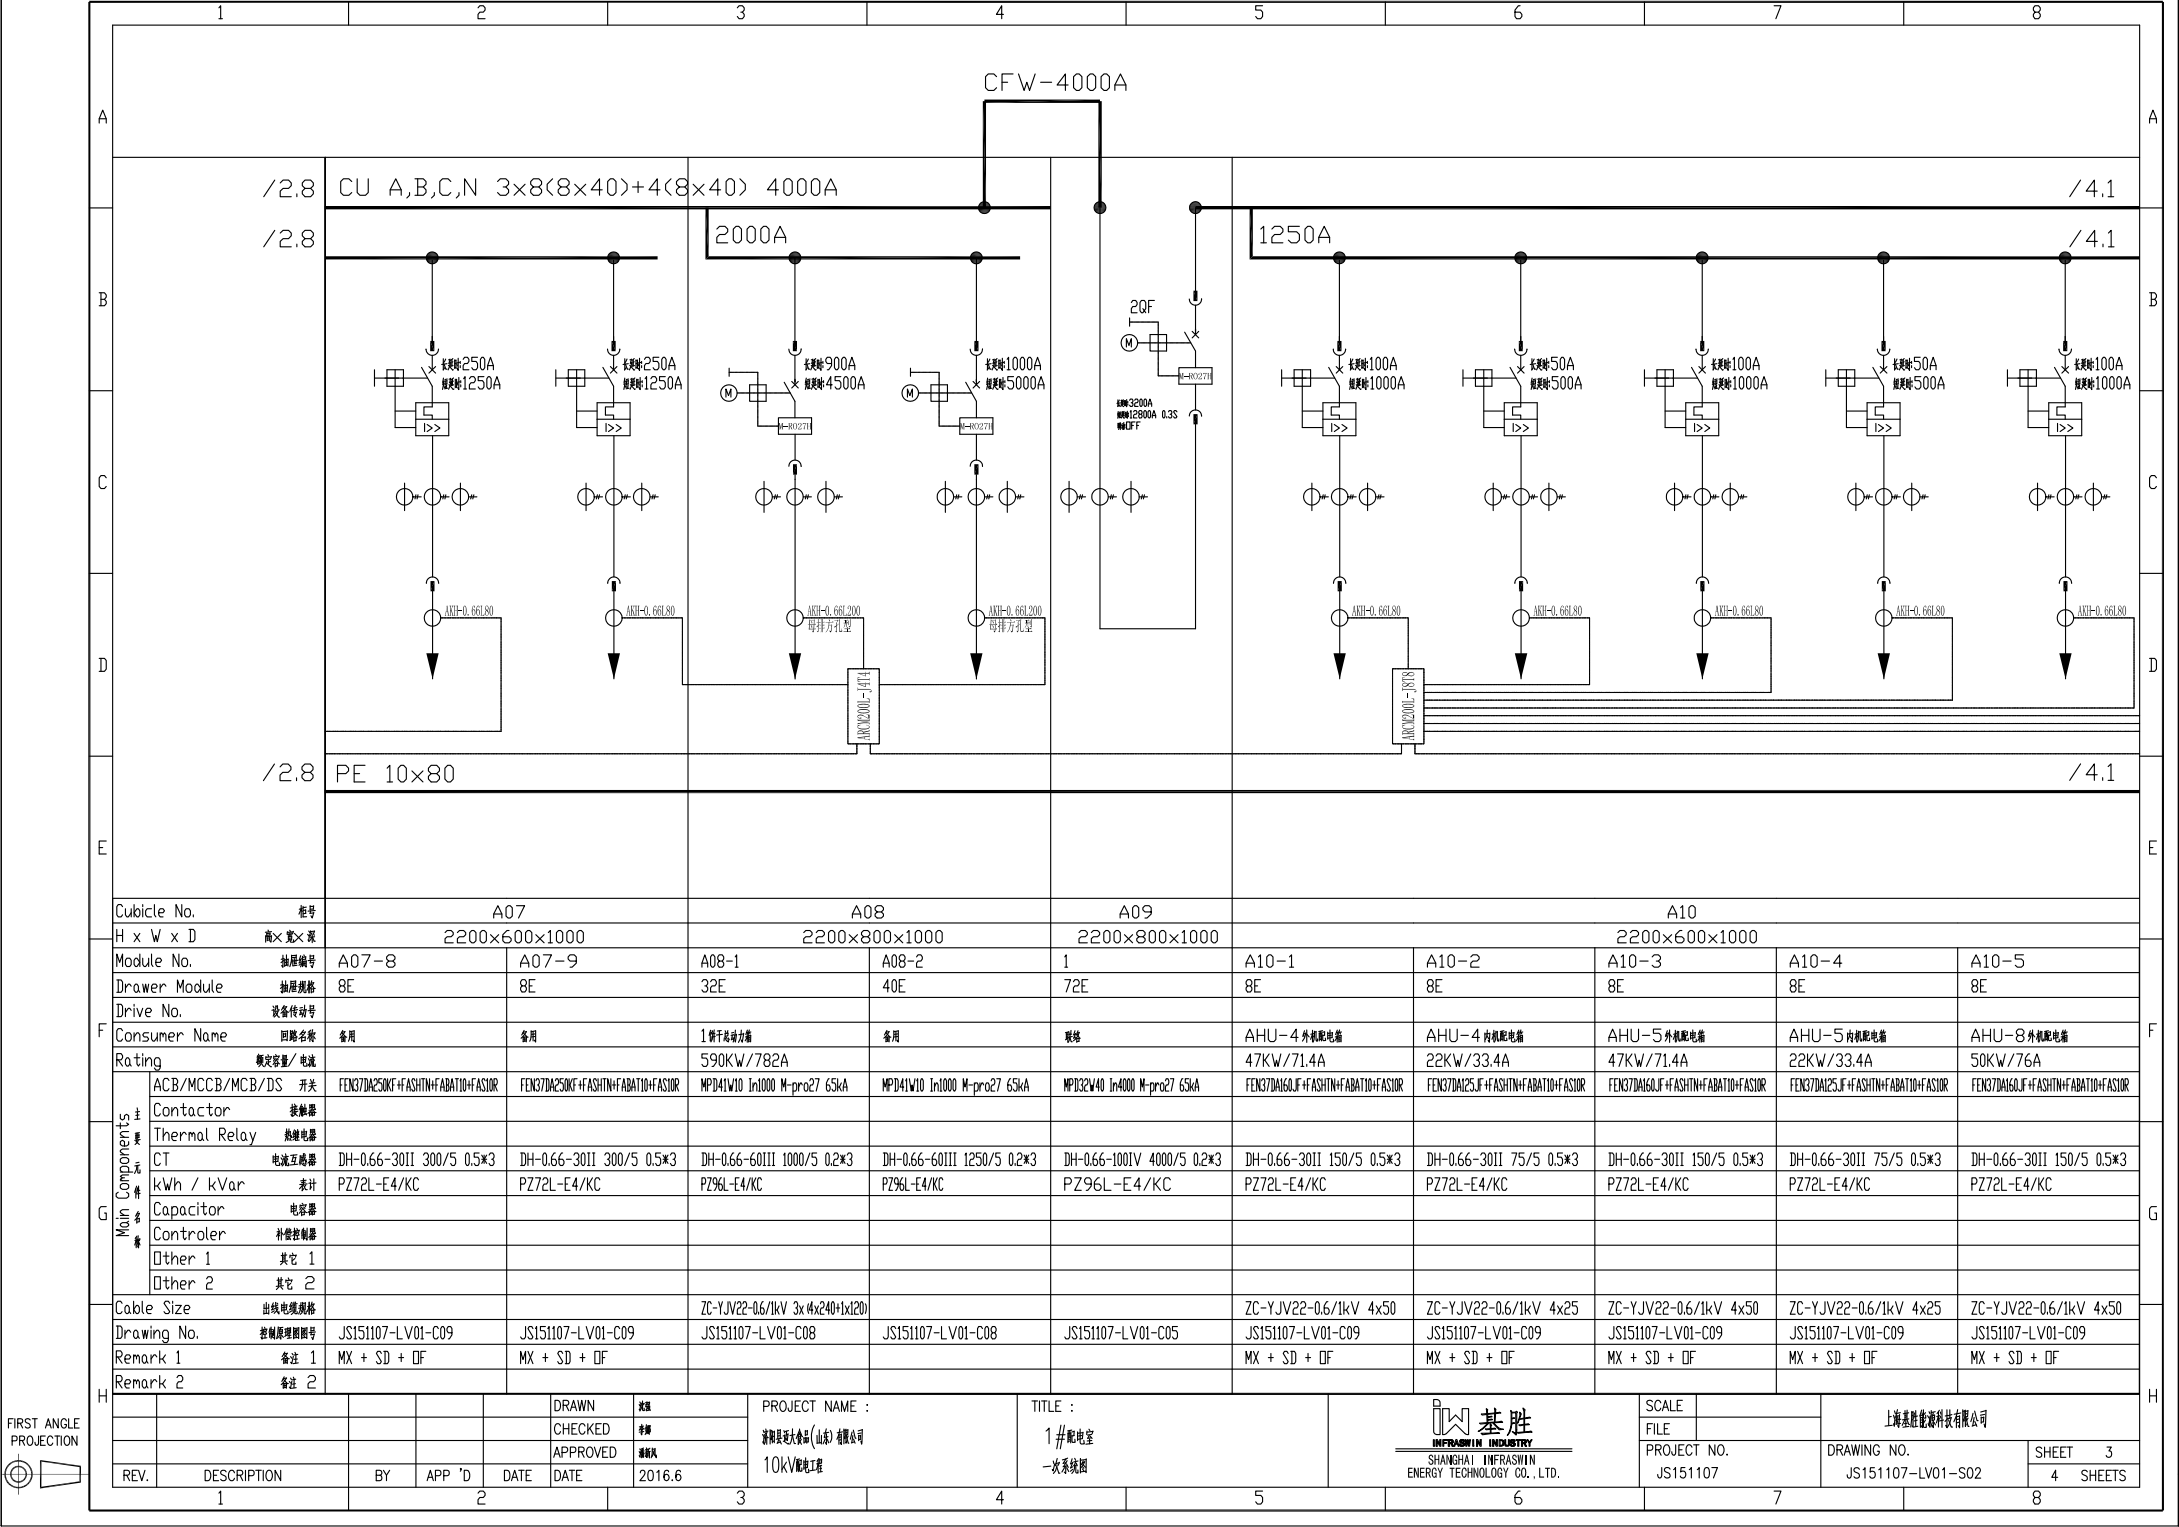

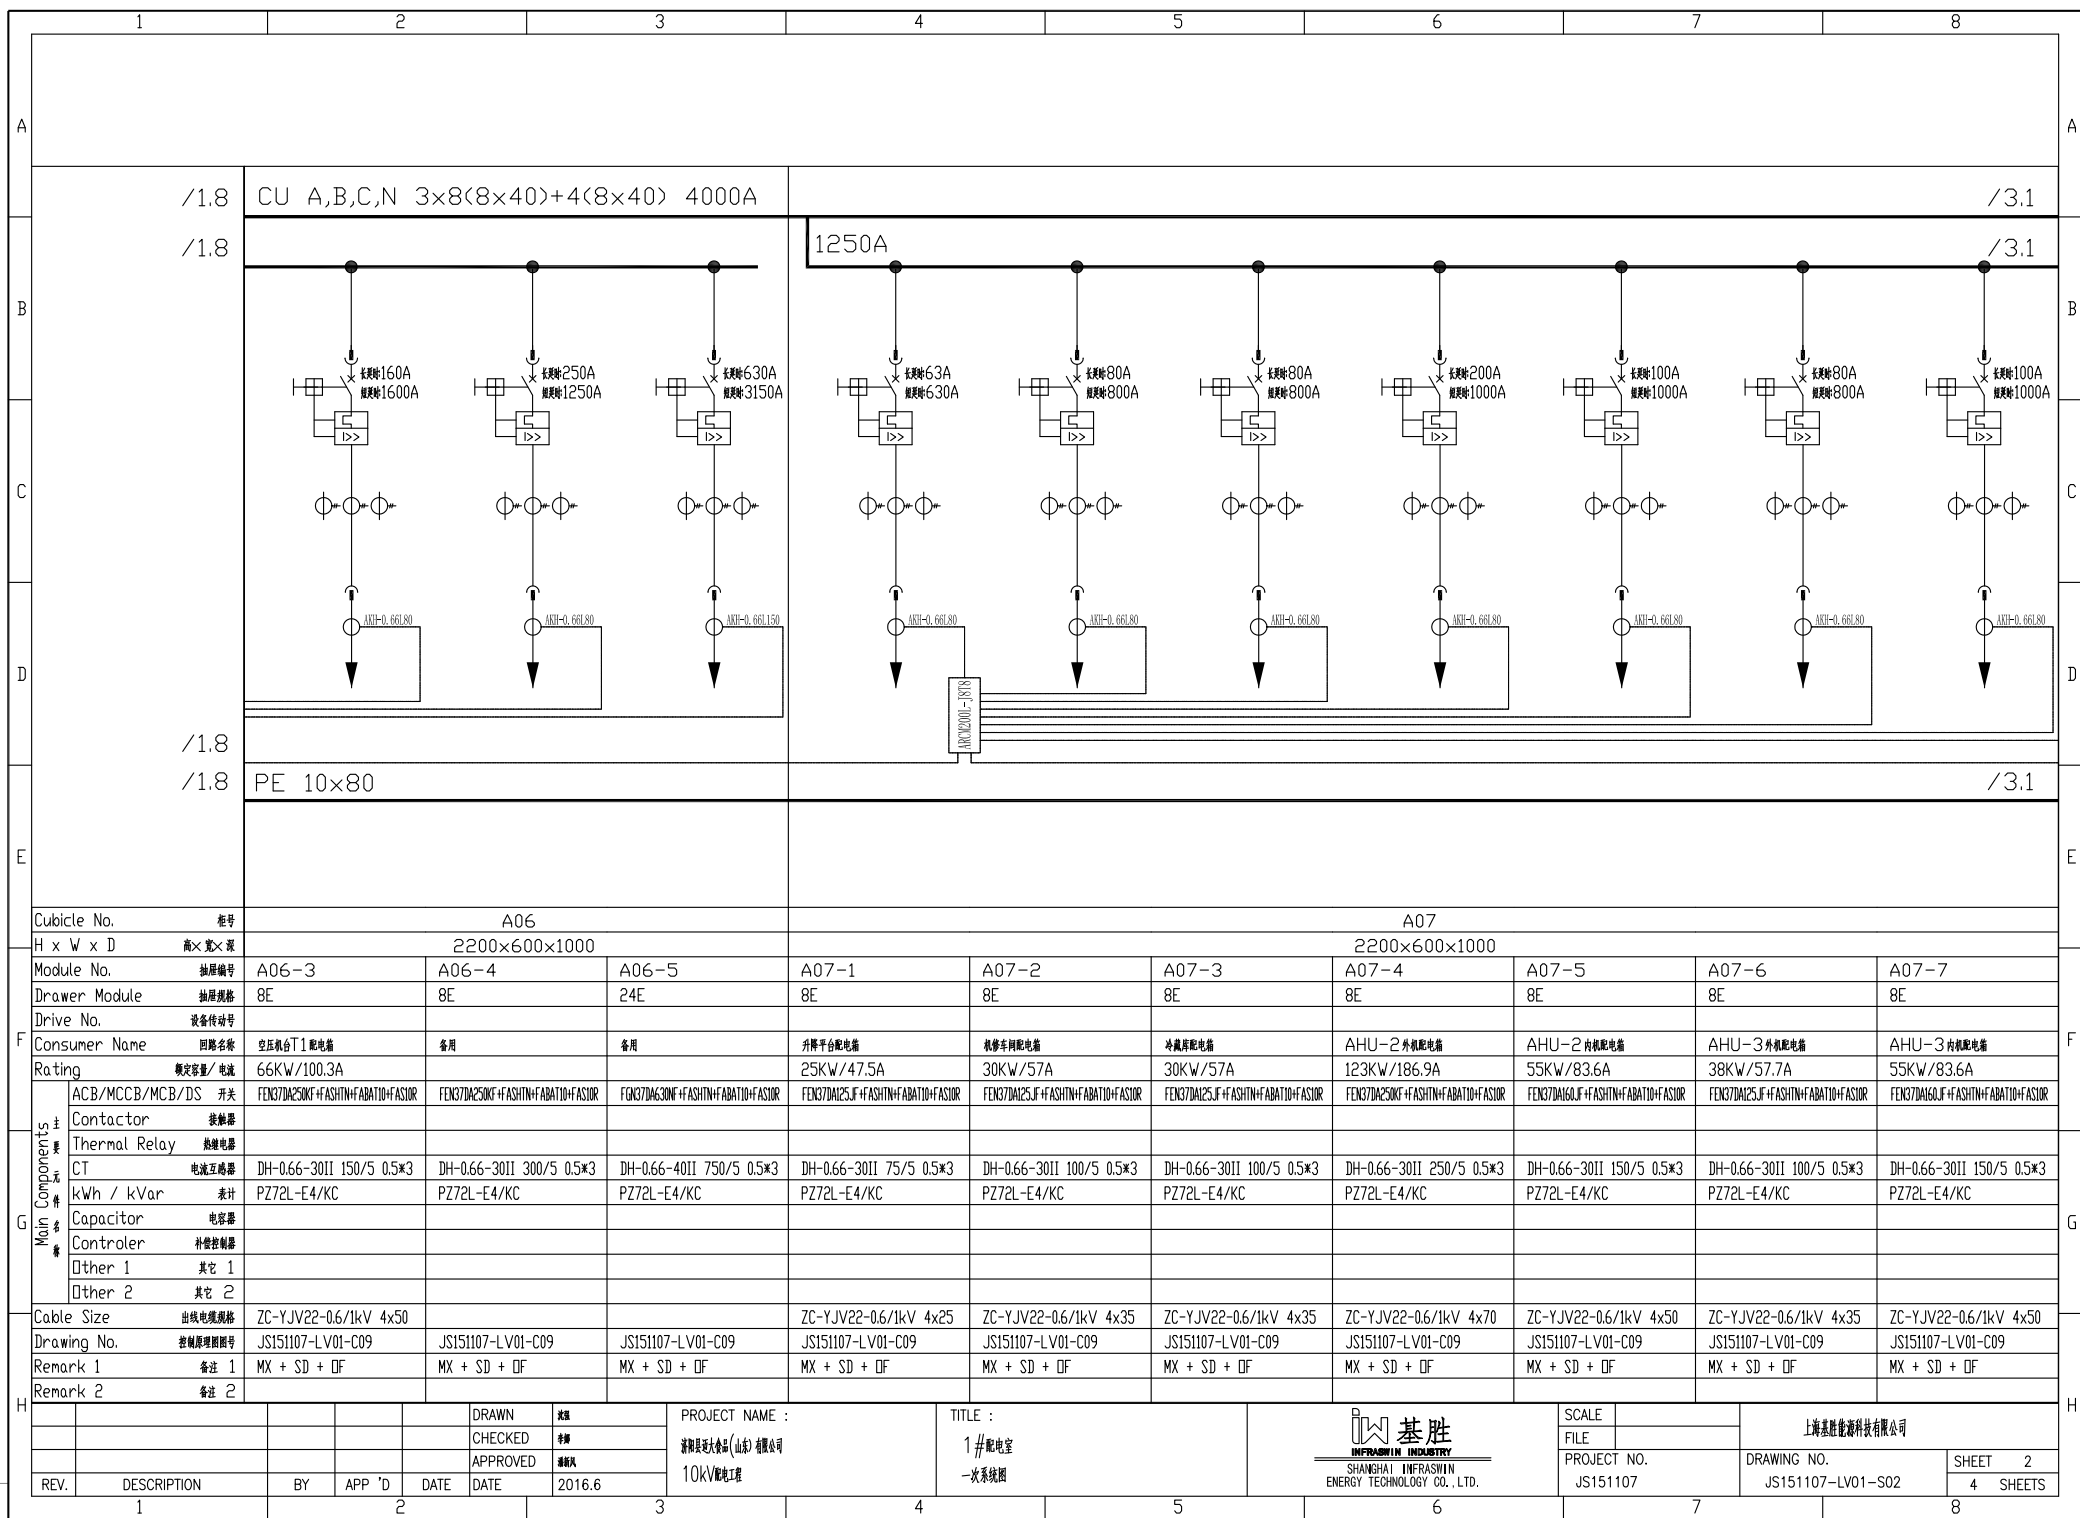

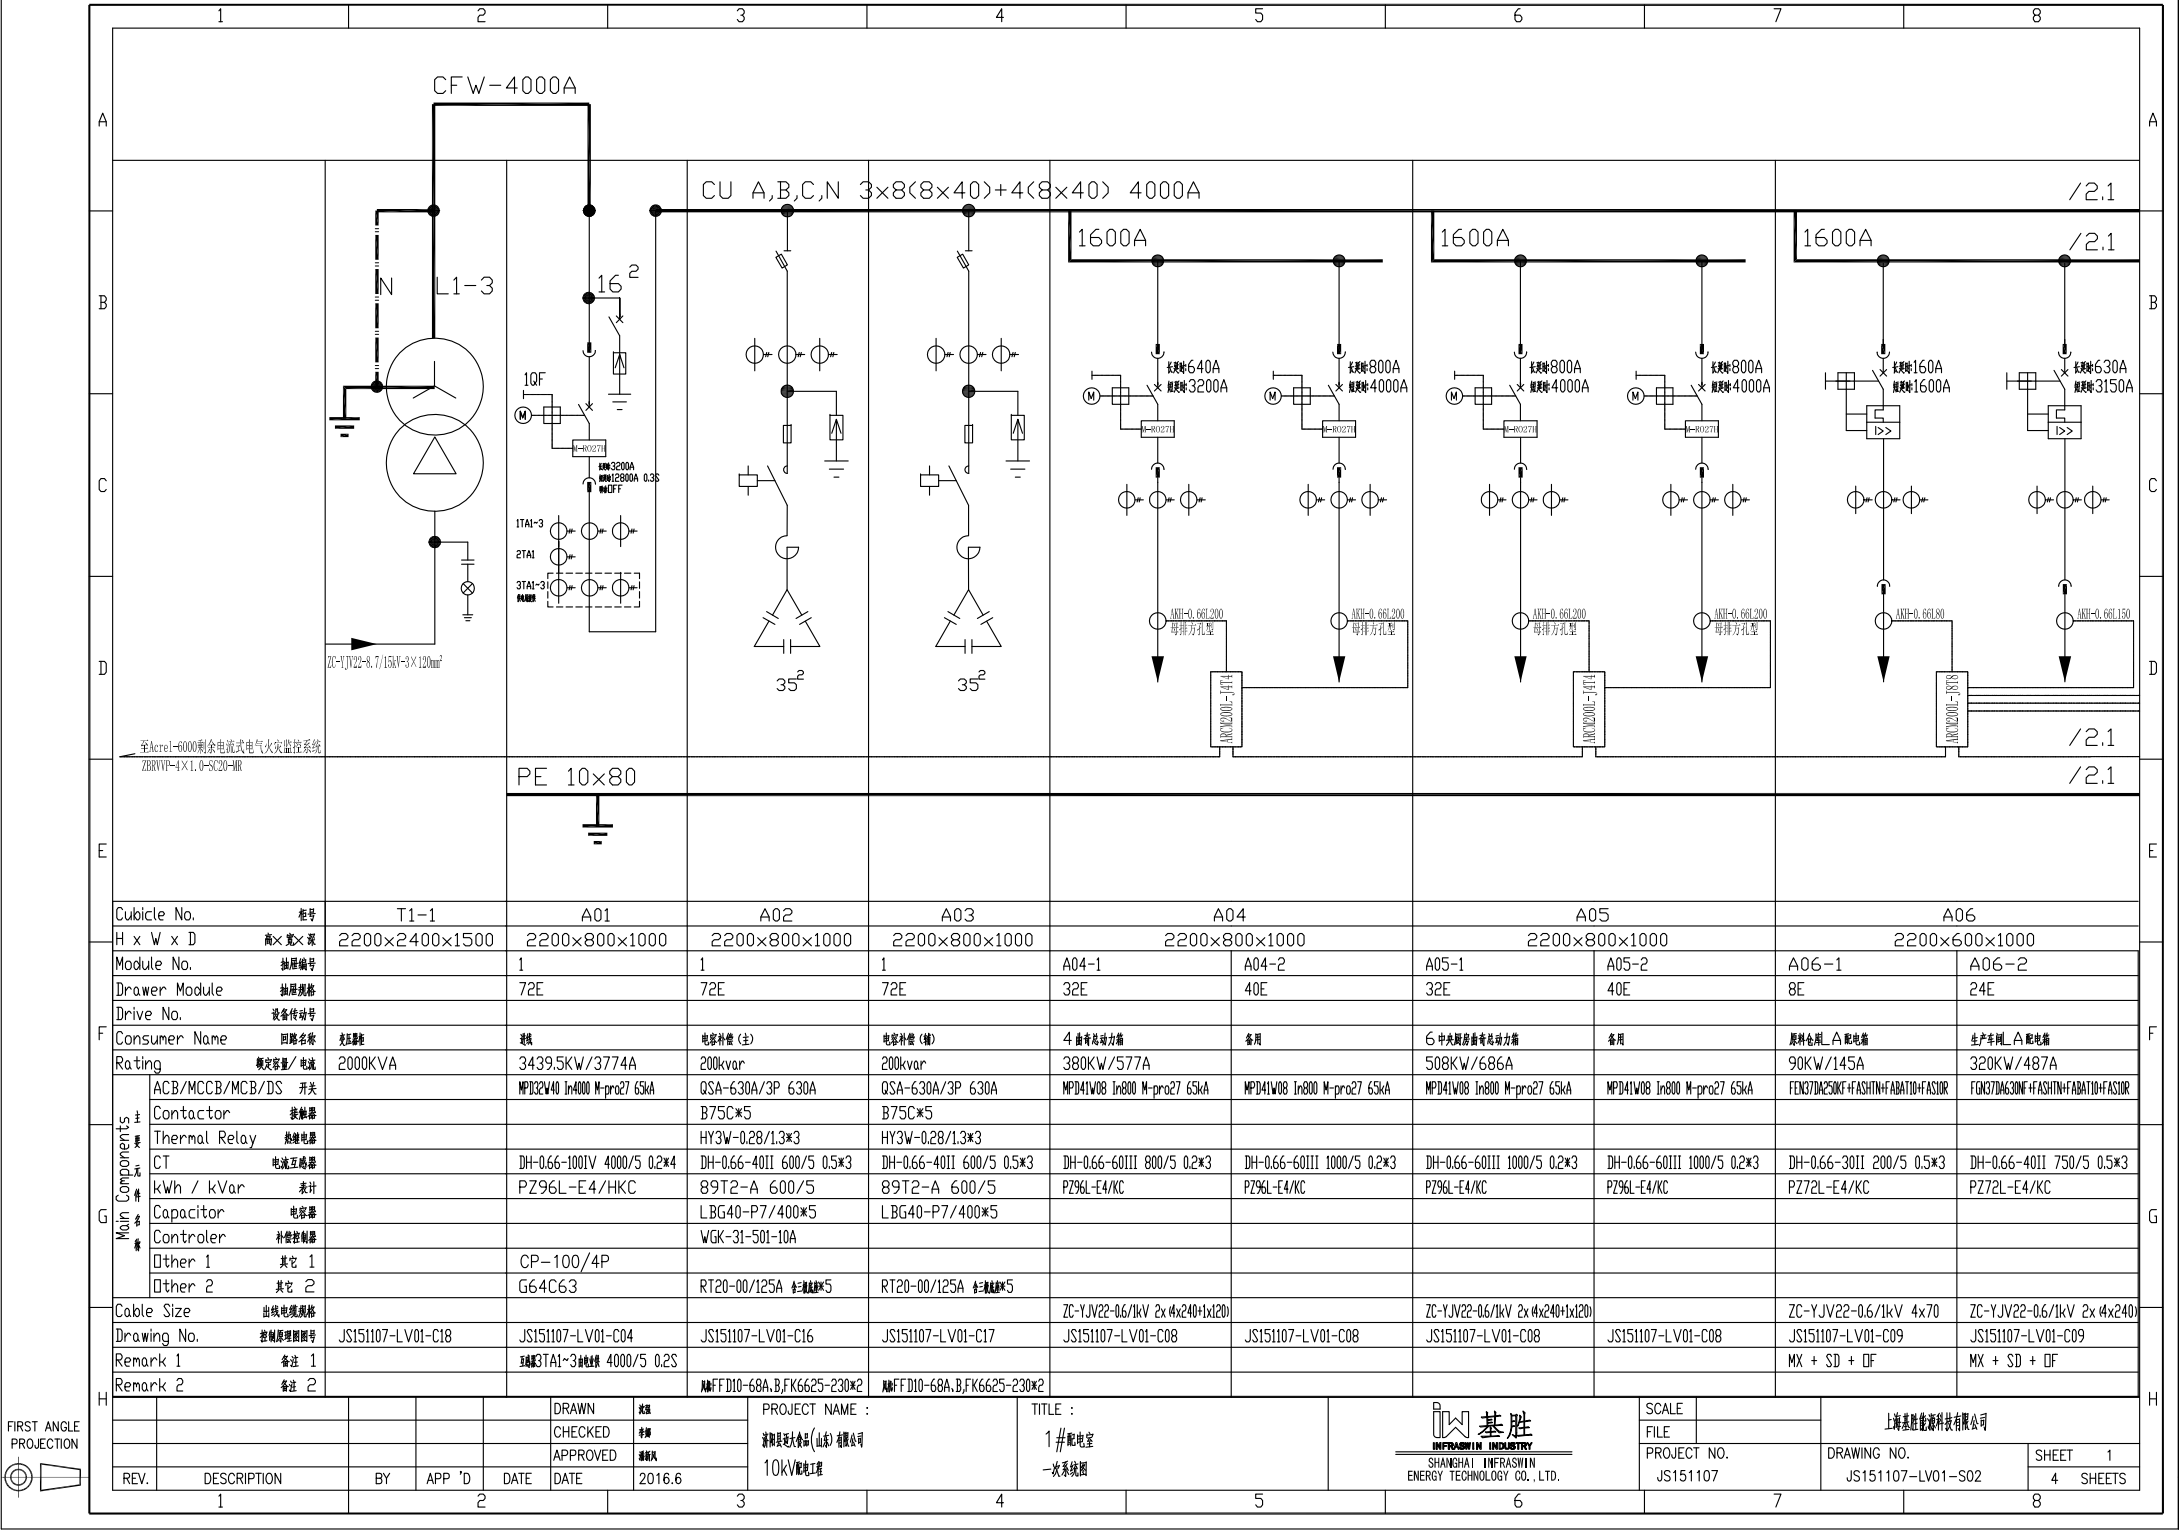

至Mcrel-6000剩余电流式电气火灾监控系统
ZB88VVP-4X1.0-50(20)-HR

Cubicle No.		柜号	T1-1	A01	A02	A03	A04		A05		A06	
H x W x D		高×宽×深	2200×2400×1500	2200×800×1000	2200×800×1000	2200×800×1000	2200×800×1000		2200×800×1000		2200×600×1000	
Module No.		抽屉编号	1	1	1		A04-1	A04-2	A05-1	A05-2	A06-1	A06-2
Drawer Module		抽屉规格	72E	72E	72E		32E	40E	32E	40E	8E	24E
Drive No.		设备传动号										
Consumer Name		回路名称	高压柜	进线	电容补偿 (主)	电容补偿 (辅)	4 座中压站动力箱		6 中央厨房前中压站动力箱		原料仓储_△配电箱	
Rating		额定容量/ 电流	2000KVA	3439.5KW/3774A	200kvar	200kvar	380KW/577A		508KW/686A		90KW/145A	
Main Components	ACB/MCCB/MCB/DS 开关			MPD32W40 In4000 M-pro27 65kA	QSA-630A/3P 630A	QSA-630A/3P 630A	MPD41W08 In800 M-pro27 65kA		MPD41W08 In800 M-pro27 65kA		FEN37DA250K+FASHTN+FABAT10+FASIOR	
	Contactor 接触器				B75C*5	B75C*5					FEN37DA250K+FASHTN+FABAT10+FASIOR	
	Thermal Relay 热继电器				HY3W-0.28/1.3*3	HY3W-0.28/1.3*3						
	CT 电流互感器			DH-0.66-100IV 4000/5 0.2*4	DH-0.66-40II 600/5 0.5*3	DH-0.66-40II 600/5 0.5*3	DH-0.66-60III 800/5 0.2*3		DH-0.66-60III 1000/5 0.2*3		DH-0.66-30II 200/5 0.5*3	
	kWh / kVar 表计			PZ96L-E4/HKC	89T2-A 600/5	89T2-A 600/5	PZ96L-E4/KC		PZ96L-E4/KC		PZ72L-E4/KC	
	Capacitor 电容器				LBG40-P7/400*5	LBG40-P7/400*5						
	Controler 补偿控制器				WGK-31-50I-10A							
	Other 1 其它 1			CP-100/4P								
	Other 2 其它 2			G64C63	RT20-00/125A 全塑断路器*5	RT20-00/125A 全塑断路器*5						
Cable Size		出线电缆规格					ZC-YJV22-0.6/1kV 2x4x240+1x120		ZC-YJV22-0.6/1kV 2x4x240+1x120		ZC-YJV22-0.6/1kV 4x70	
Drawing No.		控制原理图编号	JS151107-LV01-C18	JS151107-LV01-C04	JS151107-LV01-C16	JS151107-LV01-C17	JS151107-LV01-C08		JS151107-LV01-C08		JS151107-LV01-C09	
Remark 1		备注 1		至Mcrel-6000剩余电流式电气火灾监控系统								
Remark 2		备注 2			至Mcrel-6000剩余电流式电气火灾监控系统						MX + SD + DF	

FIRST ANGLE PROJECTION

REV.

DESCRIPTION

BY

APP 'D

DATE

DRAWN

CHECKED

APPROVED

DATE

2016.6

PROJECT NAME :

1# 配电室

一次系统图

TITLE :

1# 配电室

一次系统图

基胜

SHANGHAI INFRAWIN ENERGY TECHNOLOGY CO., LTD.

SCALE

FILE

PROJECT NO.

JS151107

上海基胜能源科技有限公司

DRAWING NO.

JS151107-LV01-S02

SHEET 1

4 SHEETS



FIRST ANGLE
PROJECTION

1		2		3		4		5		6		7		8	
A		B		C		D		E		F		G		H	
/1.8		/1.8		CU A,B,C,N 4×2(8×30) 100DA											
/1.8		/1.8		PE 8×40											
/1.8		/1.8													
Cubicle No.		柜号		D4		D5		D6		T					
H x W x D		高×宽×深		2200×600×1000		2200×800×1000		2200×800×1000		2200×1600×1200					
Module No.		抽屉编号		D4-4		D4-5		1		1					
Drawer Module		抽屉规格		16E		16E		72E		72E					
Drive No.		设备传动号													
Consumer Name		回路名称		备用		备用		电容补偿		电容补偿		电容补偿			
Rating		额定容量/电流				150kvar				500KVA					
Main Components	主要元件名称	ACB/MCCB/MCB/DS 开关		FGK37DM400LF+ASHTN+FBAT10+FASSOR		FGK37DM400LF+ASHTN+FBAT10+FASSOR		QSA-400A/3P 400A		MPD31W10 In1000 M-pro27 65kA					
		Contactor 接触器													
		Thermal Relay 热继电器				HY3W-0.28/1.3*3									
		CT 电流互感器		DH-0.66-301I 400/5 0.5*3		DH-0.66-301I 400/5 0.5*3		DH-0.66-301I 400/5 0.5*3		DH-0.66-601II 1000/5 0.2*6					
		kWh / kVar 表计		PZ72L-E4/KC		PZ72L-E4/KC		8972-A 400/5		PZ96L-E4/KC					
		Capacitor 电容器													
		Controler 补偿控制				WGG-31-201-F									
		Other 1 其它 1						CP-100/4P							
		Other 2 其它 2						G64C63							
Cable Size		出线电缆规格													
Drawing No.		控制原理图图号		JS151107-LV01-C09		JS151107-LV01-C09		JS151107-LV01-C15		JS151107-LV01-C03		JS151107-LV01-C18			
Remark 1		备注 1		MX + SD + OF		MX + SD + OF									
Remark 2		备注 2				MFDD10-68A,B,FK6625-230*2		3TA1-3 1000/5 0.5S							