




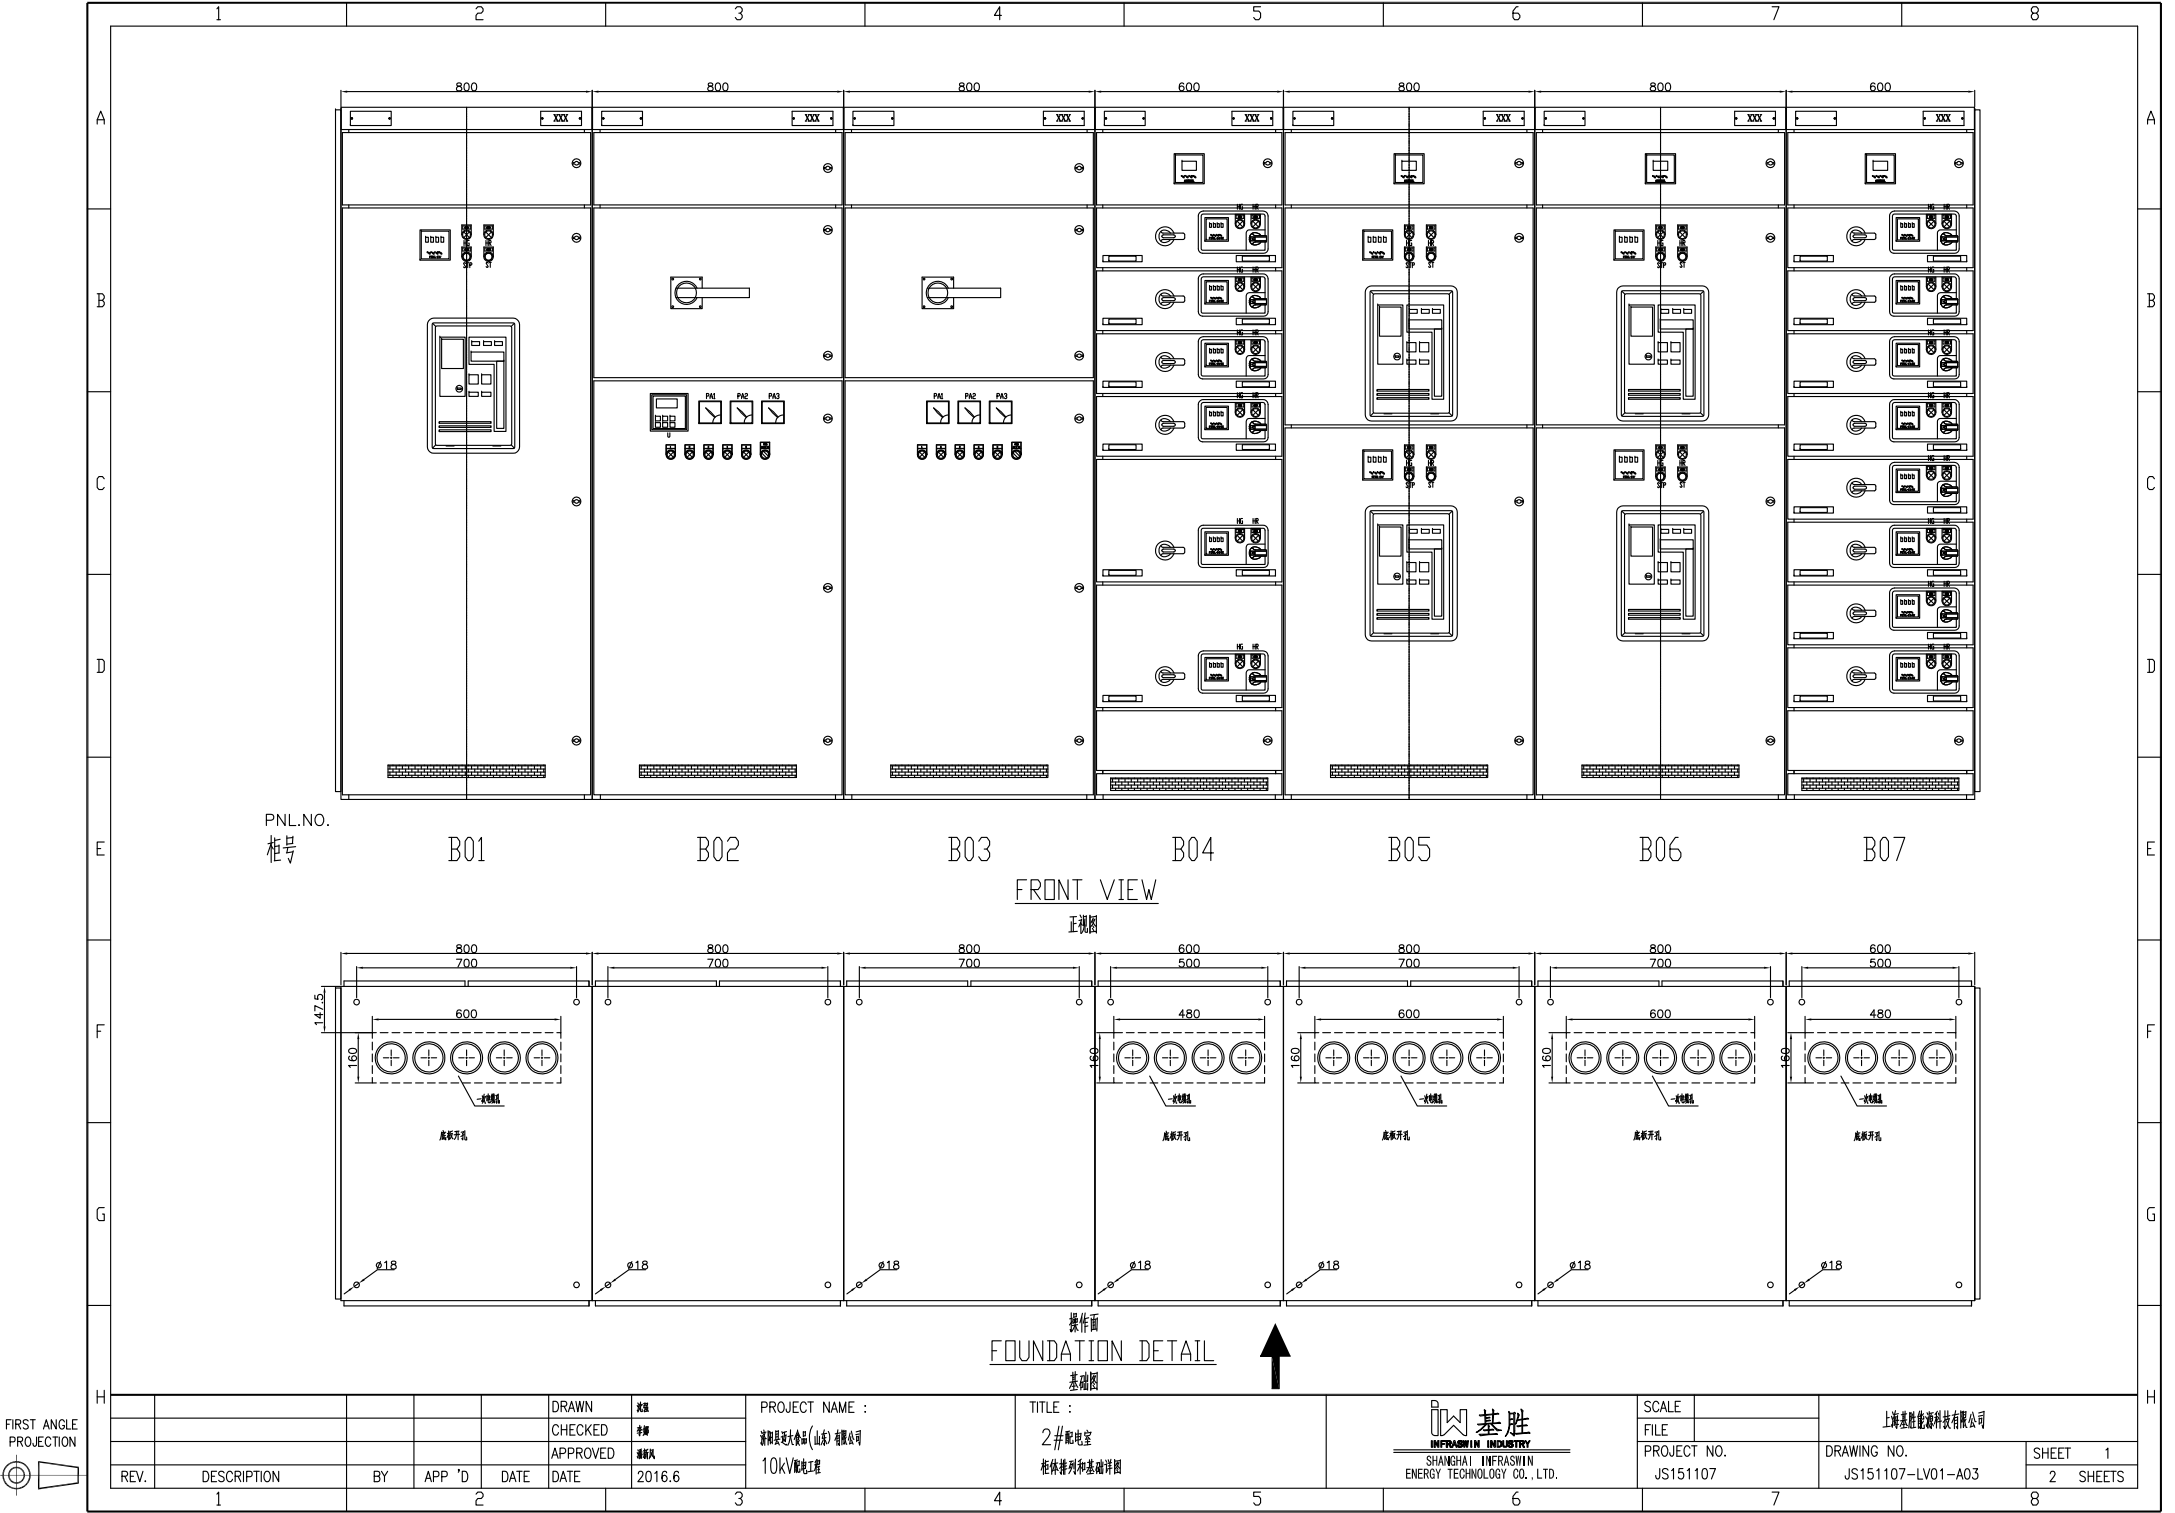

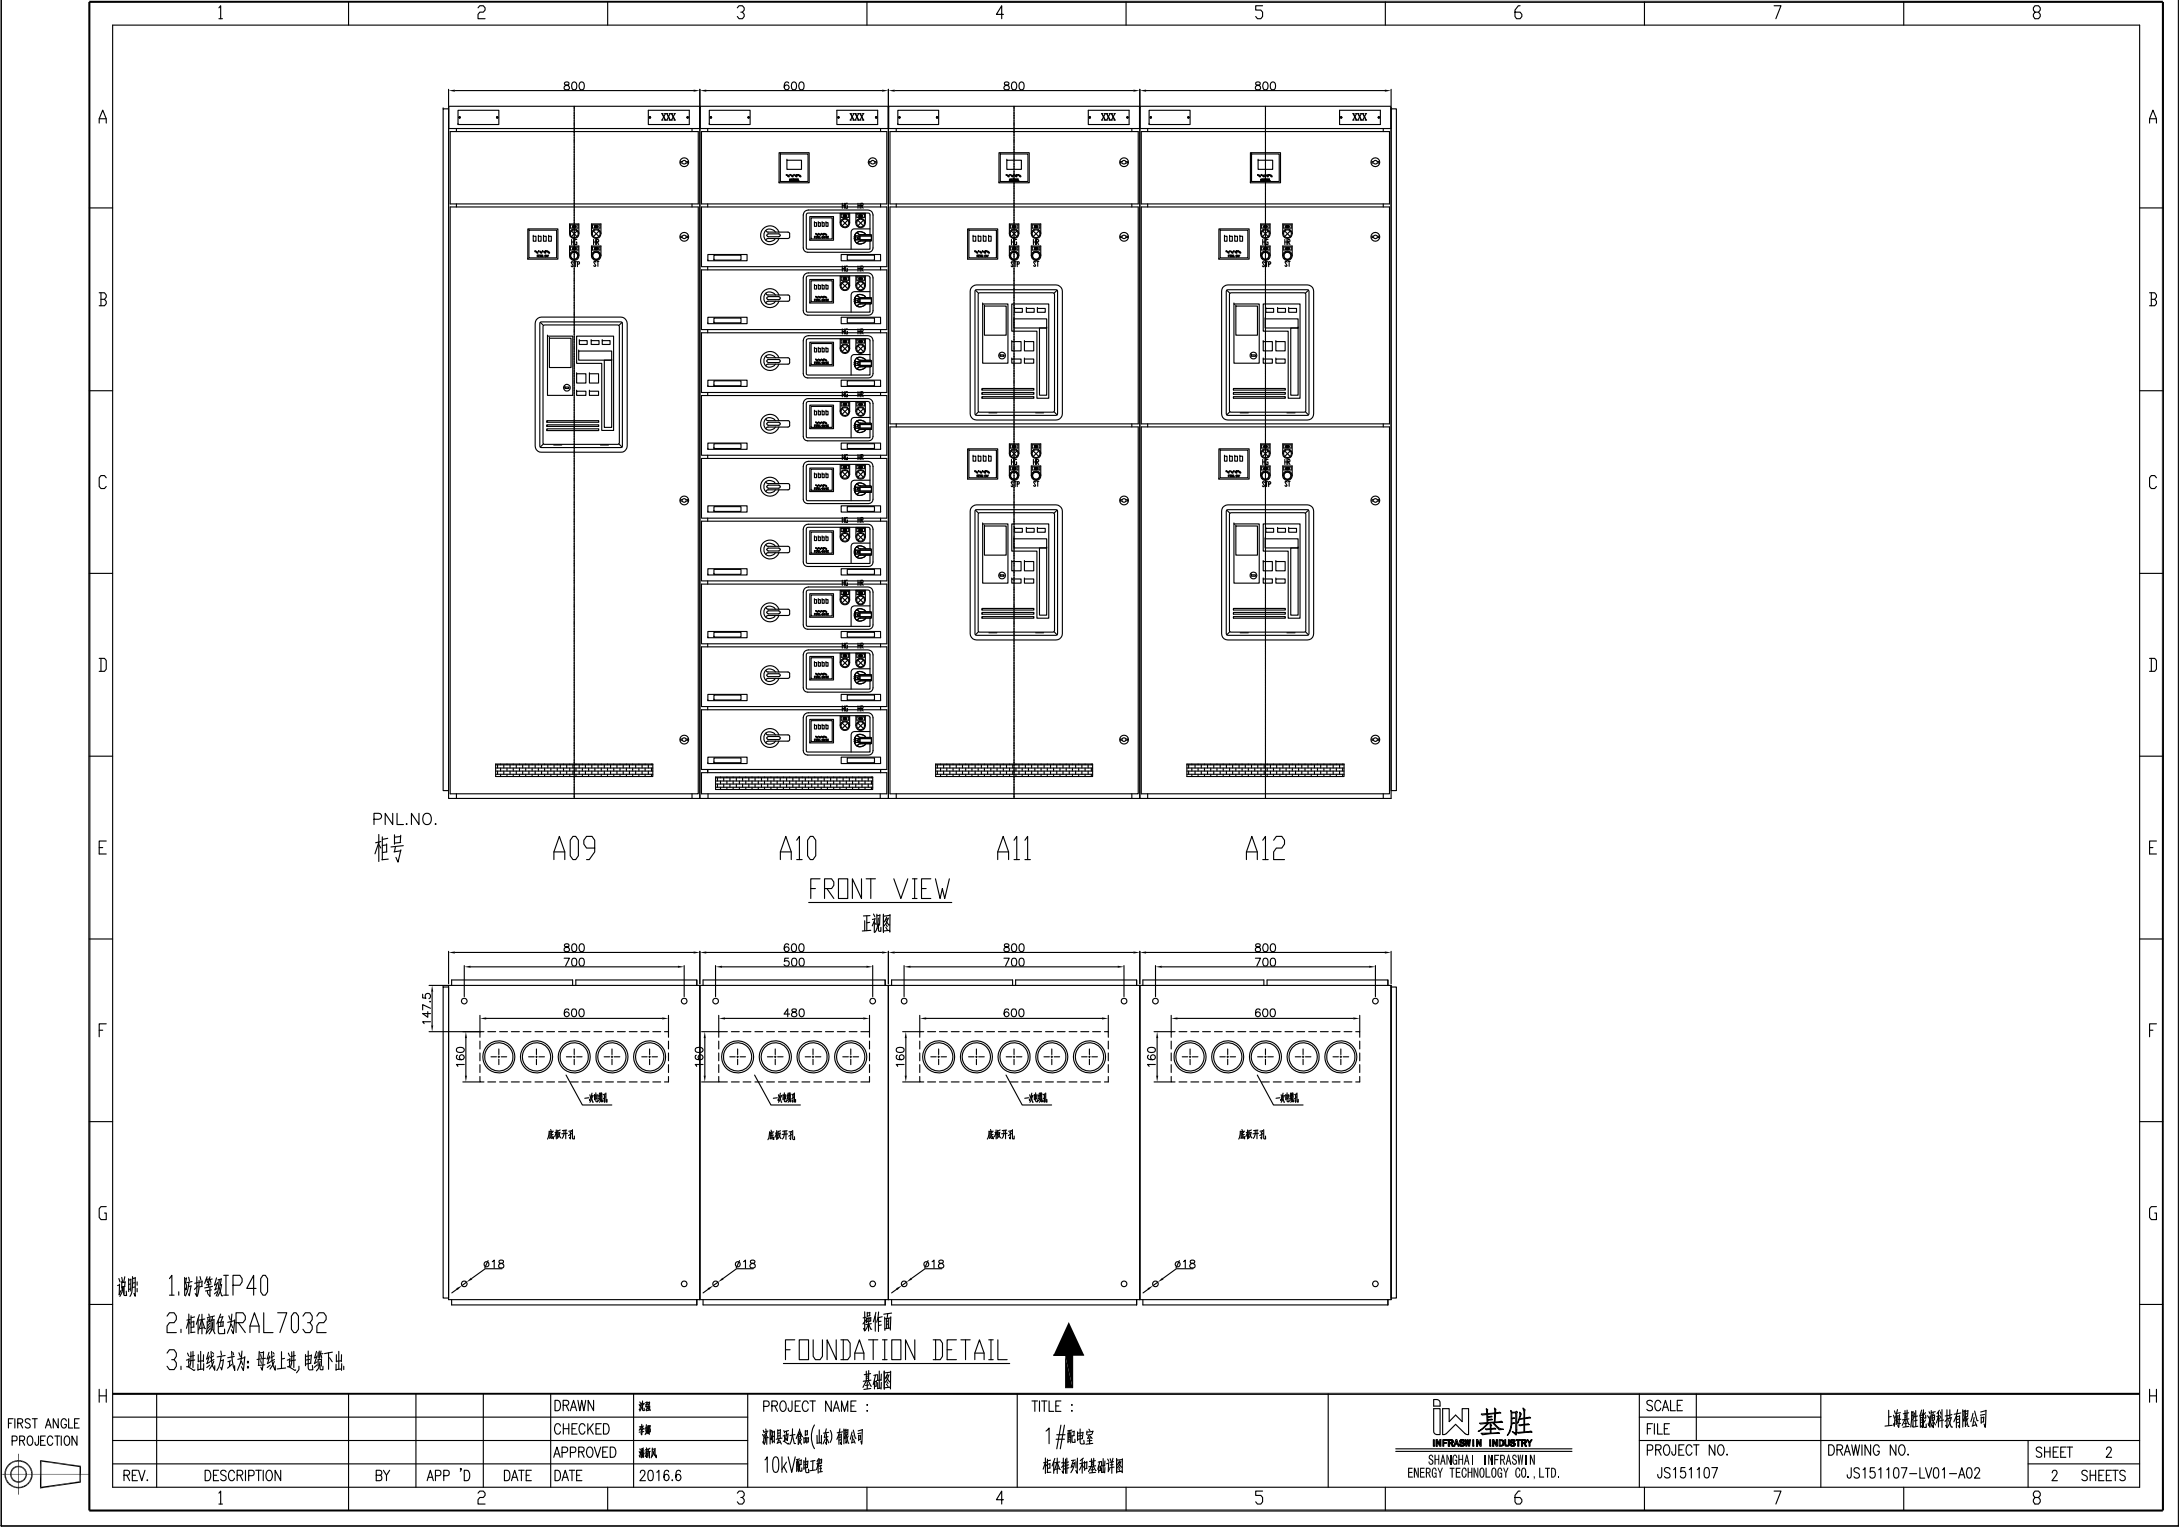


DRAWN		PROJECT NAME :		TITLE :		SCALE		SHANGHAI INFRASWIN ENERGY TECHNOLOGY CO., LTD.	
CHECKED		1# 配电室		柜体排列和基础详图		FILE		DRAWING NO.	
APPROVED		10KV/配电工程				PROJECT NO.		JS151107-LV01-A02	
DATE		2016.6				JS151107		SHEET 2	
REV.		DESCRIPTION		BY		APP		DATE	
1									

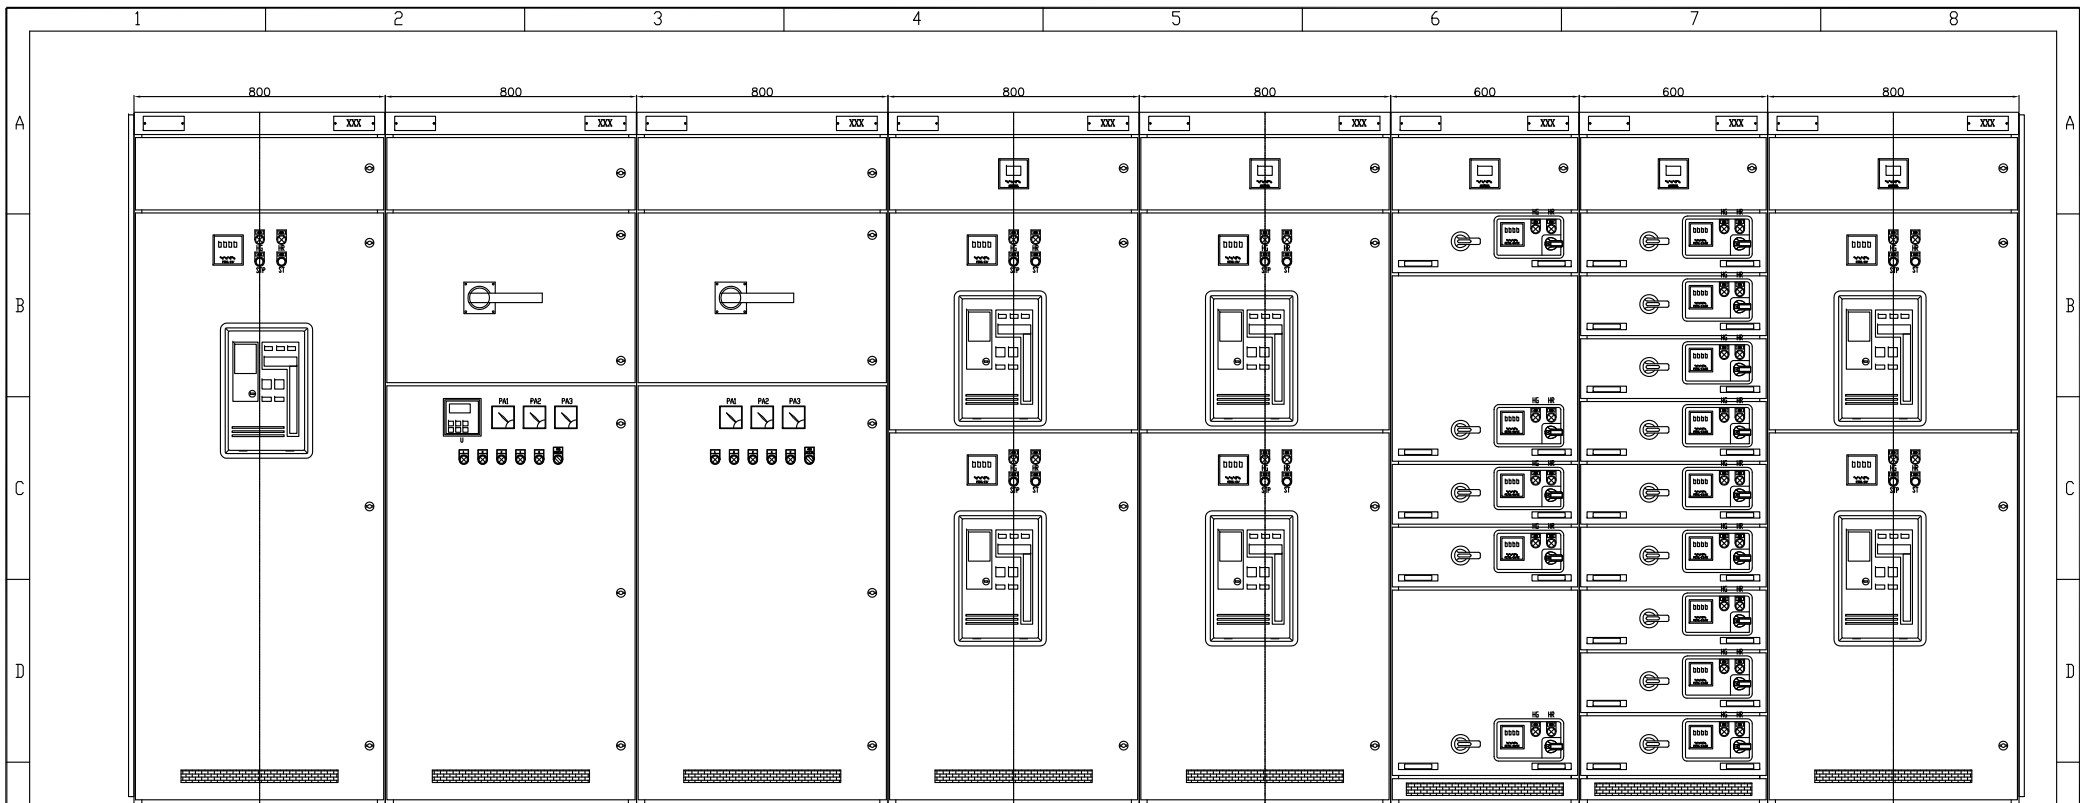

PNL.NO. 柜号 A01 A02 A03 A04 A05 A06 A07 A08

FRONT VIEW
正视图

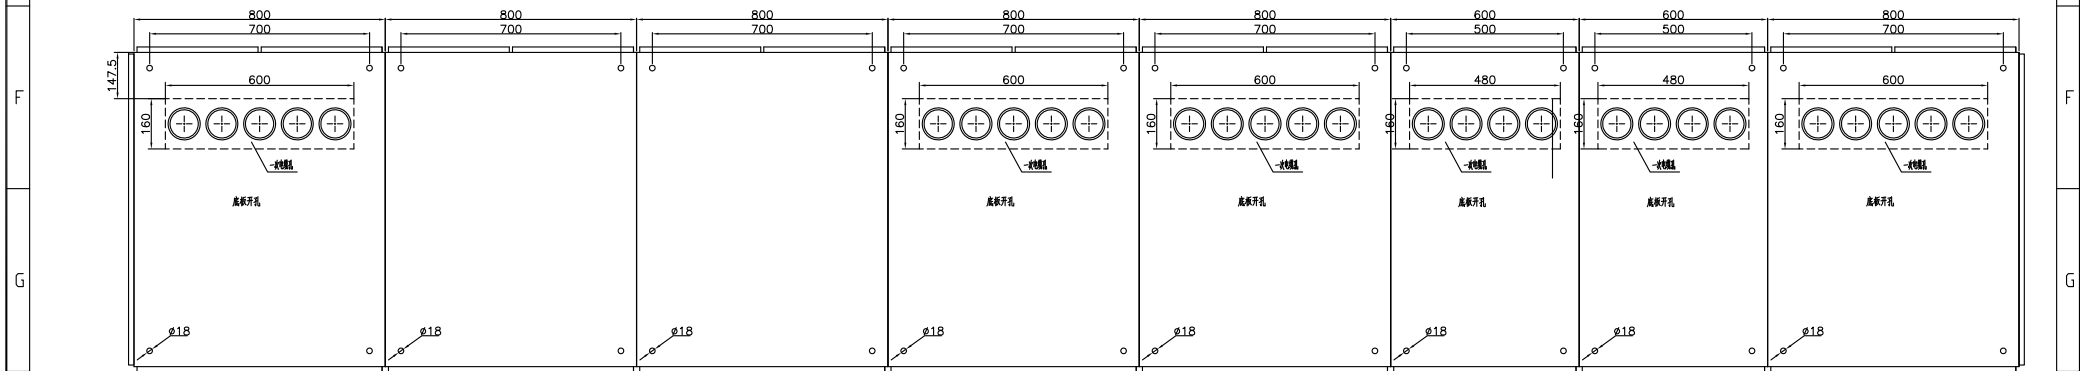

操作面
FOUNDATION DETAIL
基础图



FIRST ANGLE
PROJECTION

DRAWN		CHECKED		APPROVED		DATE		PROJECT NAME :		TITLE :		SCALE		DRAWING NO.		SHEET 1	
REV.		DESCRIPTION		BY		APP 'D		DATE		2016.6		SHANGHAI INFRASWIN ENERGY TECHNOLOGY CO., LTD.		JS151107		2 SHEETS	
1		2		3		4		5		6		7		8			