


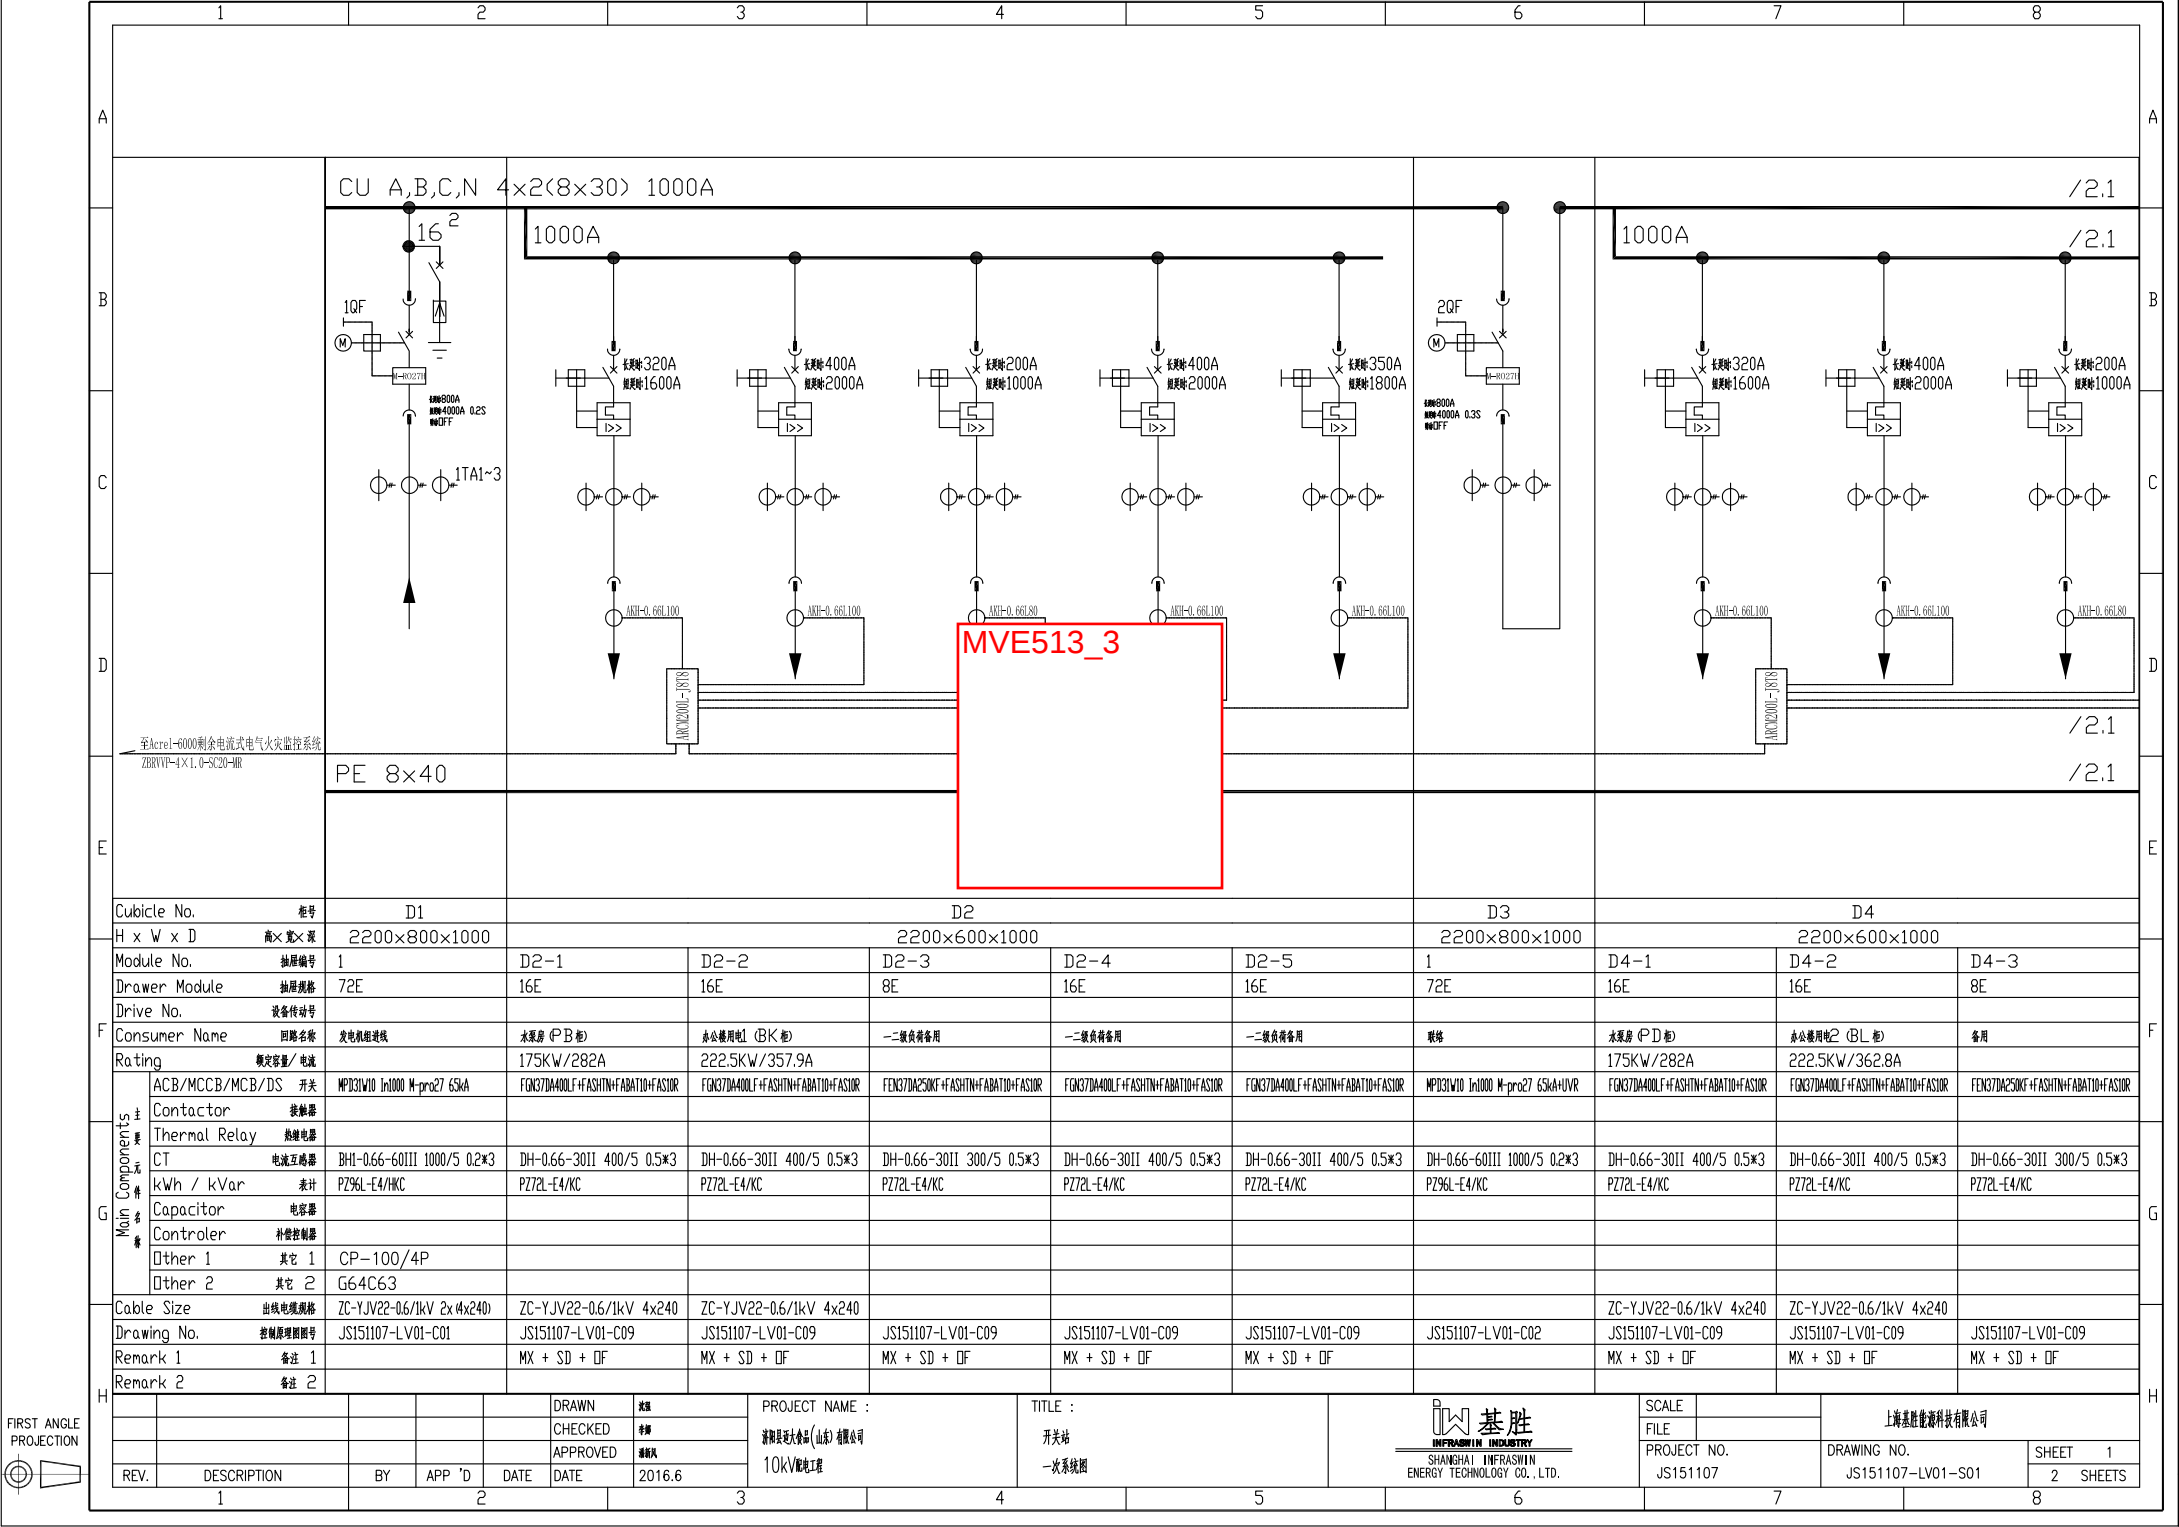



Cubicle No.		柜号	D1		D2			D3		D4		
H x W x D		高×宽×深	2200×800×1000		2200×600×1000			2200×800×1000		2200×600×1000		
Module No.		抽屉编号	1	D2-1	D2-2	D2-3	D2-4	D2-5	1	D4-1	D4-2	D4-3
Drawer Module		抽屉规格	72E	16E	16E	8E	16E	16E	72E	16E	16E	8E
Drive No.		设备传动号										
Consumer Name		回路名称	发电机进线	水泵房 (PB柜)	办公楼用电1 (BK柜)	一二级负荷备用	一二级负荷备用	一二级负荷备用	照明	水泵房 (PD柜)	办公楼用电2 (BL柜)	备用
Rating		额定容量/电流		175KW/282A	222.5KW/357.9A					175KW/282A	222.5KW/362.8A	
Main Components	ACB/MCCB/MCB/DS	开关	MPD31W10 1x1000 M-pro27 65kA	FCK37DA400LF+FSHTN+FABATID+FSASOR	FCK37DA400LF+FSHTN+FABATID+FSASOR	FCK37DA250KF+FSHTN+FABATID+FSASOR	FCK37DA400LF+FSHTN+FABATID+FSASOR	FCK37DA400LF+FSHTN+FABATID+FSASOR	MPD31W10 1x1000 M-pro27 65kA+UVR	FCK37DA400LF+FSHTN+FABATID+FSASOR	FCK37DA400LF+FSHTN+FABATID+FSASOR	FCK37DA250KF+FSHTN+FABATID+FSASOR
	Contactors	接触器										
	Thermal Relay	热继电器										
	CT	电流互感器	BHI-0.66-60III 1000/5 0.2*3	DH-0.66-30II 400/5 0.5*3	DH-0.66-30II 400/5 0.5*3	DH-0.66-30II 300/5 0.5*3	DH-0.66-30II 400/5 0.5*3	DH-0.66-30II 400/5 0.5*3	DH-0.66-60III 1000/5 0.2*3	DH-0.66-30II 400/5 0.5*3	DH-0.66-30II 400/5 0.5*3	DH-0.66-30II 300/5 0.5*3
	kWh / kVar	表计	PZ96L-E4/KC	PZ72L-E4/KC	PZ72L-E4/KC	PZ72L-E4/KC	PZ72L-E4/KC	PZ72L-E4/KC	PZ96L-E4/KC	PZ72L-E4/KC	PZ72L-E4/KC	PZ72L-E4/KC
	Capacitor	电容器										
	Controler	补偿控制器										
	Other 1	其它 1	CP-100/4P									
	Other 2	其它 2	G64C63									
Cable Size		出线电缆规格	ZC-YJV22-0.6/1kV 2x (4x240)	ZC-YJV22-0.6/1kV 4x240	ZC-YJV22-0.6/1kV 4x240					ZC-YJV22-0.6/1kV 4x240	ZC-YJV22-0.6/1kV 4x240	
Drawing No.		控制原理图编号	JS151107-LV01-C01	JS151107-LV01-C09	JS151107-LV01-C09	JS151107-LV01-C09	JS151107-LV01-C09	JS151107-LV01-C09	JS151107-LV01-C02	JS151107-LV01-C09	JS151107-LV01-C09	JS151107-LV01-C09
Remark 1		备注 1		MX + SD + OF	MX + SD + OF	MX + SD + OF	MX + SD + OF	MX + SD + OF		MX + SD + OF	MX + SD + OF	MX + SD + OF
Remark 2		备注 2										

REV.		DESCRIPTION		BY	APP 'D	DATE	DRAWN		审核	PROJECT NAME :		TITLE :		SCALE		FILE		PROJECT NO.		DRAWING NO.		SHEET 1
							CHECKED		审核	2016.6		开关站						JS151107		JS151107-LV01-S01		2 SHEETS
							APPROVED		审核			一次系统图										





上海基胜能源科技有限公司

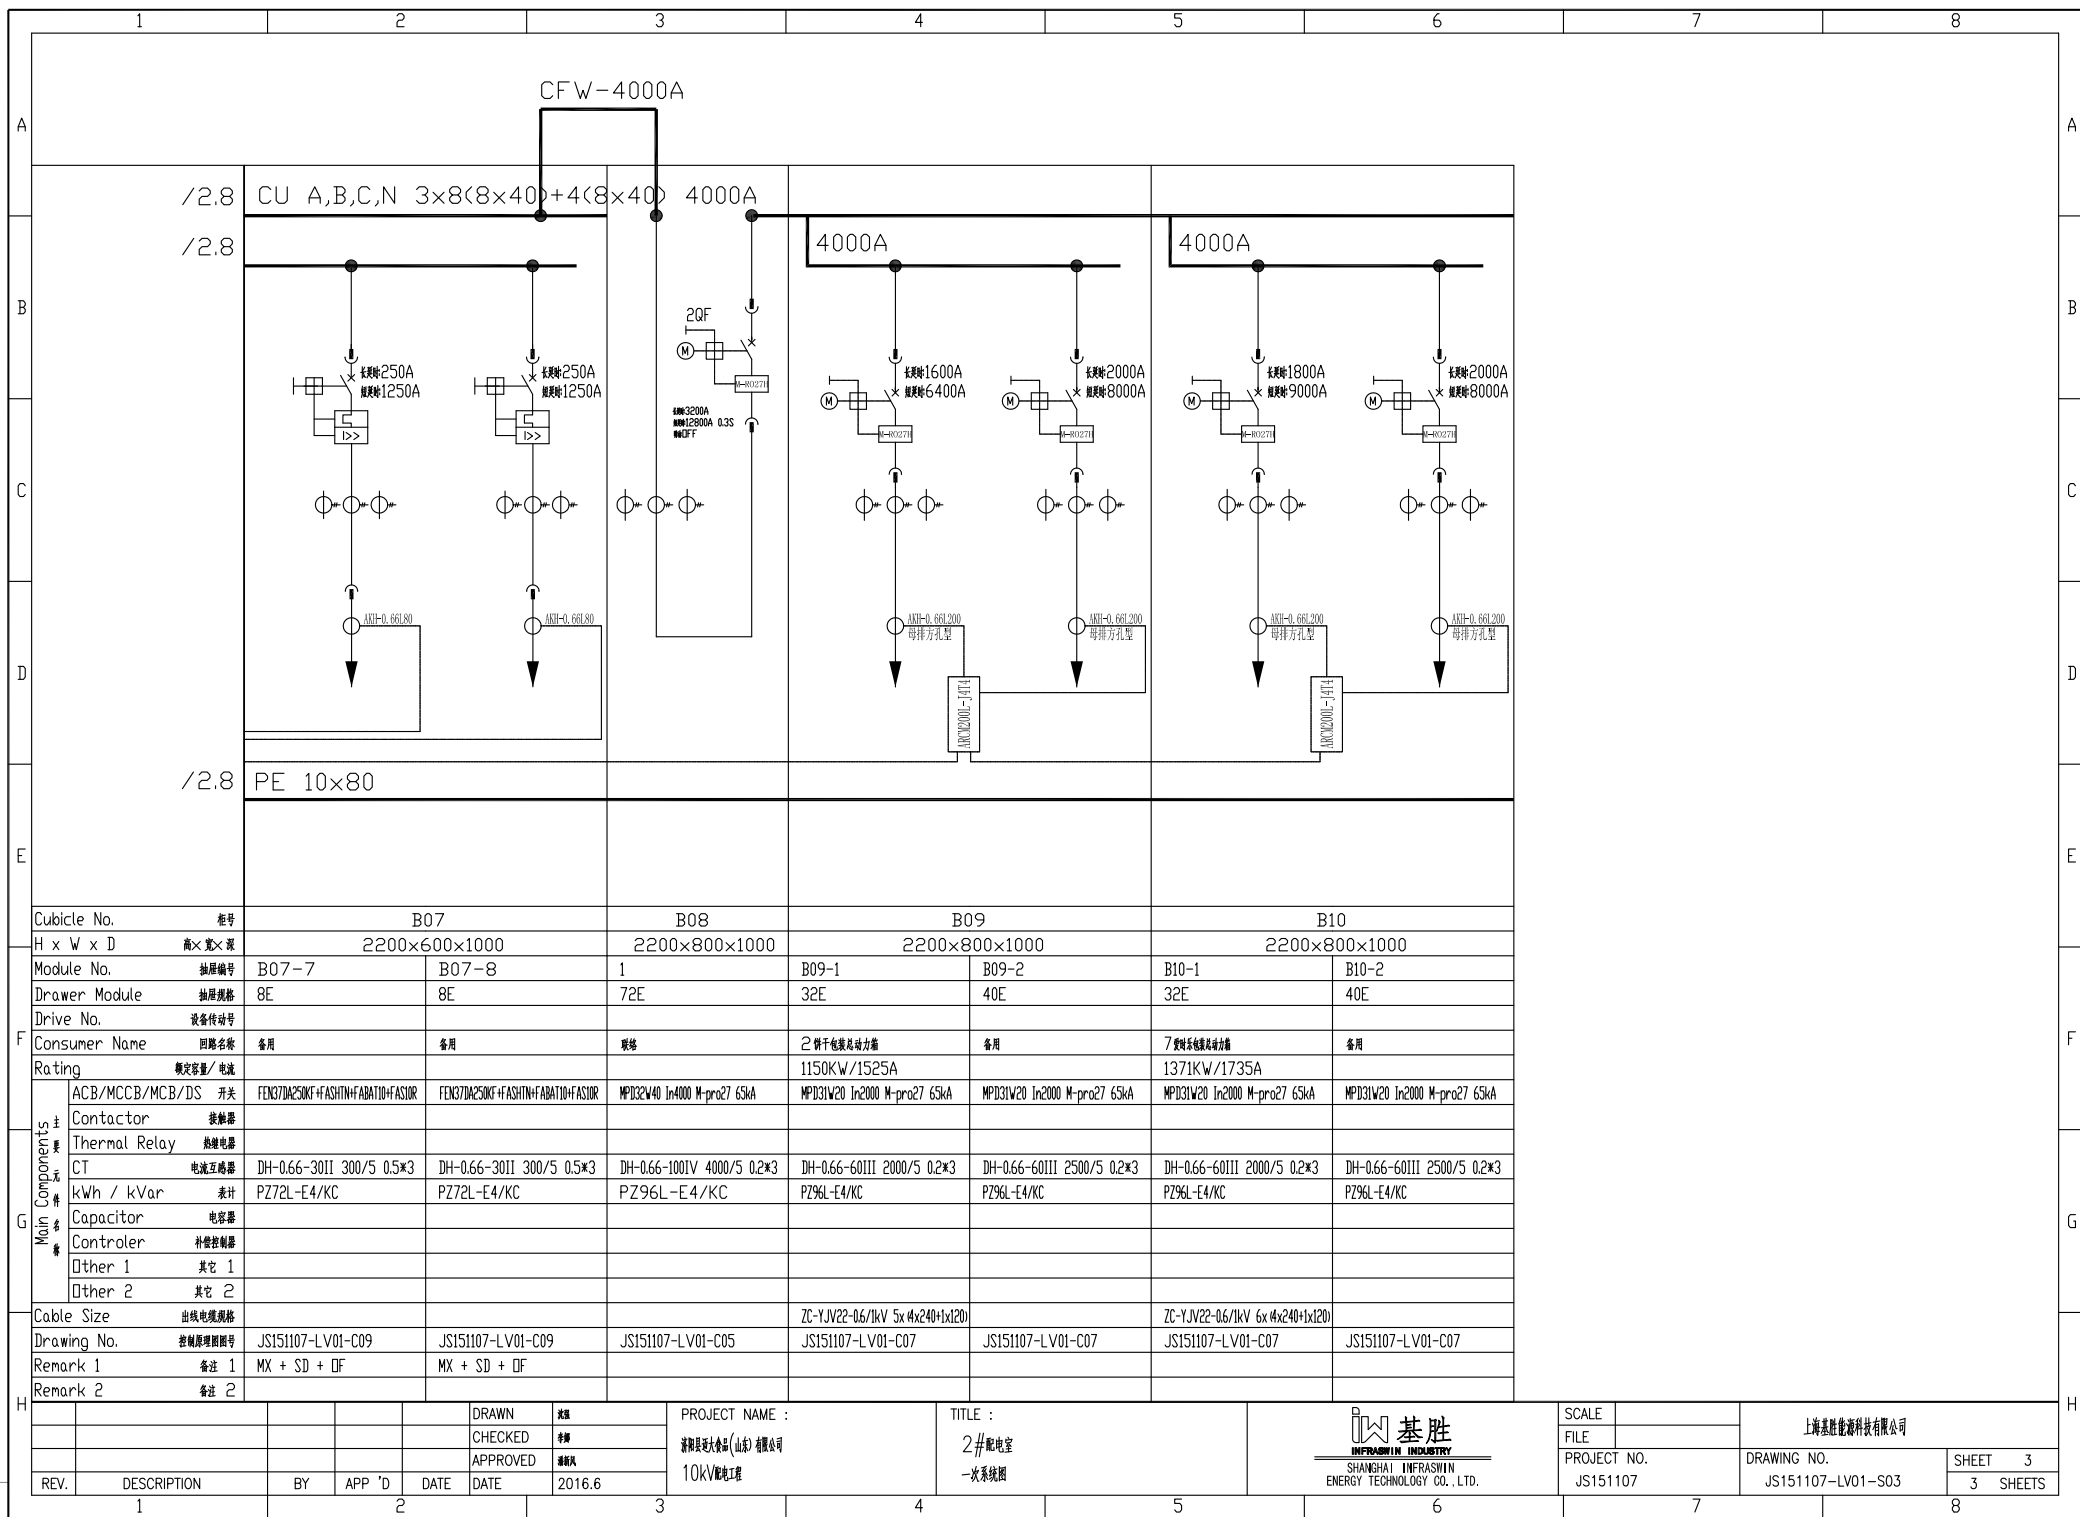

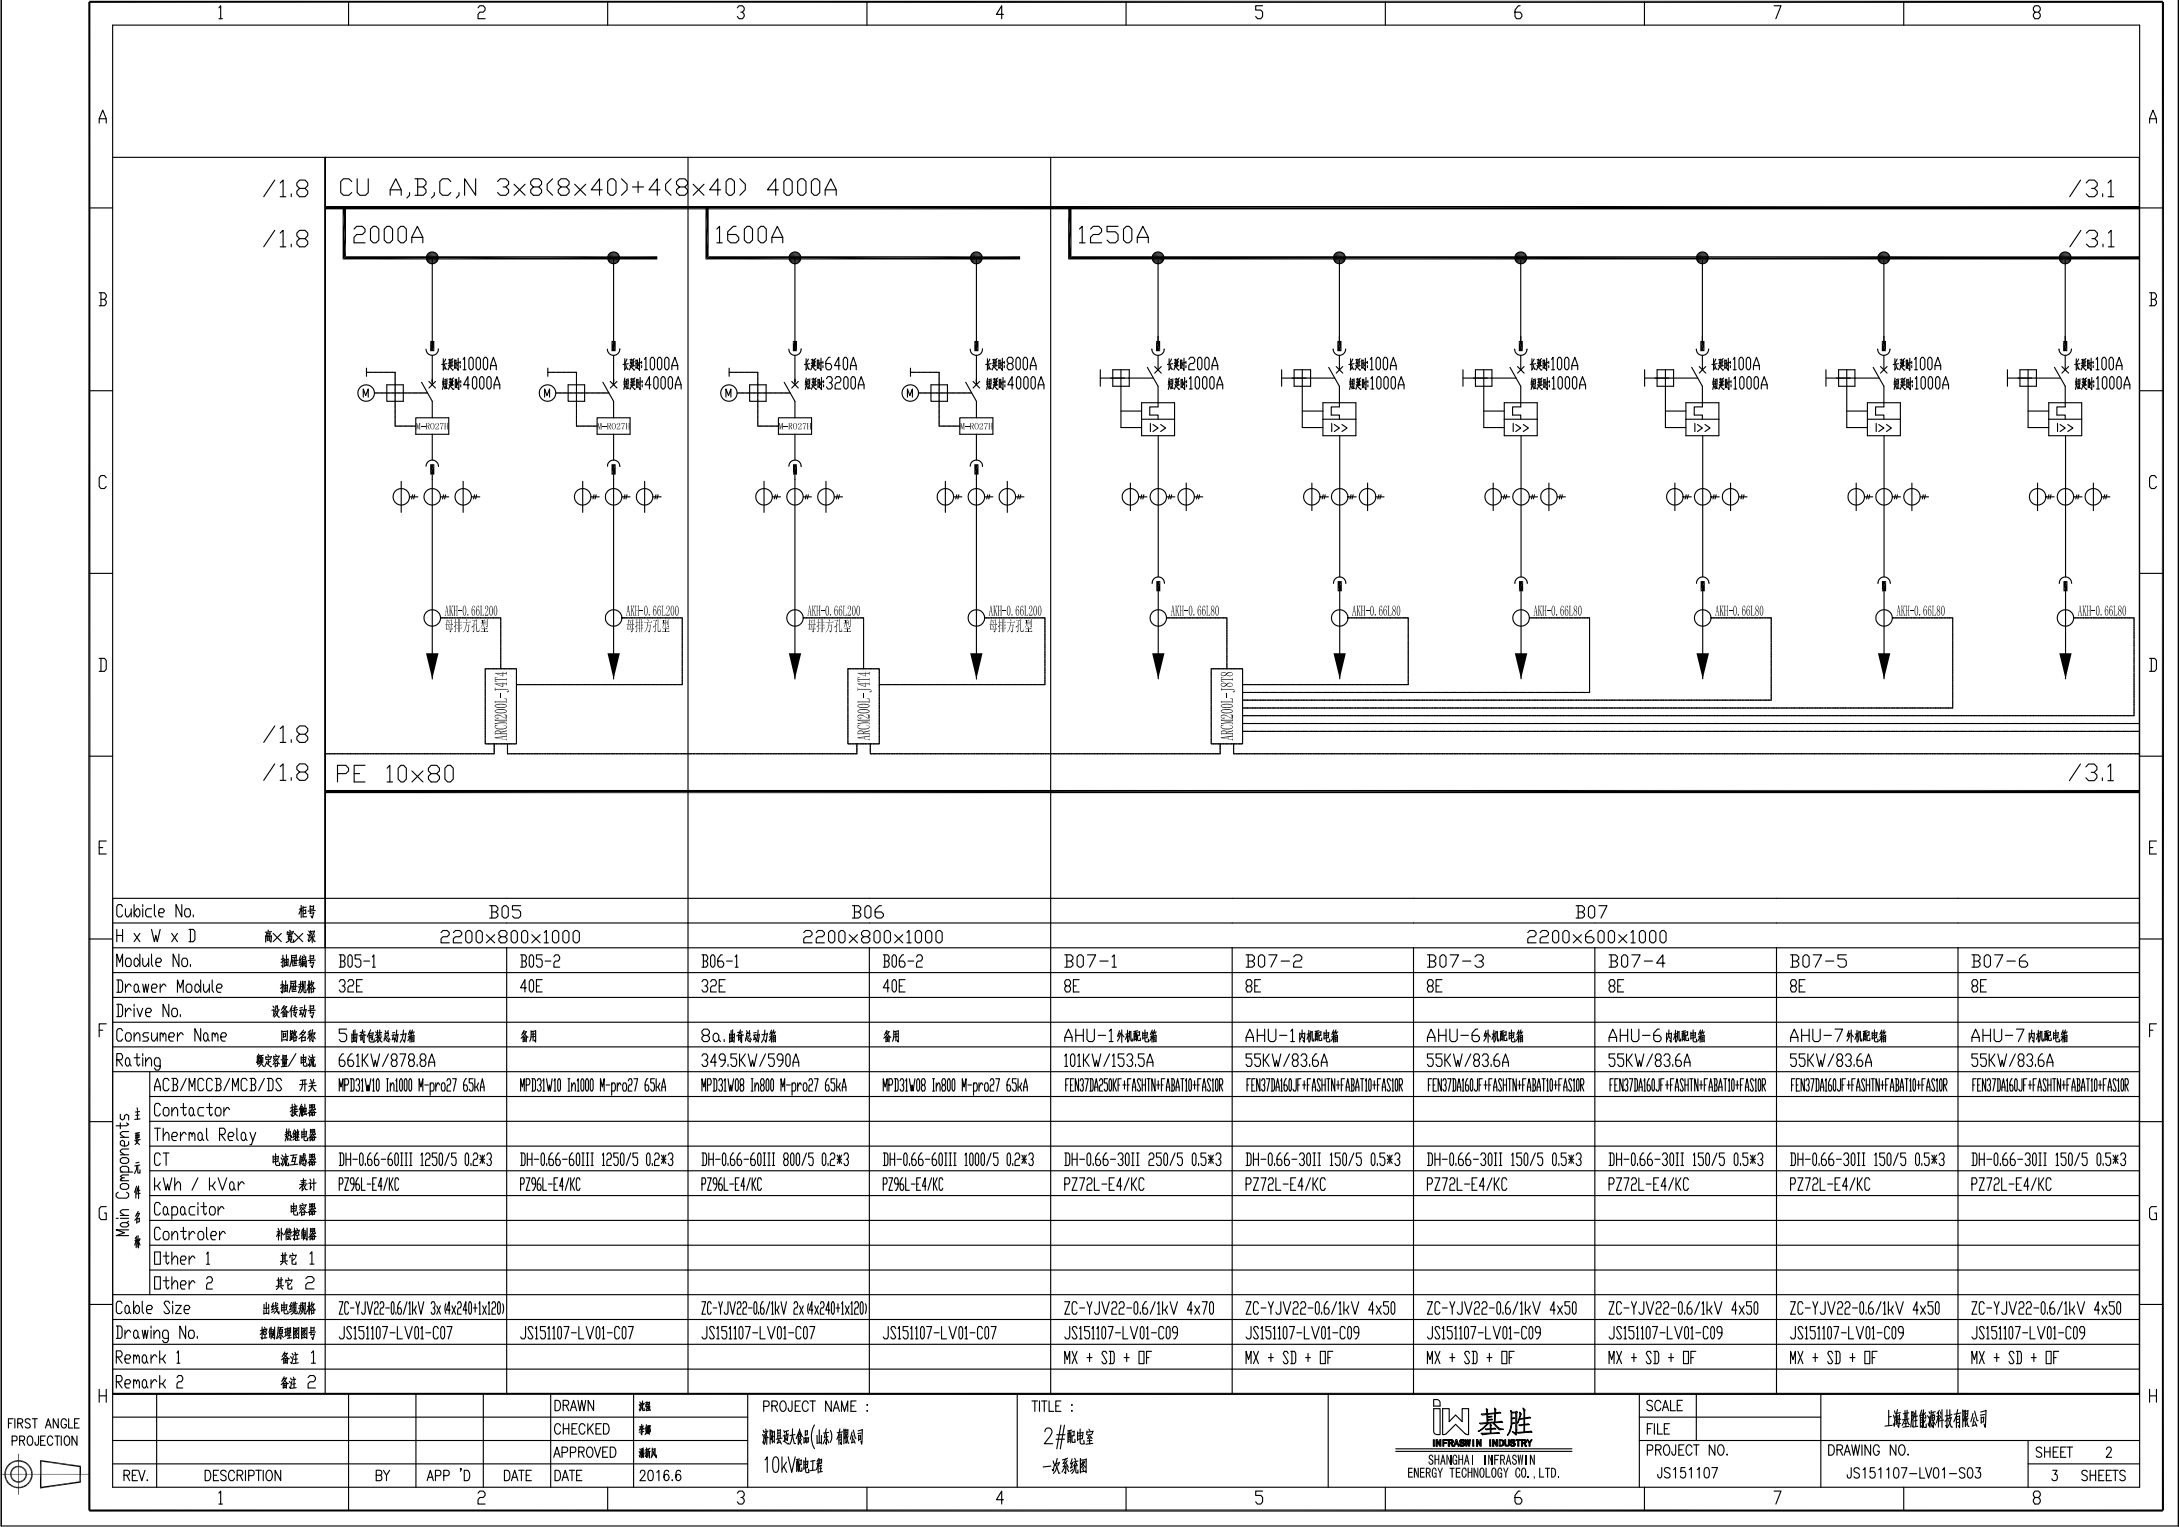

Cubicle No.		B05		B06		B07																
H x W x D		2200x800x1000		2200x800x1000		2200x600x1000																
Module No.		B05-1		B05-2		B06-1		B06-2		B07-1		B07-2		B07-3		B07-4		B07-5		B07-6		
Drawer Module		32E		40E		32E		40E		8E		8E		8E		8E		8E		8E		
Drive No.																						
Consumer Name		5 直冷包壳及动力箱		备用		8a. 直冷包壳及动力箱		备用		AHU-1 外机配电箱		AHU-1 内机配电箱		AHU-6 外机配电箱		AHU-6 内机配电箱		AHU-7 外机配电箱		AHU-7 内机配电箱		
Rating		661KW/878.8A				349.5KW/590A				101KW/153.5A		55KW/83.6A		55KW/83.6A		55KW/83.6A		55KW/83.6A		55KW/83.6A		
Main Components	ACB/MCCB/MCB/DS 开关	MPD31W10 In1000 M-pro27 65kA		MPD31W10 In1000 M-pro27 65kA		MPD31W08 In800 M-pro27 65kA		MPD31W08 In800 M-pro27 65kA		FEN37DA250KF+FSHTN+FBAT10+FASSUR		FEN37DA160JF+FSHTN+FBAT10+FASSUR		FEN37DA160JF+FSHTN+FBAT10+FASSUR		FEN37DA160JF+FSHTN+FBAT10+FASSUR		FEN37DA160JF+FSHTN+FBAT10+FASSUR		FEN37DA160JF+FSHTN+FBAT10+FASSUR		
	Contactors																					
	Thermal Relay 热继电器																					
	CT 电流互感器	DH-0.66-60III 1250/5 0.2*3		DH-0.66-60III 1250/5 0.2*3		DH-0.66-60III 800/5 0.2*3		DH-0.66-60III 1000/5 0.2*3		DH-0.66-30II 250/5 0.5*3		DH-0.66-30II 150/5 0.5*3		DH-0.66-30II 150/5 0.5*3		DH-0.66-30II 150/5 0.5*3		DH-0.66-30II 150/5 0.5*3		DH-0.66-30II 150/5 0.5*3		
	kWh / kVar 表计	PZ96L-E4/KC		PZ96L-E4/KC		PZ96L-E4/KC		PZ96L-E4/KC		PZ72L-E4/KC		PZ72L-E4/KC		PZ72L-E4/KC		PZ72L-E4/KC		PZ72L-E4/KC		PZ72L-E4/KC		
	Capacitor 电容器																					
	Controler 补偿控制器																					
Other 1 其它 1																						
Other 2 其它 2																						
Cable Size		ZC-YJV22-0.6/1kV 3x 4x240+1x120				ZC-YJV22-0.6/1kV 2x 4x240+1x120				ZC-YJV22-0.6/1kV 4x70		ZC-YJV22-0.6/1kV 4x50		ZC-YJV22-0.6/1kV 4x50		ZC-YJV22-0.6/1kV 4x50		ZC-YJV22-0.6/1kV 4x50		ZC-YJV22-0.6/1kV 4x50		
Drawing No.		JS151107-LV01-C07		JS151107-LV01-C07		JS151107-LV01-C07		JS151107-LV01-C07		JS151107-LV01-C09		JS151107-LV01-C09		JS151107-LV01-C09		JS151107-LV01-C09		JS151107-LV01-C09		JS151107-LV01-C09		
Remark 1		备注 1								MX + SD + DF		MX + SD + DF		MX + SD + DF		MX + SD + DF		MX + SD + DF		MX + SD + DF		
Remark 2		备注 2																				
					DRAWN	校核	PROJECT NAME :			TITLE :					SCALE		上海基胜能源科技有限公司					
					CHECKED	审核	源和昆太水务(山东)有限公司			2#配电箱												
					APPROVED	审核人	10KV配电工程			一次系统图							PROJECT NO.		DRAWING NO.		SHEET 2	
REV.	DESCRIPTION	BY	APP 'D	DATE	DATE	2016.6							SHANGHAI INFRASWIN ENERGY TECHNOLOGY CO., LTD.				JS151107		JS151107-LV01-S03		3 SHEETS	

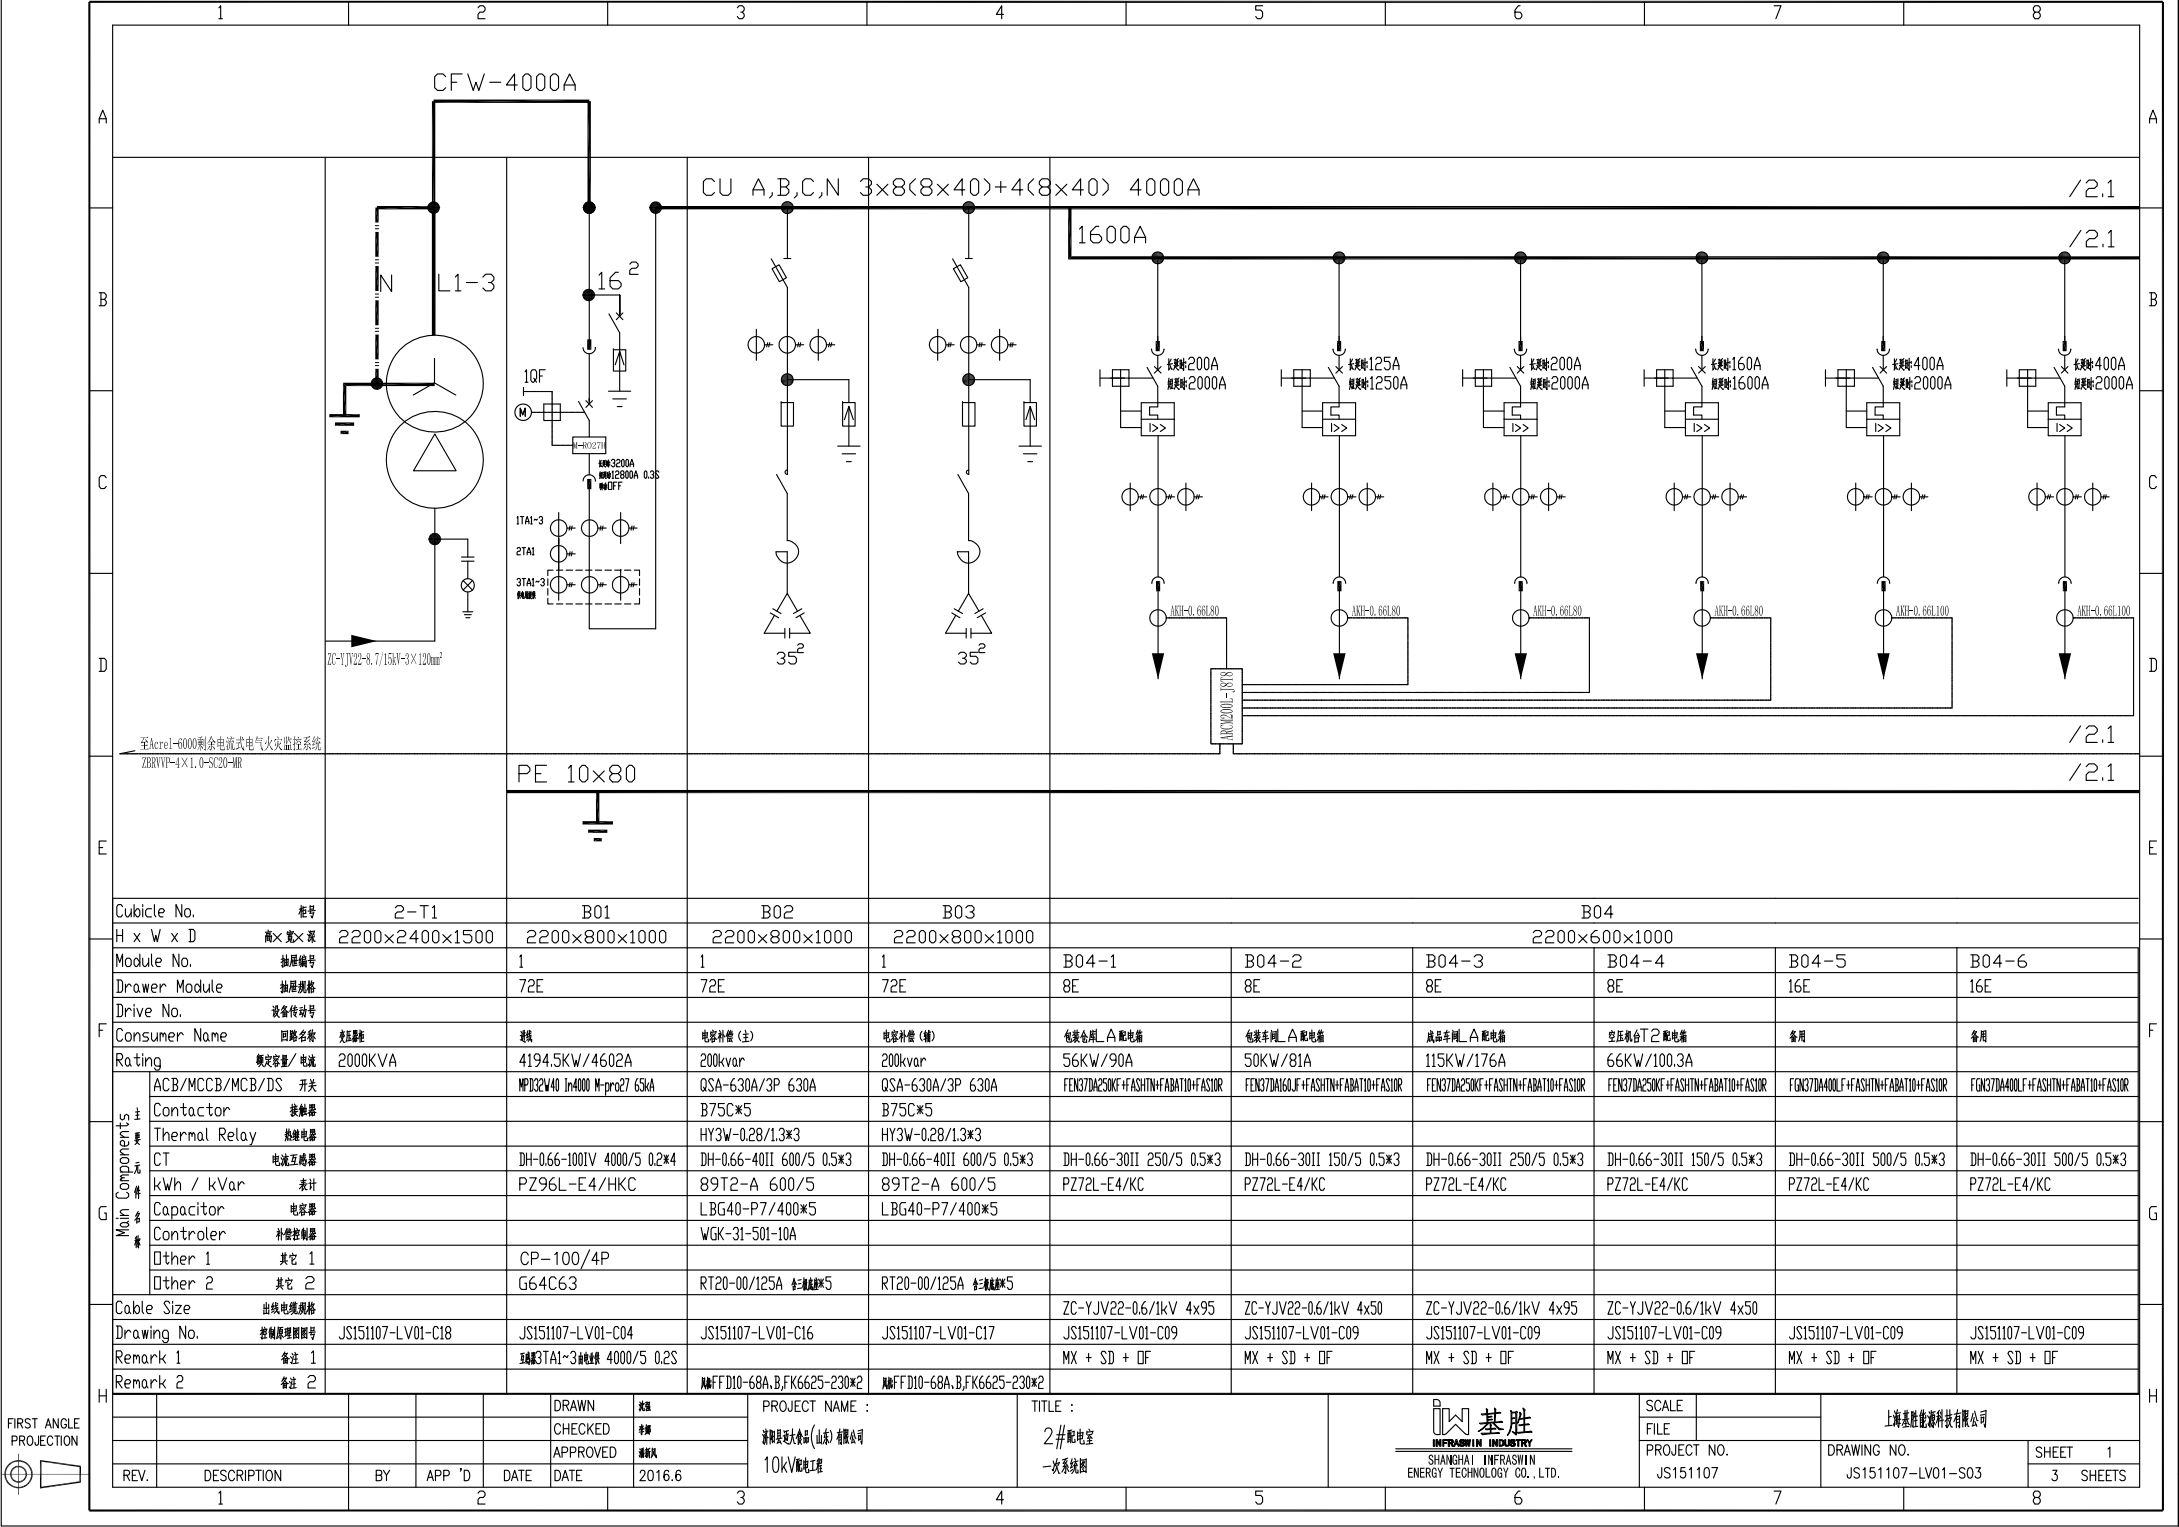


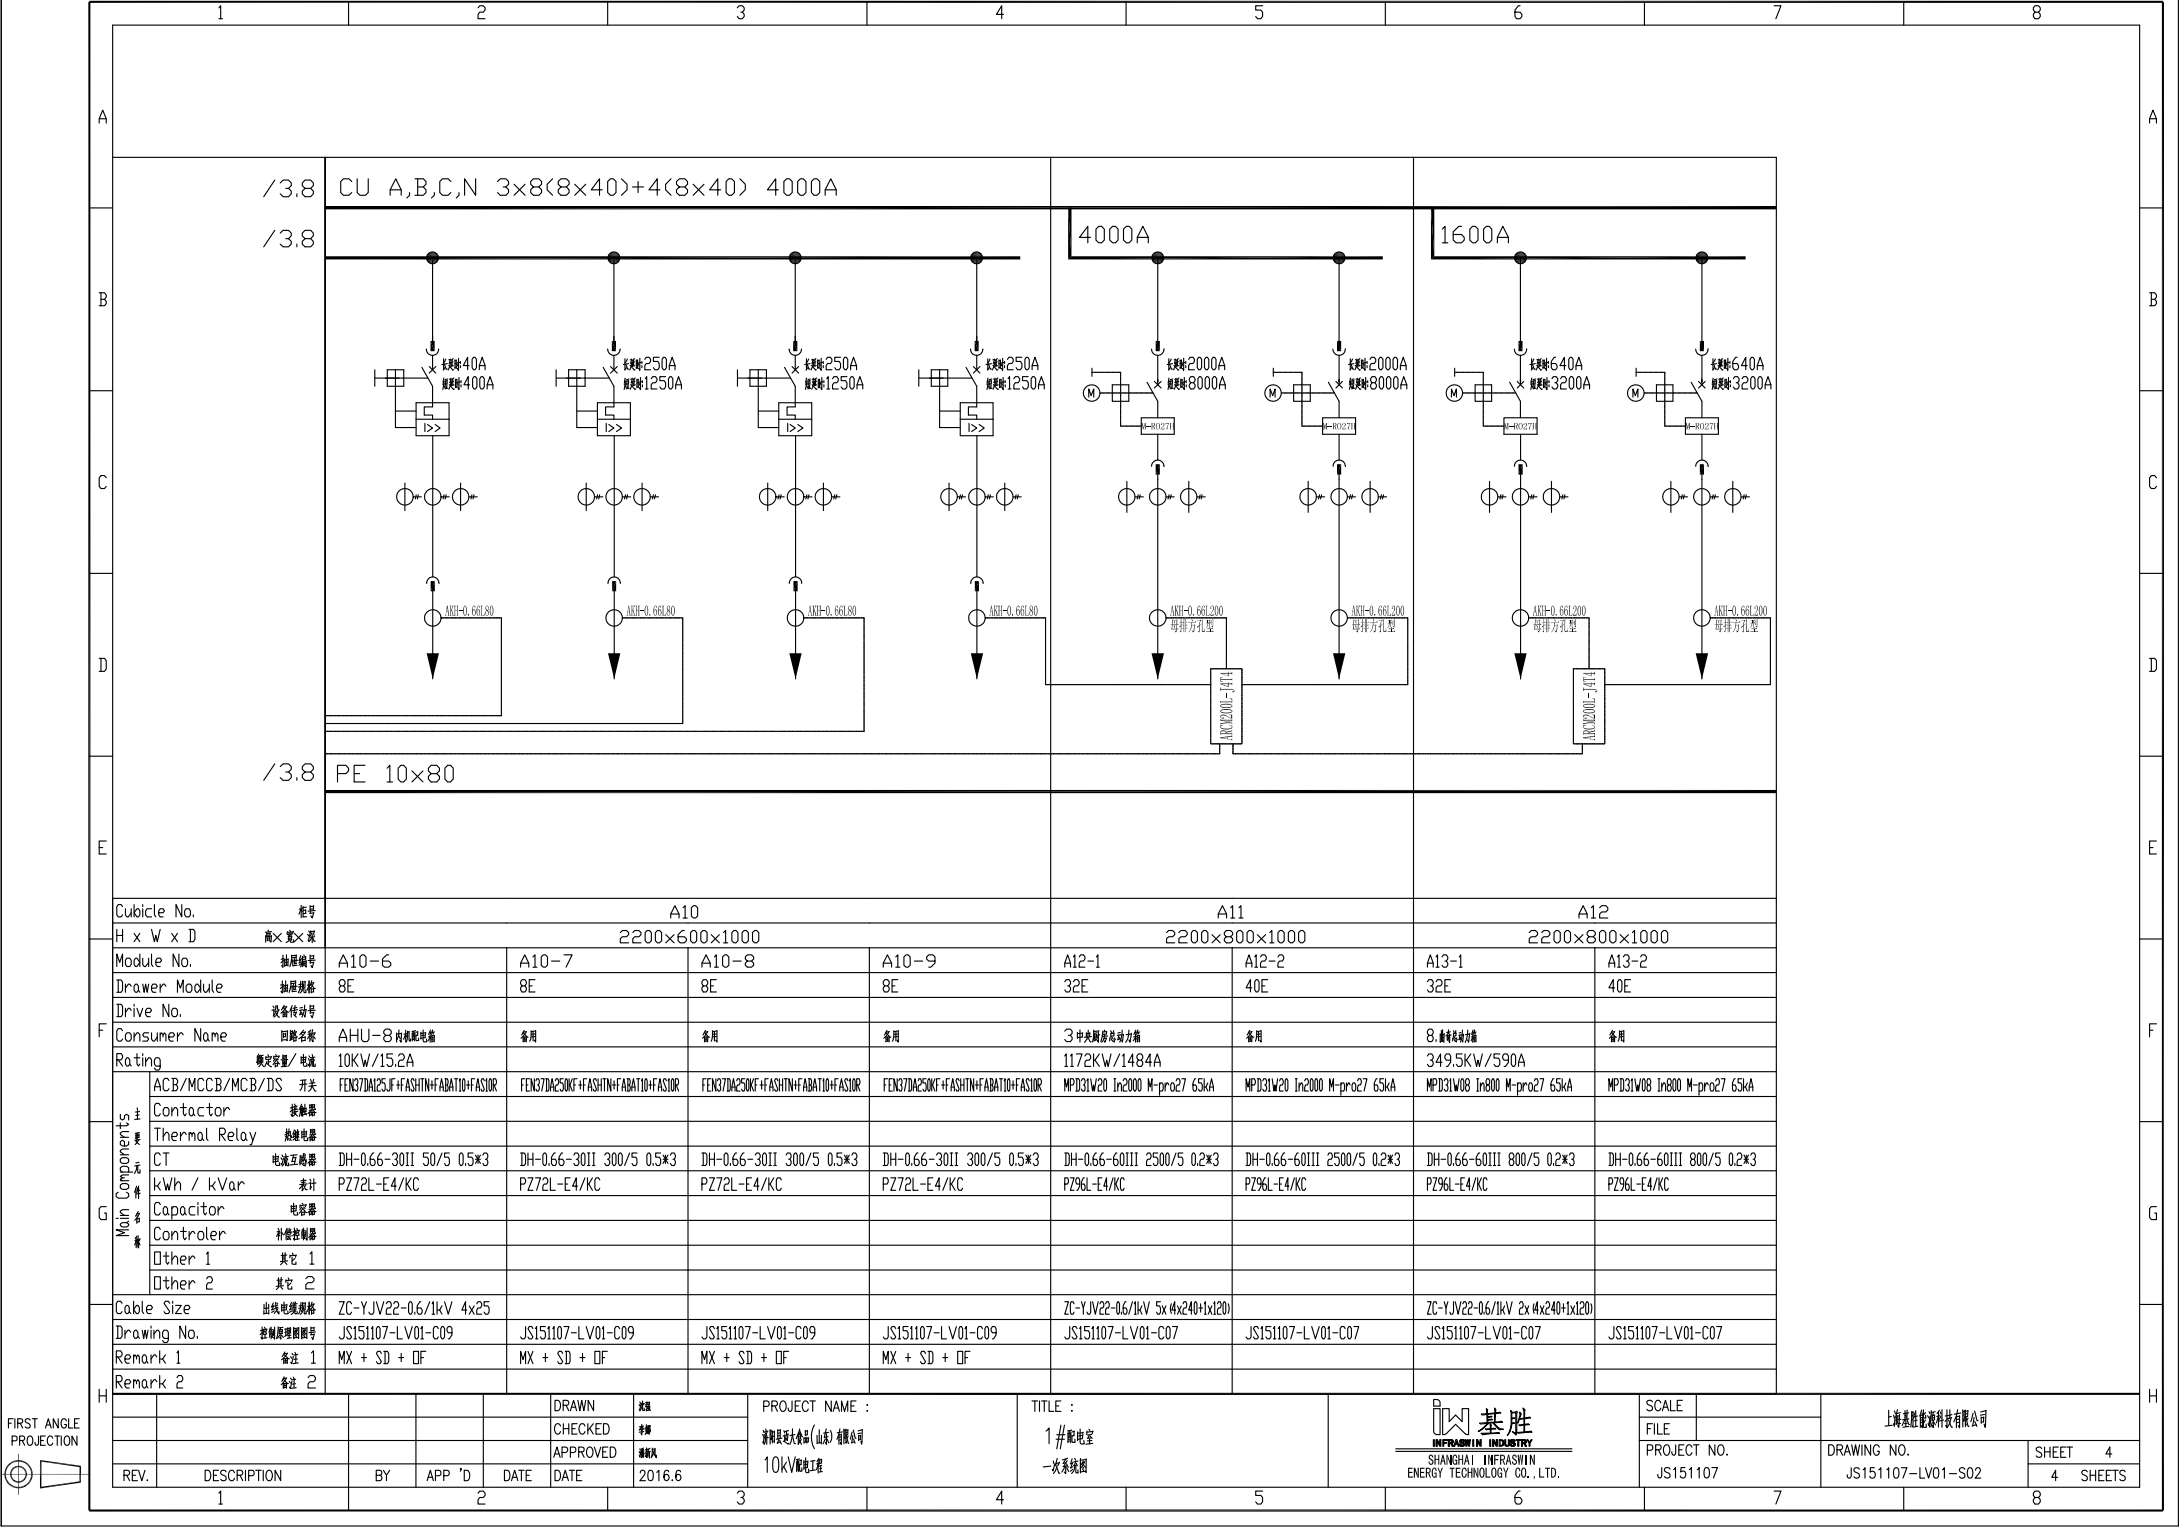

上海基胜能源科技有限公司

DRAWING NO. JS151107-LV01-S02

SHEET 4

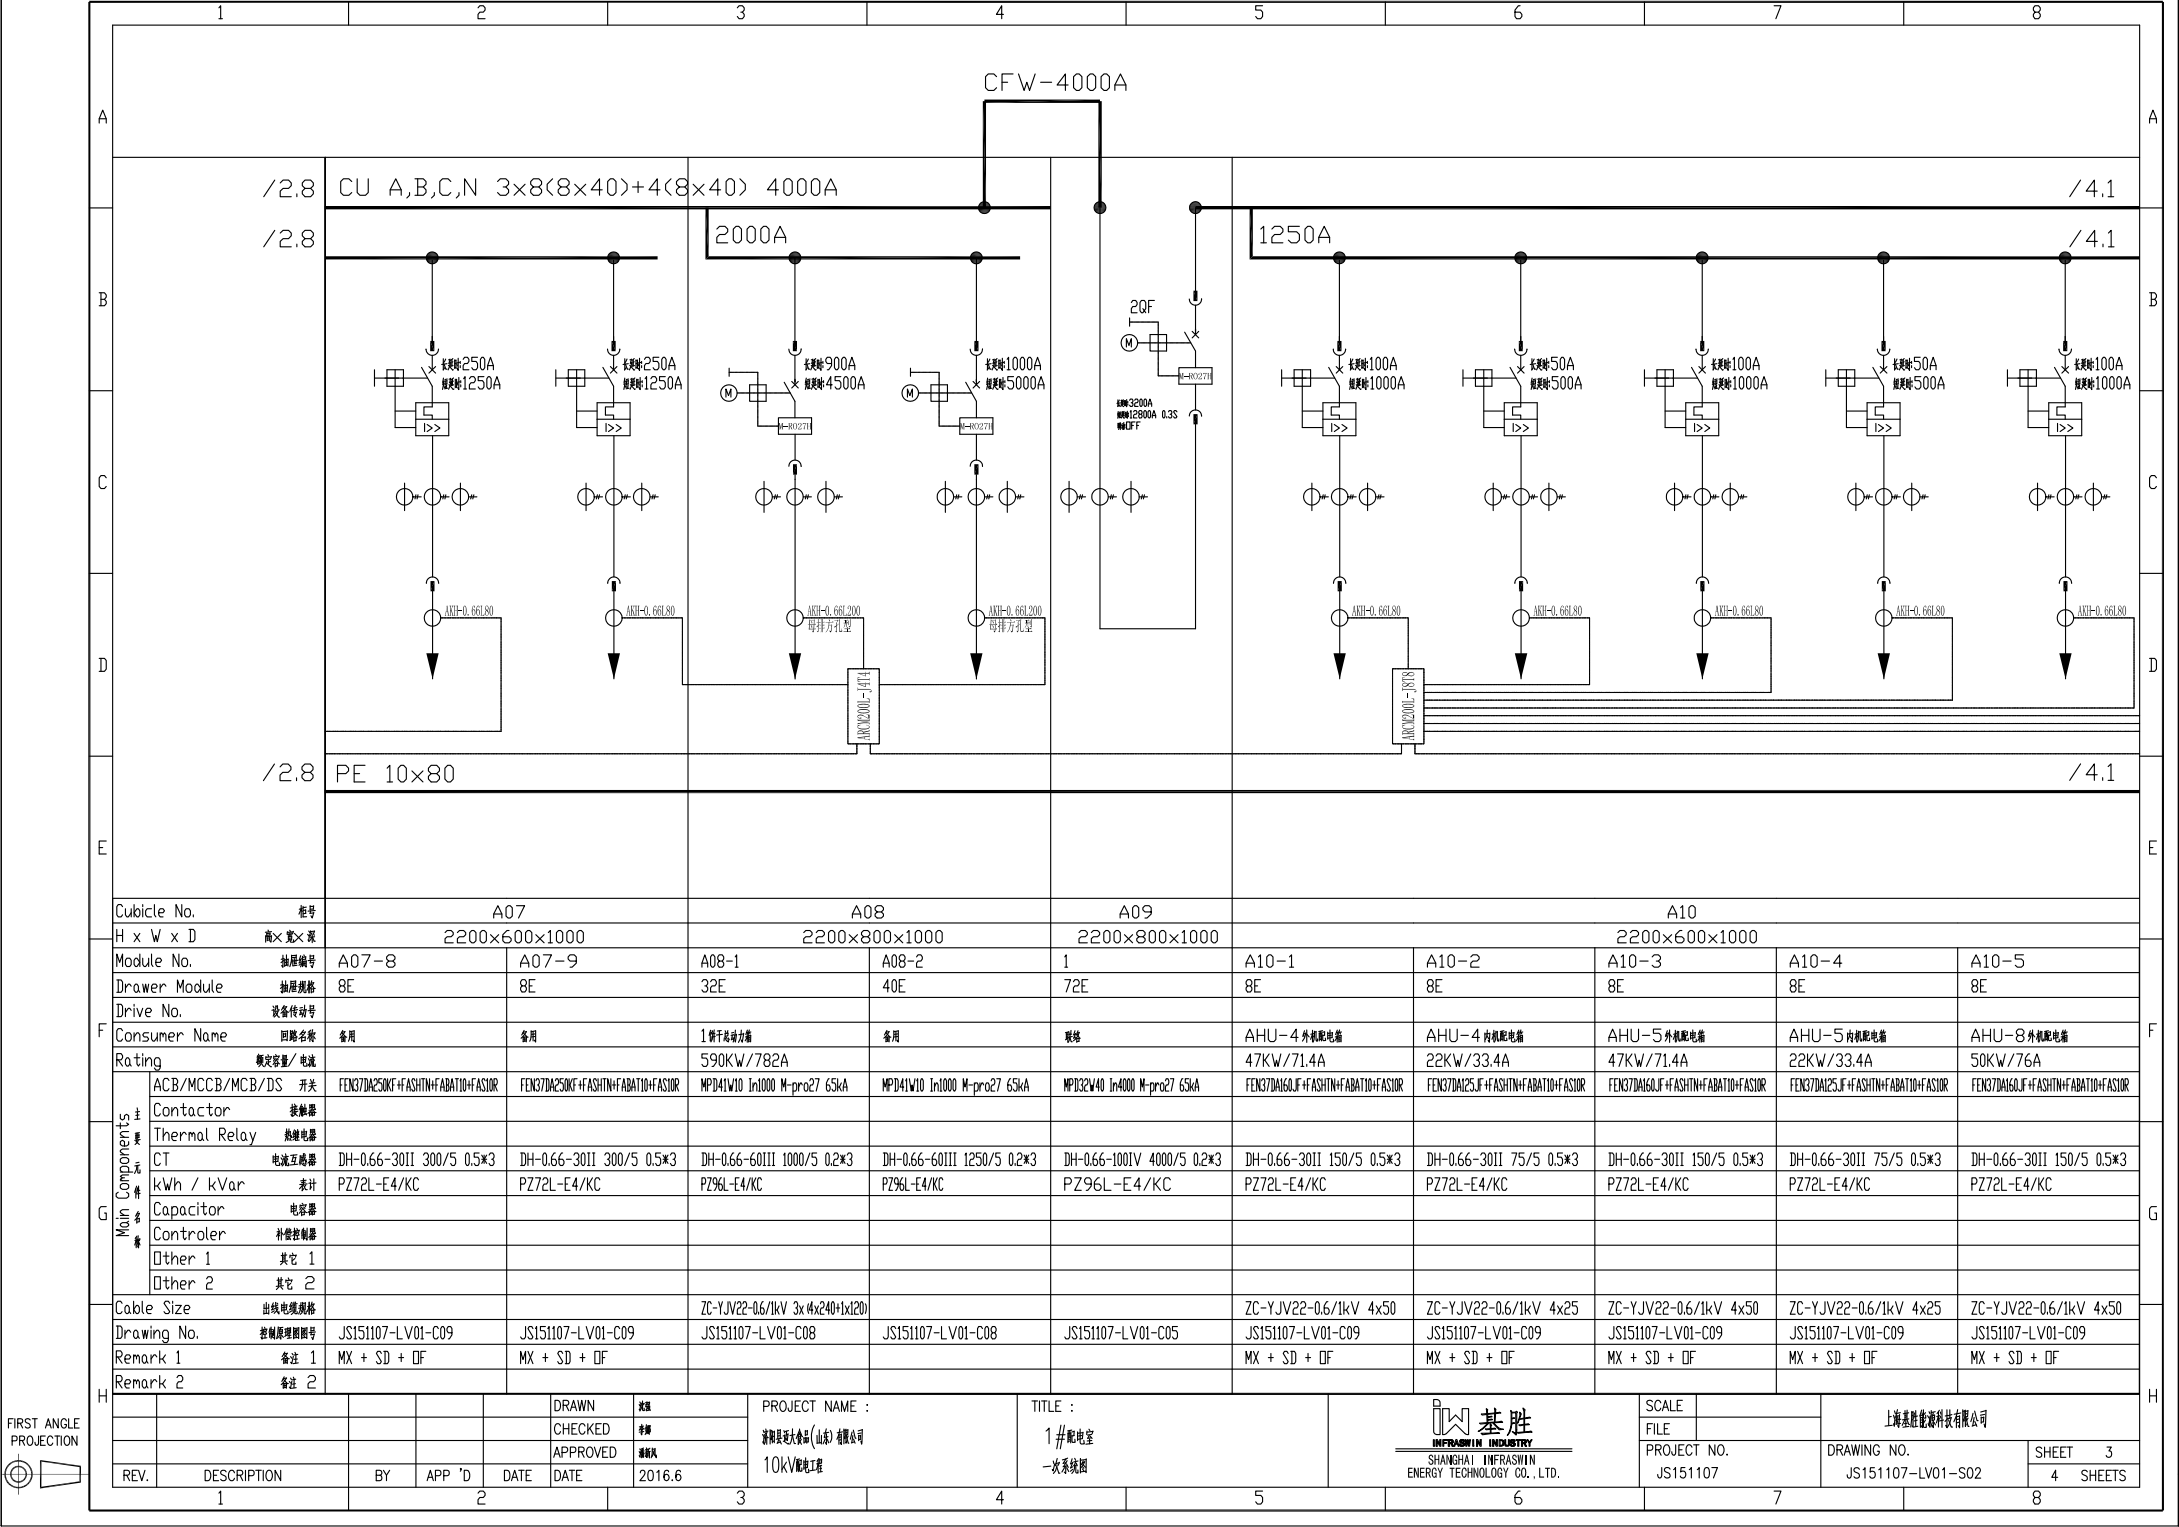



FIRST ANGLE
PROJECTION

1		2		3		4		5		6		7		8											
A																A									
		/1.8		CU A,B,C,N 3×8(8×40)+4(8×40) 4000A												/3.1									
B		/1.8														/3.1									
C																									
D																									
		/1.8														/3.1									
E		/1.8		PE 10×80												/3.1									
F		Cubicle No.		柜号		A06						A07													
		H x W x D		高×宽×深		2200×600×1000						2200×600×1000													
		Module No.		抽屉编号		A06-3		A06-4		A06-5		A07-1		A07-2		A07-3		A07-4		A07-5		A07-6		A07-7	
		Drawer Module		抽屉规格		8E		8E		24E		8E		8E		8E		8E		8E		8E		8E	
		Drive No.		设备传动号																					
		Consumer Name		回路名称		空压机会T1配电箱		备用		备用		升降平台配电箱		检修车间配电箱		冷藏库配电箱		AHU-2外机配电箱		AHU-2内机配电箱		AHU-3外机配电箱		AHU-3内机配电箱	
		Rating		额定容量/电流		66KW/100.3A						25KW/47.5A		30KW/57A		30KW/57A		123KW/186.9A		55KW/83.6A		38KW/57.7A		55KW/83.6A	
Main Components 主要元件名称		ACB/MCCB/MCB/DS		开关		FEN37DA250KF+FSHTN+FABATID+FASUR		FEN37DA250KF+FSHTN+FABATID+FASUR		FEN37DA630NF+FSHTN+FABATID+FASUR		FEN37DA125JF+FSHTN+FABATID+FASUR		FEN37DA125JF+FSHTN+FABATID+FASUR		FEN37DA125JF+FSHTN+FABATID+FASUR		FEN37DA250KF+FSHTN+FABATID+FASUR		FEN37DA160JF+FSHTN+FABATID+FASUR		FEN37DA125JF+FSHTN+FABATID+FASUR		FEN37DA160JF+FSHTN+FABATID+FASUR	
		Contactor		接触器																					
		Thermal Relay		热继电器																					
		CT		电流互感器		DH-0.66-30II 150/5 0.5*3		DH-0.66-30II 300/5 0.5*3		DH-0.66-40II 750/5 0.5*3		DH-0.66-30II 75/5 0.5*3		DH-0.66-30II 100/5 0.5*3		DH-0.66-30II 100/5 0.5*3		DH-0.66-30II 250/5 0.5*3		DH-0.66-30II 150/5 0.5*3		DH-0.66-30II 100/5 0.5*3		DH-0.66-30II 150/5 0.5*3	
		kWh / kVar		表计		PZ72L-E4/KC		PZ72L-E4/KC		PZ72L-E4/KC		PZ72L-E4/KC		PZ72L-E4/KC		PZ72L-E4/KC		PZ72L-E4/KC		PZ72L-E4/KC		PZ72L-E4/KC		PZ72L-E4/KC	
		Capacitor		电容器																					
		Controler		补偿控制器																					
		Other 1		其它 1																					
Other 2		其它 2																							
		Cable Size		出线电缆规格		ZC-YJV22-0.6/1kV 4x50						ZC-YJV22-0.6/1kV 4x25		ZC-YJV22-0.6/1kV 4x35		ZC-YJV22-0.6/1kV 4x35		ZC-YJV22-0.6/1kV 4x70		ZC-YJV22-0.6/1kV 4x50		ZC-YJV22-0.6/1kV 4x35		ZC-YJV22-0.6/1kV 4x50	
		Drawing No.		控制原理图编号		JS151107-LV01-C09		JS151107-LV01-C09		JS151107-LV01-C09		JS151107-LV01-C09		JS151107-LV01-C09		JS151107-LV01-C09		JS151107-LV01-C09		JS151107-LV01-C09		JS151107-LV01-C09		JS151107-LV01-C09	
		Remark 1		备注 1		MX + SD + DF		MX + SD + DF		MX + SD + DF		MX + SD + DF		MX + SD + DF		MX + SD + DF		MX + SD + DF		MX + SD + DF		MX + SD + DF		MX + SD + DF	
		Remark 2		备注 2																					
H																H									
						DRAWN		制图		PROJECT NAME :		TITLE :		基胜		SCALE		上海基胜能源科技有限公司							
						CHECKED		审核		济阳县远太食品(山东)有限公司		1#配电室		INFRAWIN INDUSTRY		FILE									
						APPROVED		审核人		10KV配电工程		一次系统图		SHANGHAI INFRASWIN		PROJECT NO.		DRAWING NO.		SHEET		2			
		REV.		DESCRIPTION		DATE		2016.6						ENERGY TECHNOLOGY CO., LTD.		JS151107		JS151107-LV01-S02		4		SHEETS			
		1				2		3		4		5		6		7		8							



SHANGHAI INFRASWIN ENERGY TECHNOLOGY CO., LTD.

SCALE

FILE

PROJECT NO. JS151107

DRAWING NO. JS151107-LV01-S02

SHEET 2 4 SHEETS

