


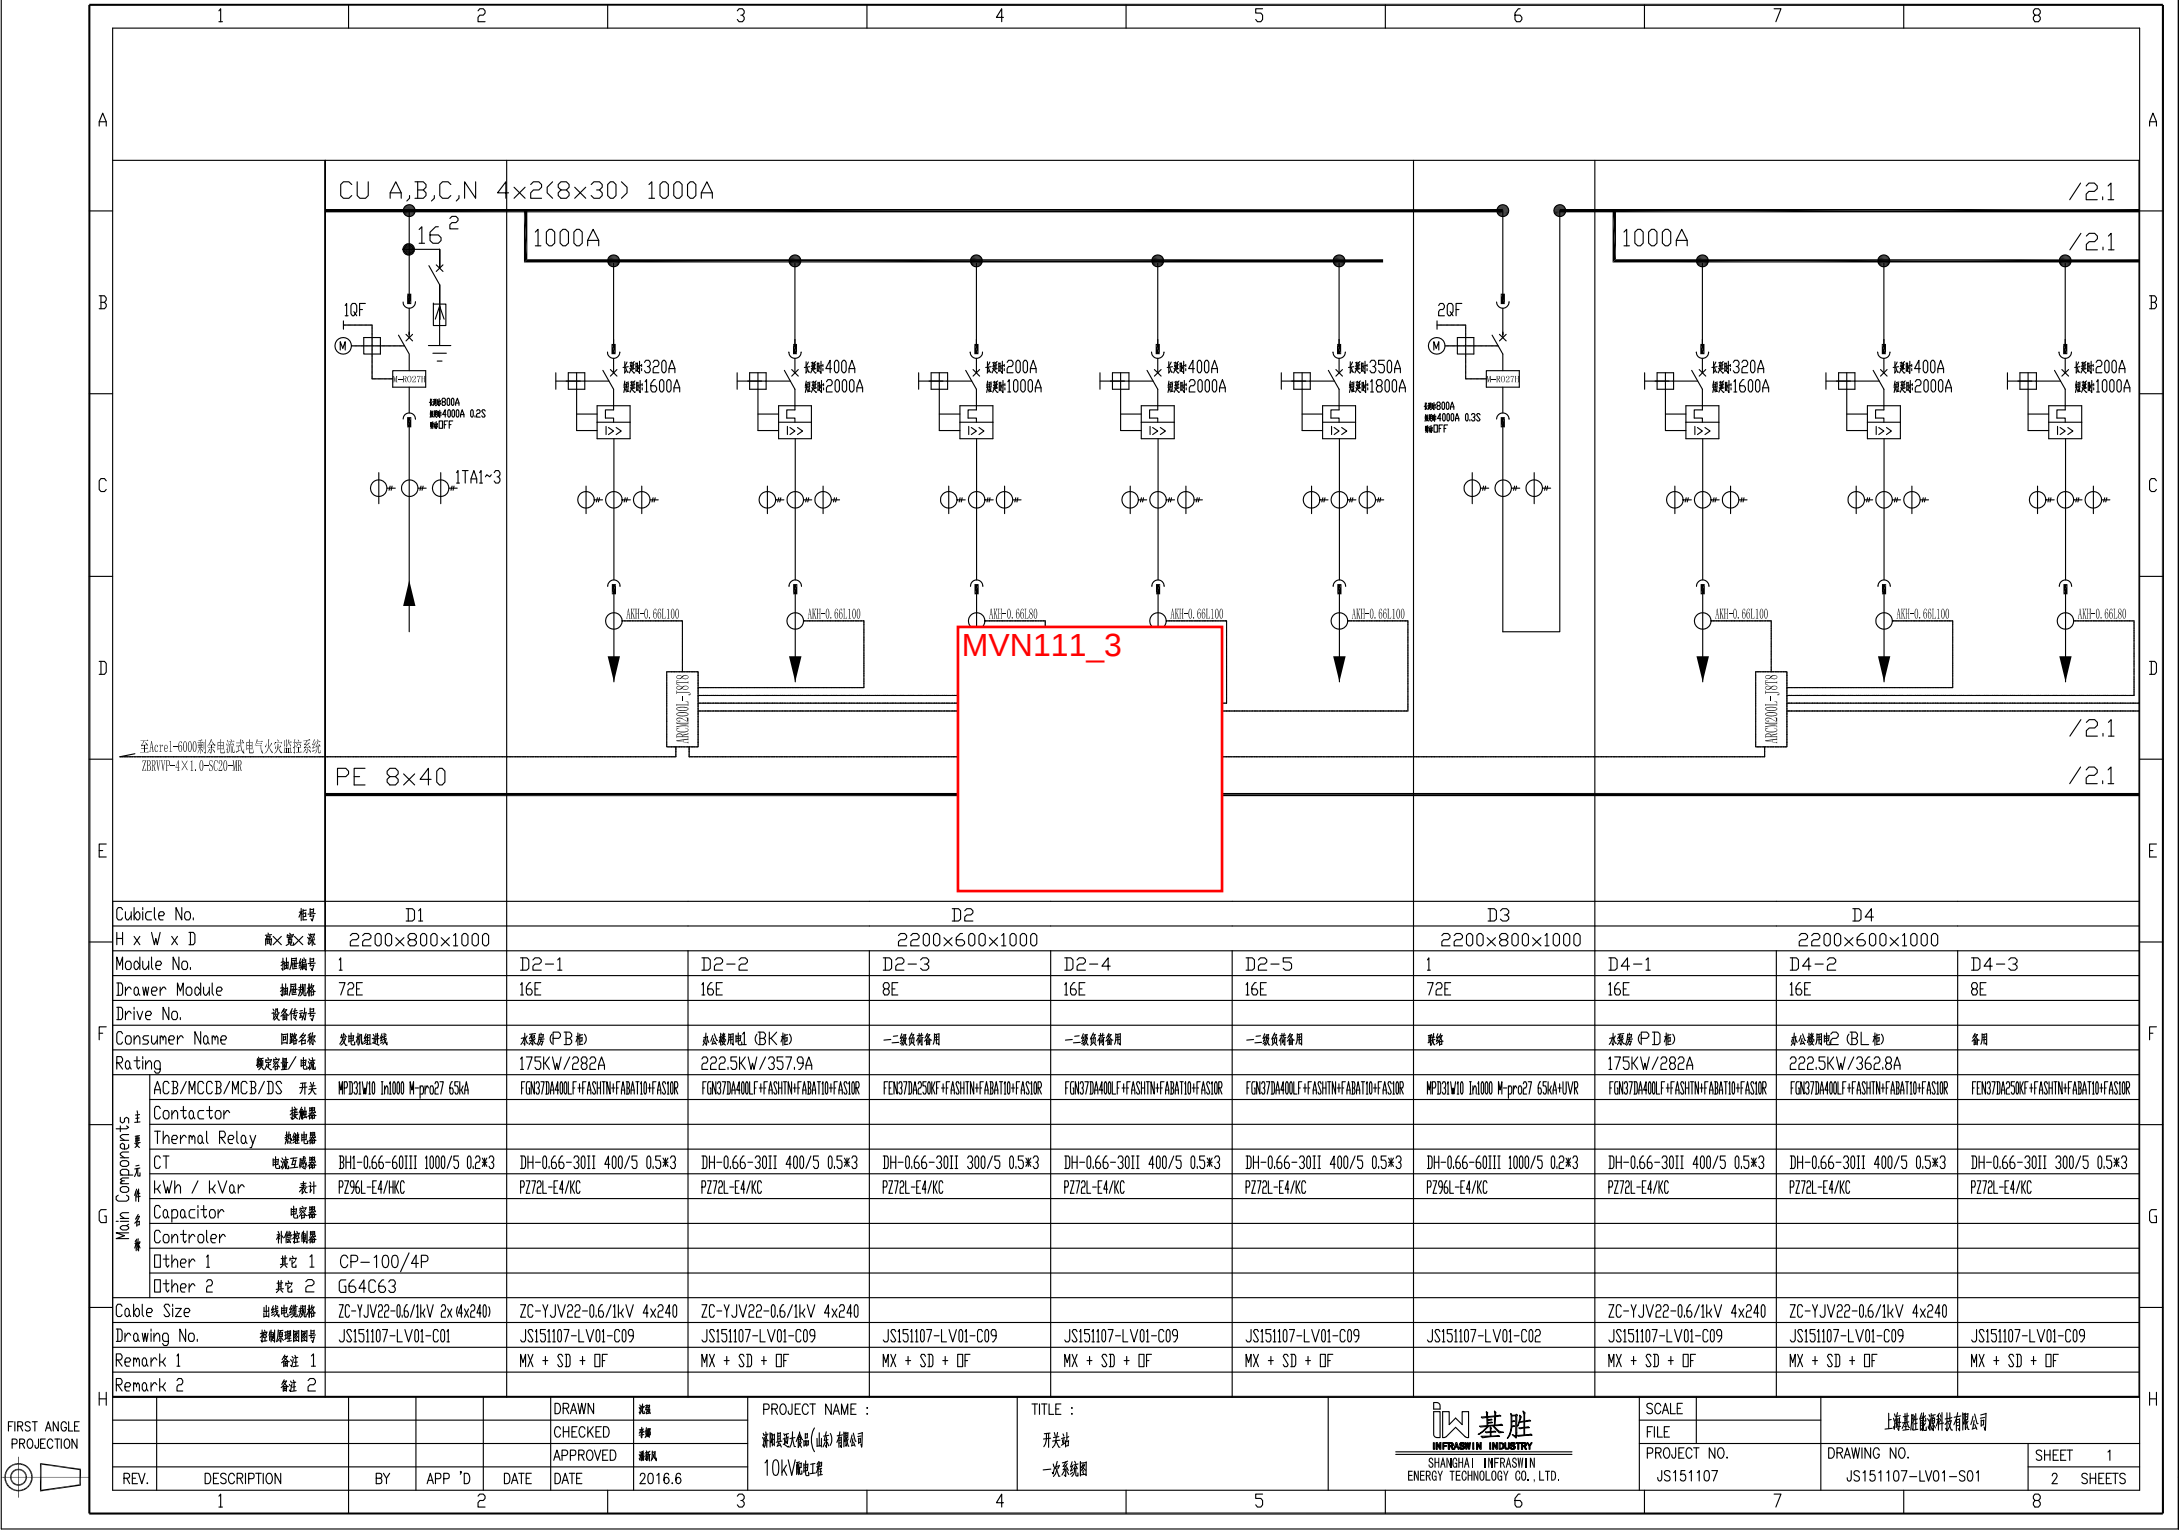



Cubicle No.			柜号	D1		D2					D3		D4		
H x W x D			高×宽×深	2200×800×1000		2200×600×1000					2200×800×1000		2200×600×1000		
Module No.			抽屉编号	1	D2-1	D2-2	D2-3	D2-4	D2-5	1	D4-1	D4-2	D4-3		
Drawer Module			抽屉规格	72E	16E	16E	8E	16E	16E	72E	16E	16E	8E		
Drive No.			设备传动号												
Consumer Name			回路名称	发电机进线	水泵房 (PB柜)	办公楼用电1 (BK柜)	一二级负荷备用	一二级负荷备用	一二级负荷备用	联络	水泵房 (PD柜)	办公楼用电2 (BL柜)	备用		
Rating			额定容量/ 电流		175KW/282A	222.5KW/357.9A					175KW/282A	222.5KW/362.8A			
Main Components 主 要 元 件	ACB/MCCB/MCB/DS	开关	MPD31W10 1x1000 M-pro27 65kA	F0K37DA400LF+ASHTN+ABAT10+ASUR	F0K37DA400LF+ASHTN+ABAT10+ASUR	F0K37DA250KF+ASHTN+ABAT10+ASUR	F0K37DA400LF+ASHTN+ABAT10+ASUR	F0K37DA400LF+ASHTN+ABAT10+ASUR	F0K37DA400LF+ASHTN+ABAT10+ASUR	MPD31W10 1x1000 M-pro27 65kA+UVR	F0K37DA400LF+ASHTN+ABAT10+ASUR	F0K37DA400LF+ASHTN+ABAT10+ASUR	F0K37DA250KF+ASHTN+ABAT10+ASUR		
	Contactors	接触器													
	Thermal Relay	热继电器													
	CT	电流互感器	BH1-0.66-60III 1000/5 0.2*3	DH-0.66-30II 400/5 0.5*3	DH-0.66-30II 400/5 0.5*3	DH-0.66-30II 300/5 0.5*3	DH-0.66-30II 400/5 0.5*3	DH-0.66-30II 400/5 0.5*3	DH-0.66-30II 400/5 0.5*3	DH-0.66-60III 1000/5 0.2*3	DH-0.66-30II 400/5 0.5*3	DH-0.66-30II 400/5 0.5*3	DH-0.66-30II 300/5 0.5*3		
	kWh / kVar	表计	PZ96L-E4/KC	PZ72L-E4/KC	PZ72L-E4/KC	PZ72L-E4/KC	PZ72L-E4/KC	PZ72L-E4/KC	PZ72L-E4/KC	PZ96L-E4/KC	PZ72L-E4/KC	PZ72L-E4/KC	PZ72L-E4/KC		
	Capacitor	电容器													
	Controler	补偿控制器													
	Other 1	其它 1	CP-100/4P												
Other 2	其它 2	G64C63													
Cable Size			出线电缆规格	ZC-YJV22-0.6/1kV 2x (4x240)	ZC-YJV22-0.6/1kV 4x240						ZC-YJV22-0.6/1kV 4x240	ZC-YJV22-0.6/1kV 4x240			
Drawing No.			控制原理图编号	JS151107-LV01-C01	JS151107-LV01-C09	JS151107-LV01-C09	JS151107-LV01-C09	JS151107-LV01-C09	JS151107-LV01-C09	JS151107-LV01-C02	JS151107-LV01-C09	JS151107-LV01-C09	JS151107-LV01-C09		
Remark 1			备注 1	MX + SD + OF	MX + SD + OF	MX + SD + OF	MX + SD + OF	MX + SD + OF	MX + SD + OF		MX + SD + OF	MX + SD + OF	MX + SD + OF		
Remark 2			备注 2												


REV.		DESCRIPTION		BY	APP 'D	DATE	DRAWN		CHECKED		APPROVED		DATE		PROJECT NAME :		TITLE :		SCALE		FILE		PROJECT NO.		DRAWING NO.		SHEET	
1													2016.6		10KV配电工程		开关站 一次系统图						JS151107		JS151107-LV01-S01		2	




SHANGHAI INFRAWIN ENERGY TECHNOLOGY CO., LTD.		上海基胜能源科技有限公司	
PROJECT NO.		DRAWING NO.	
JS151107		JS151107-LV01-S01	
SHEET		1	
2		SHEETS	

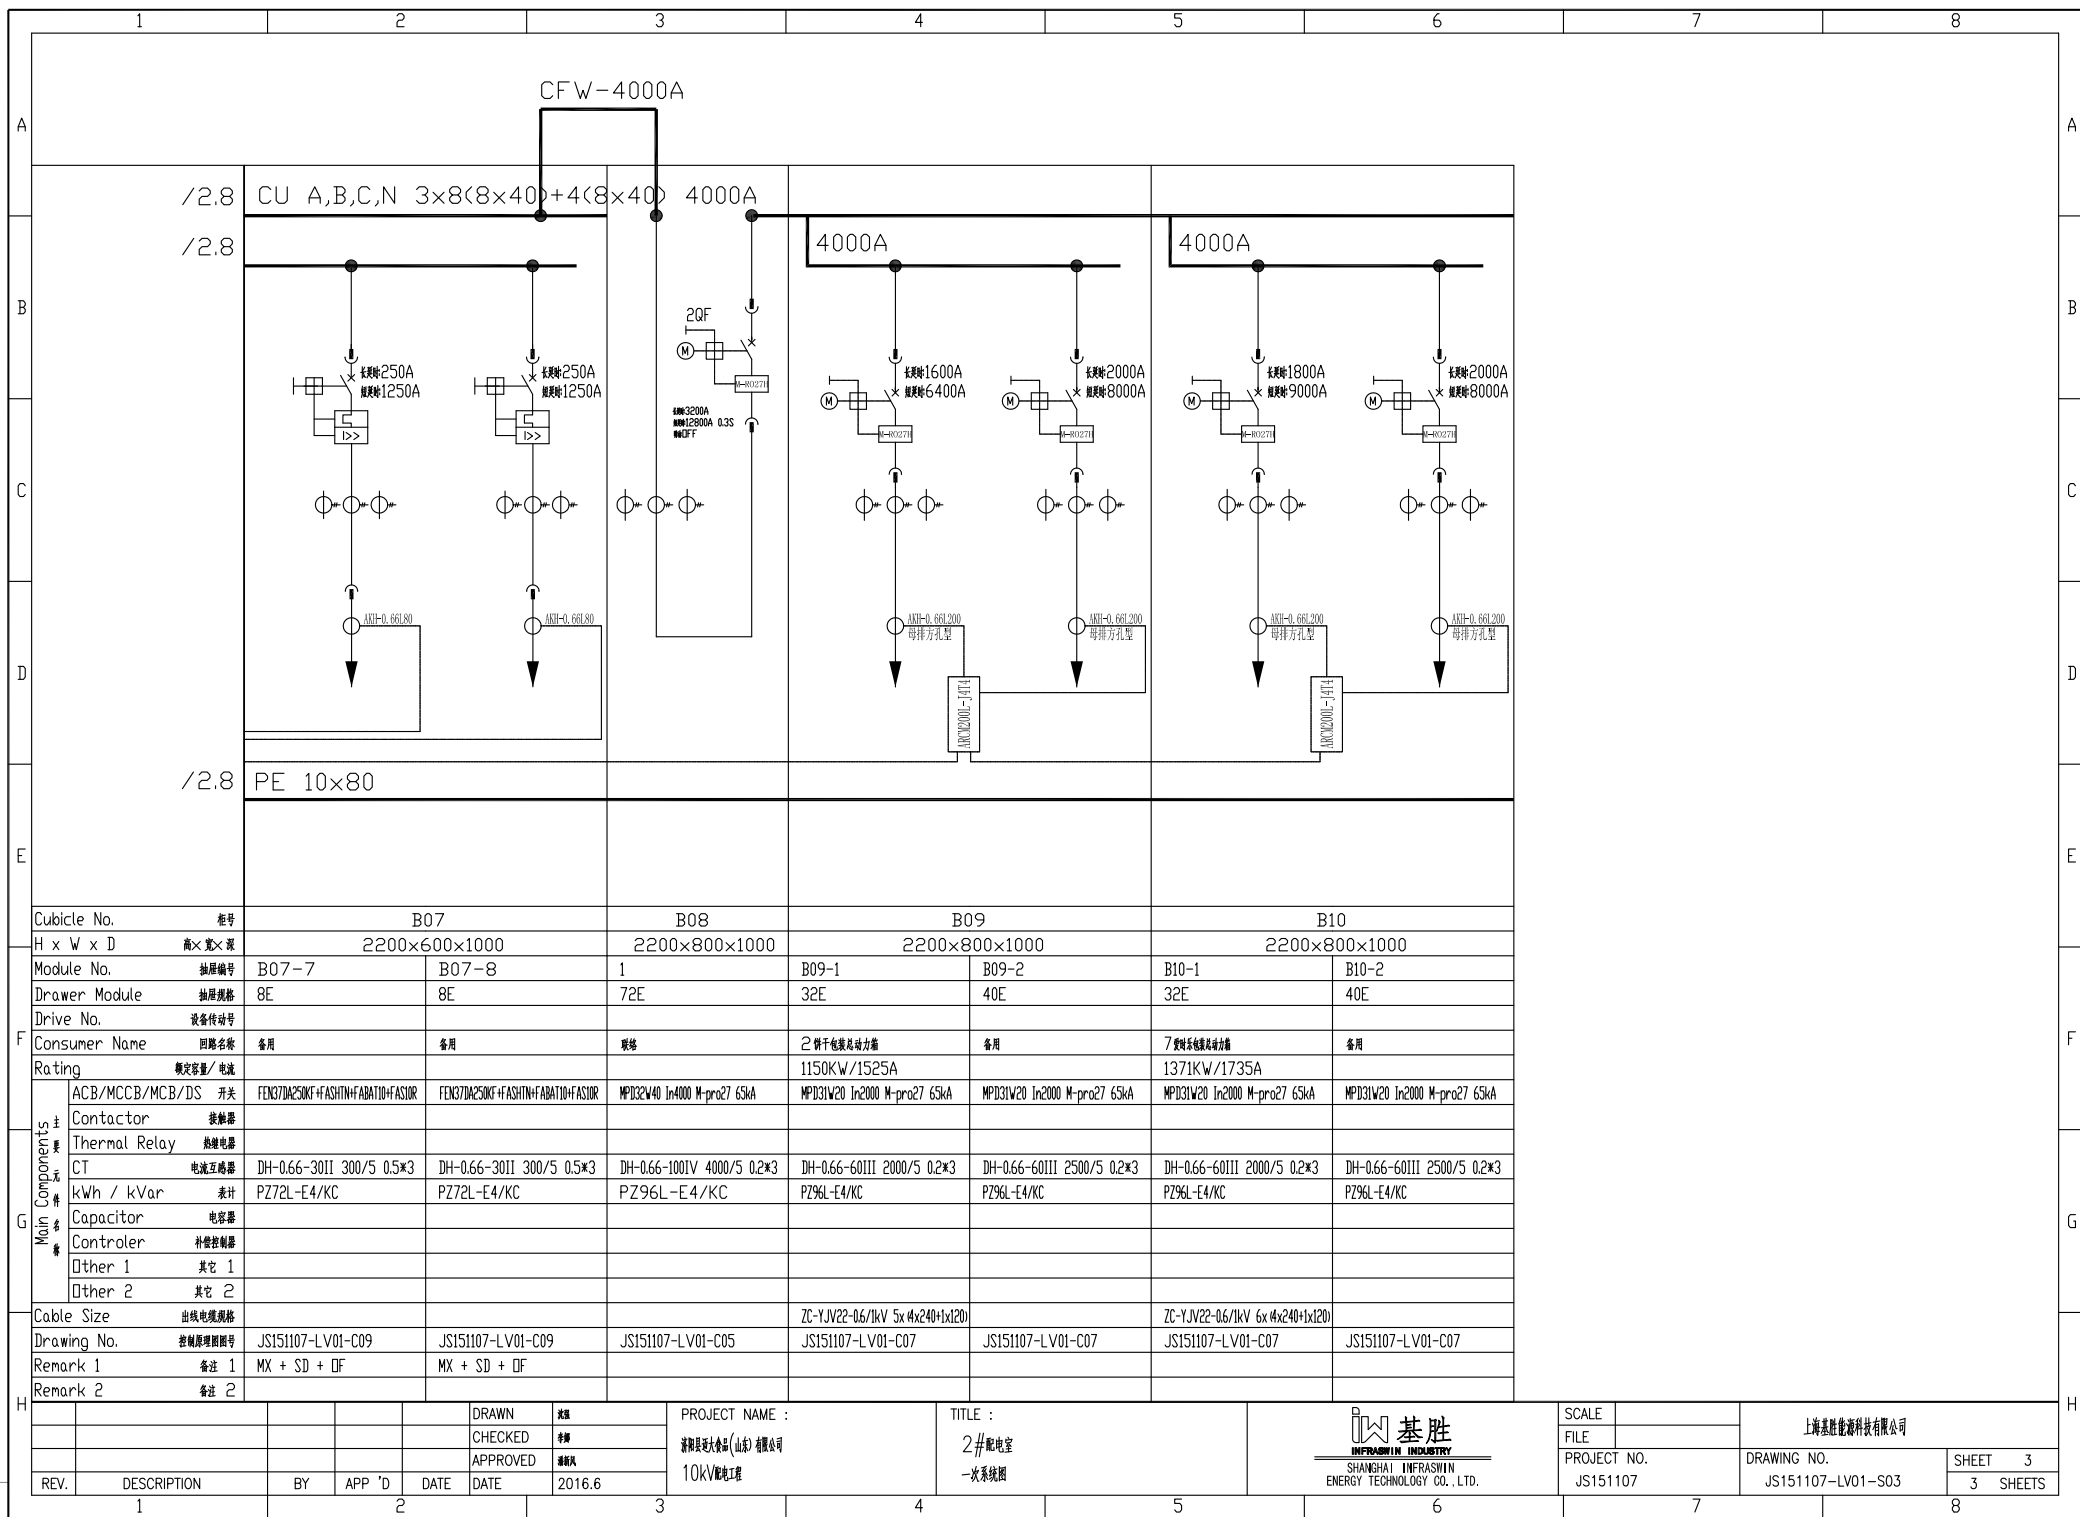

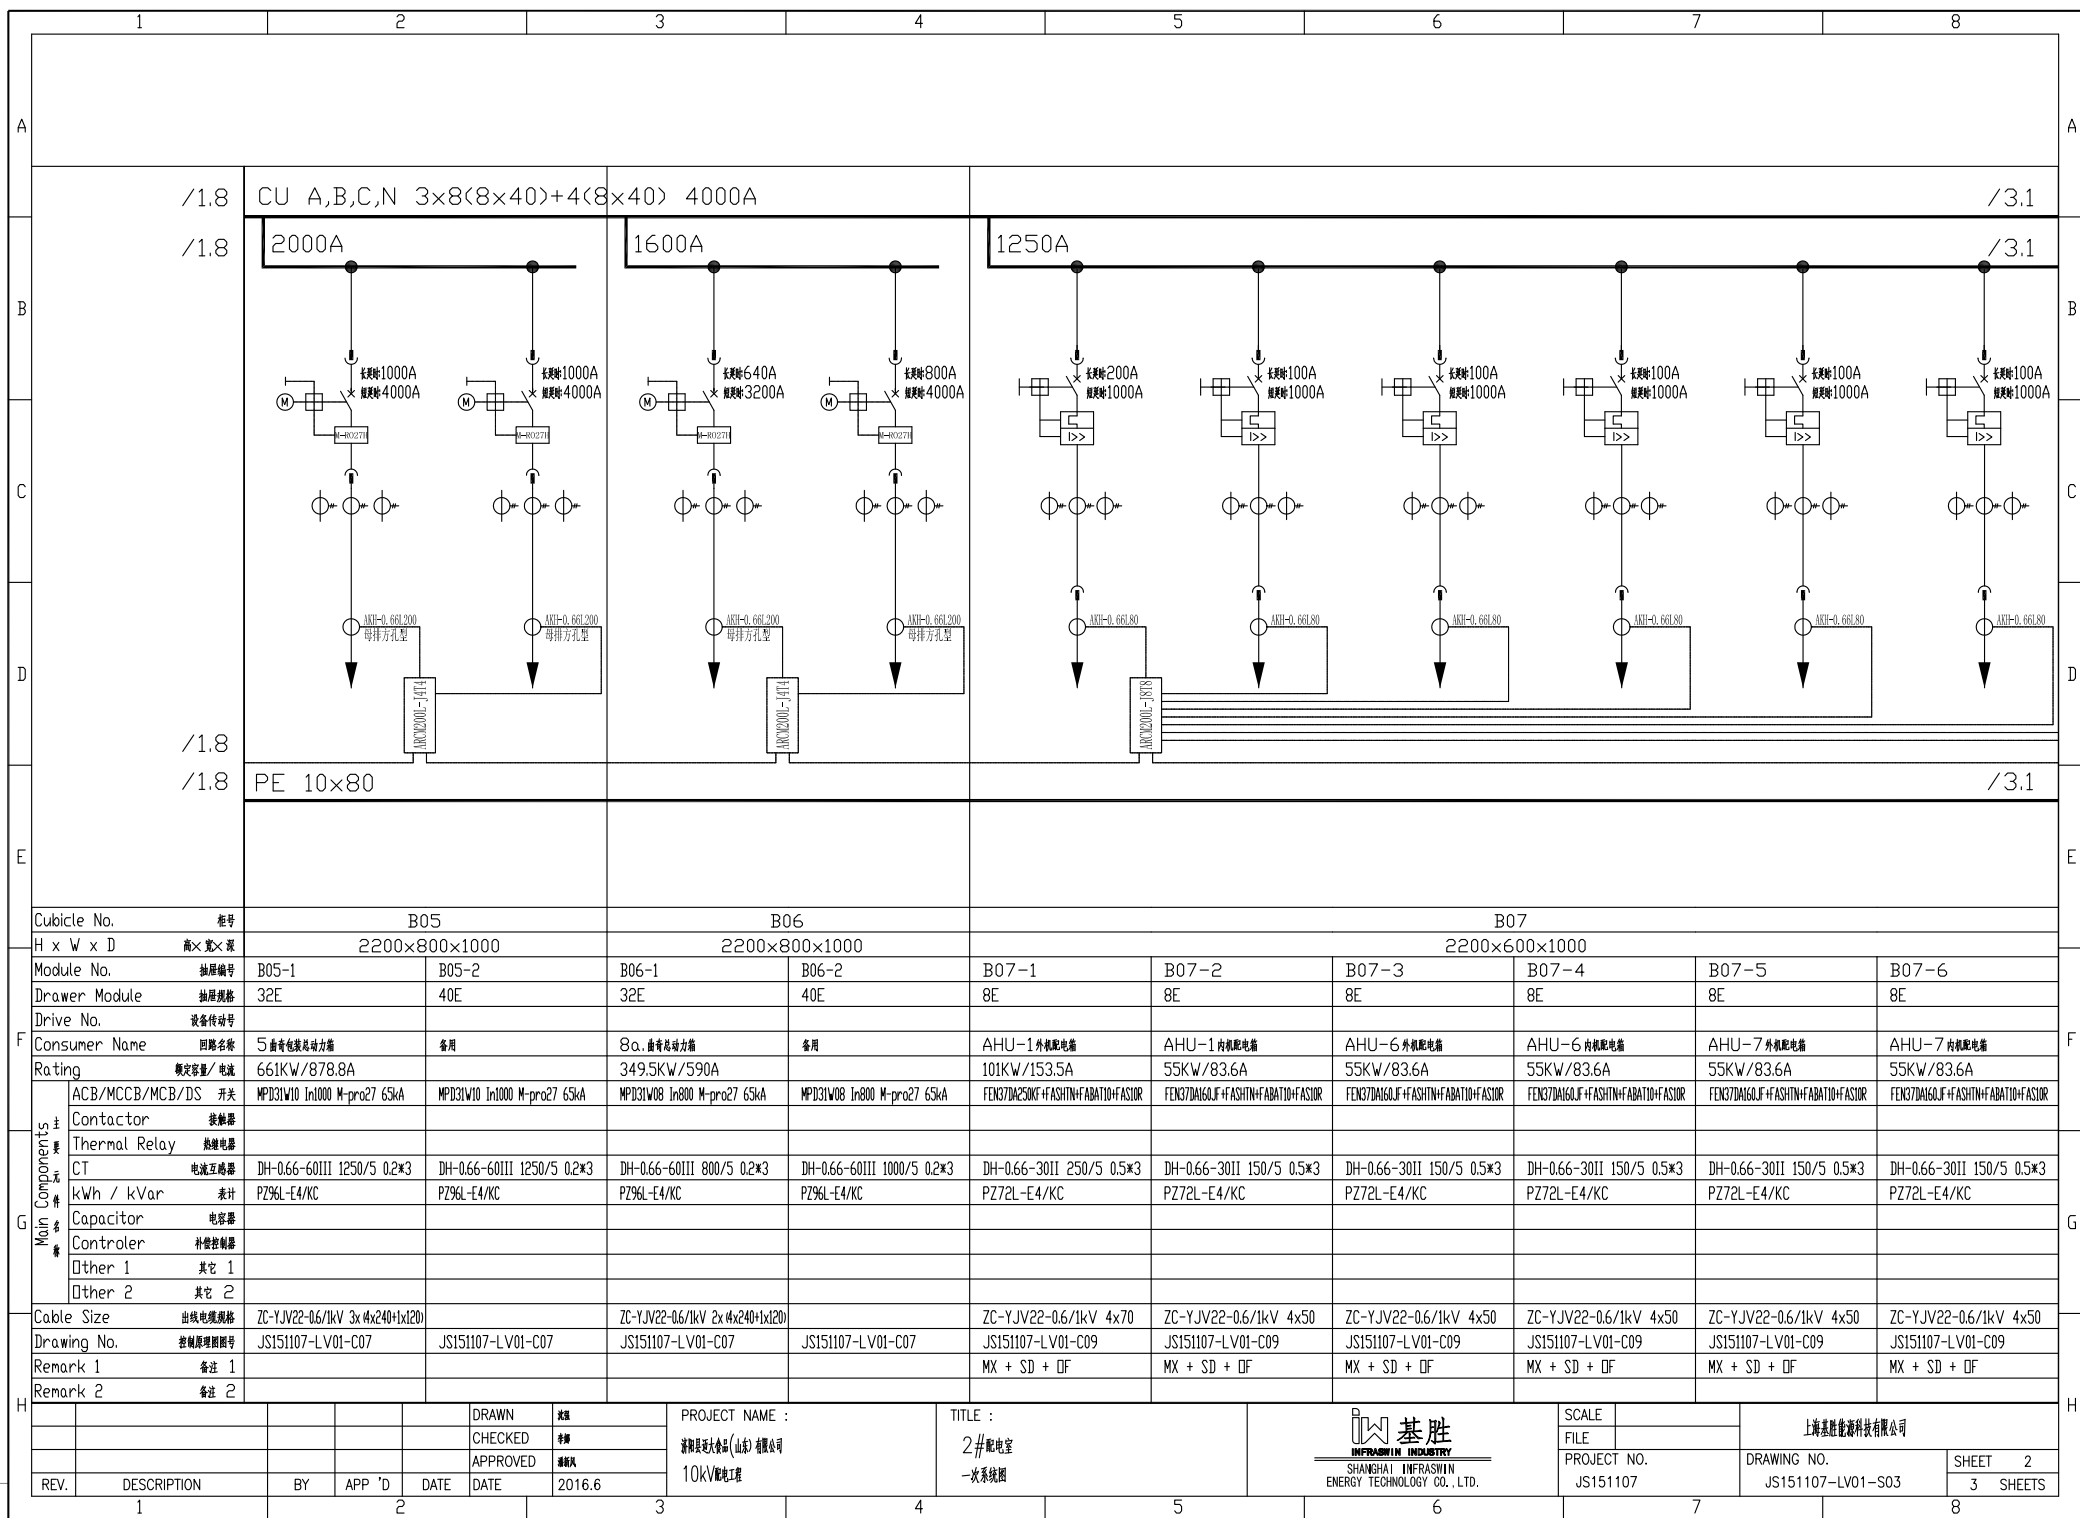

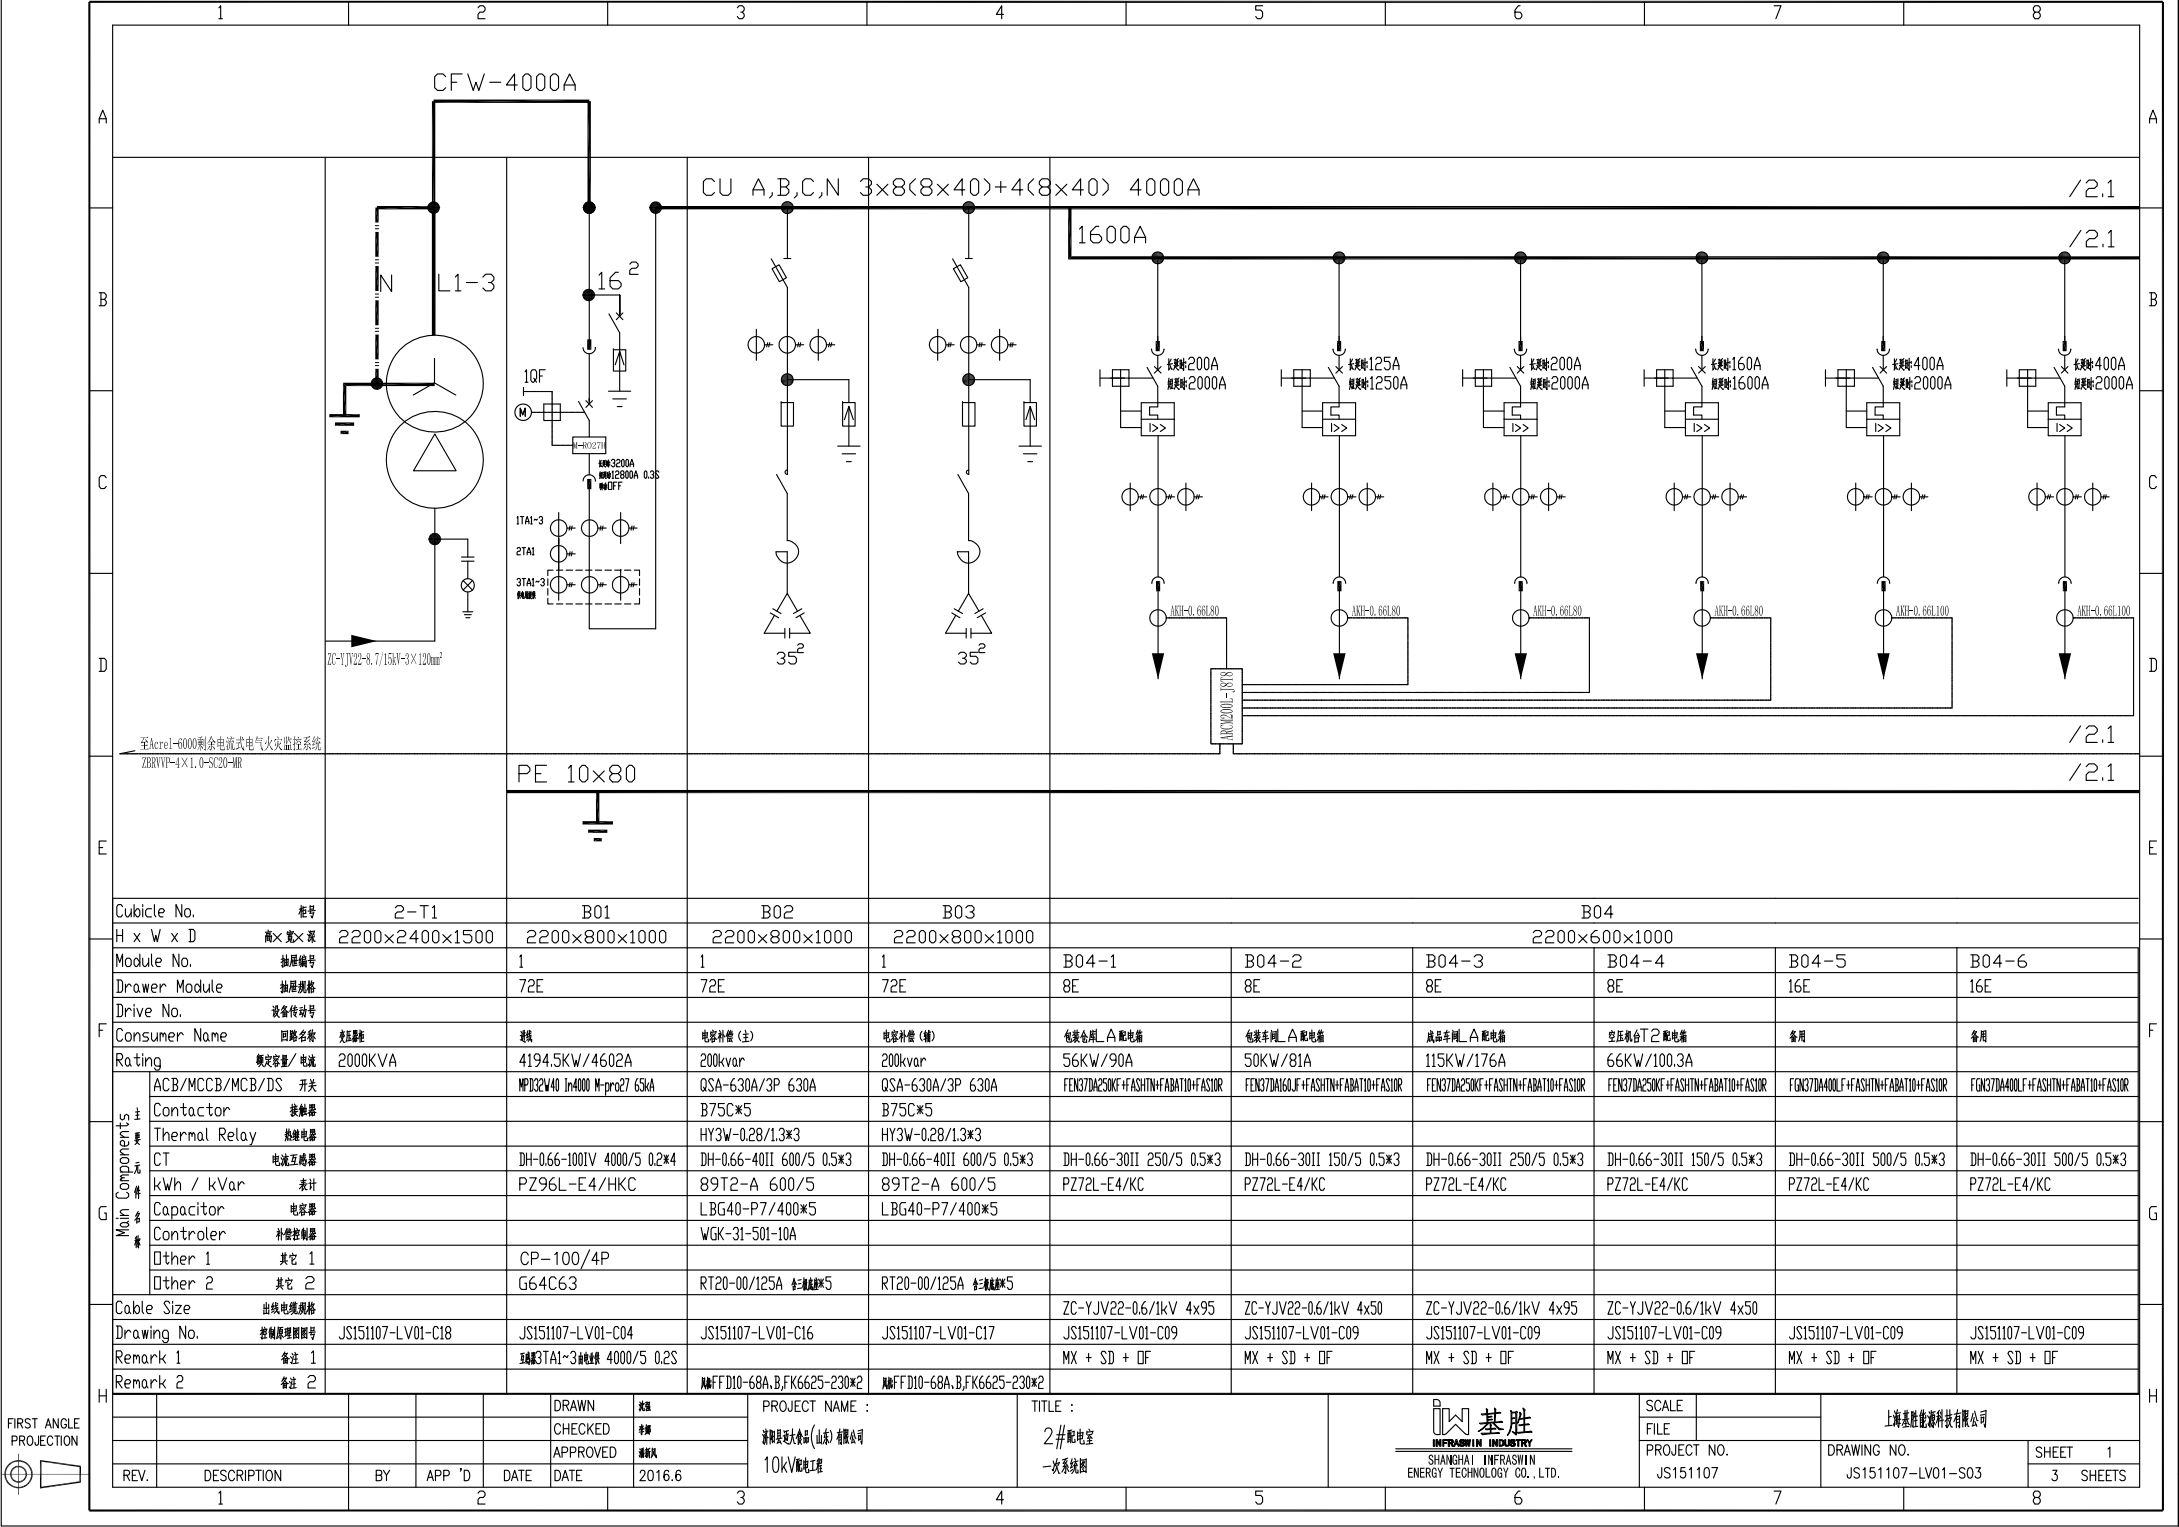

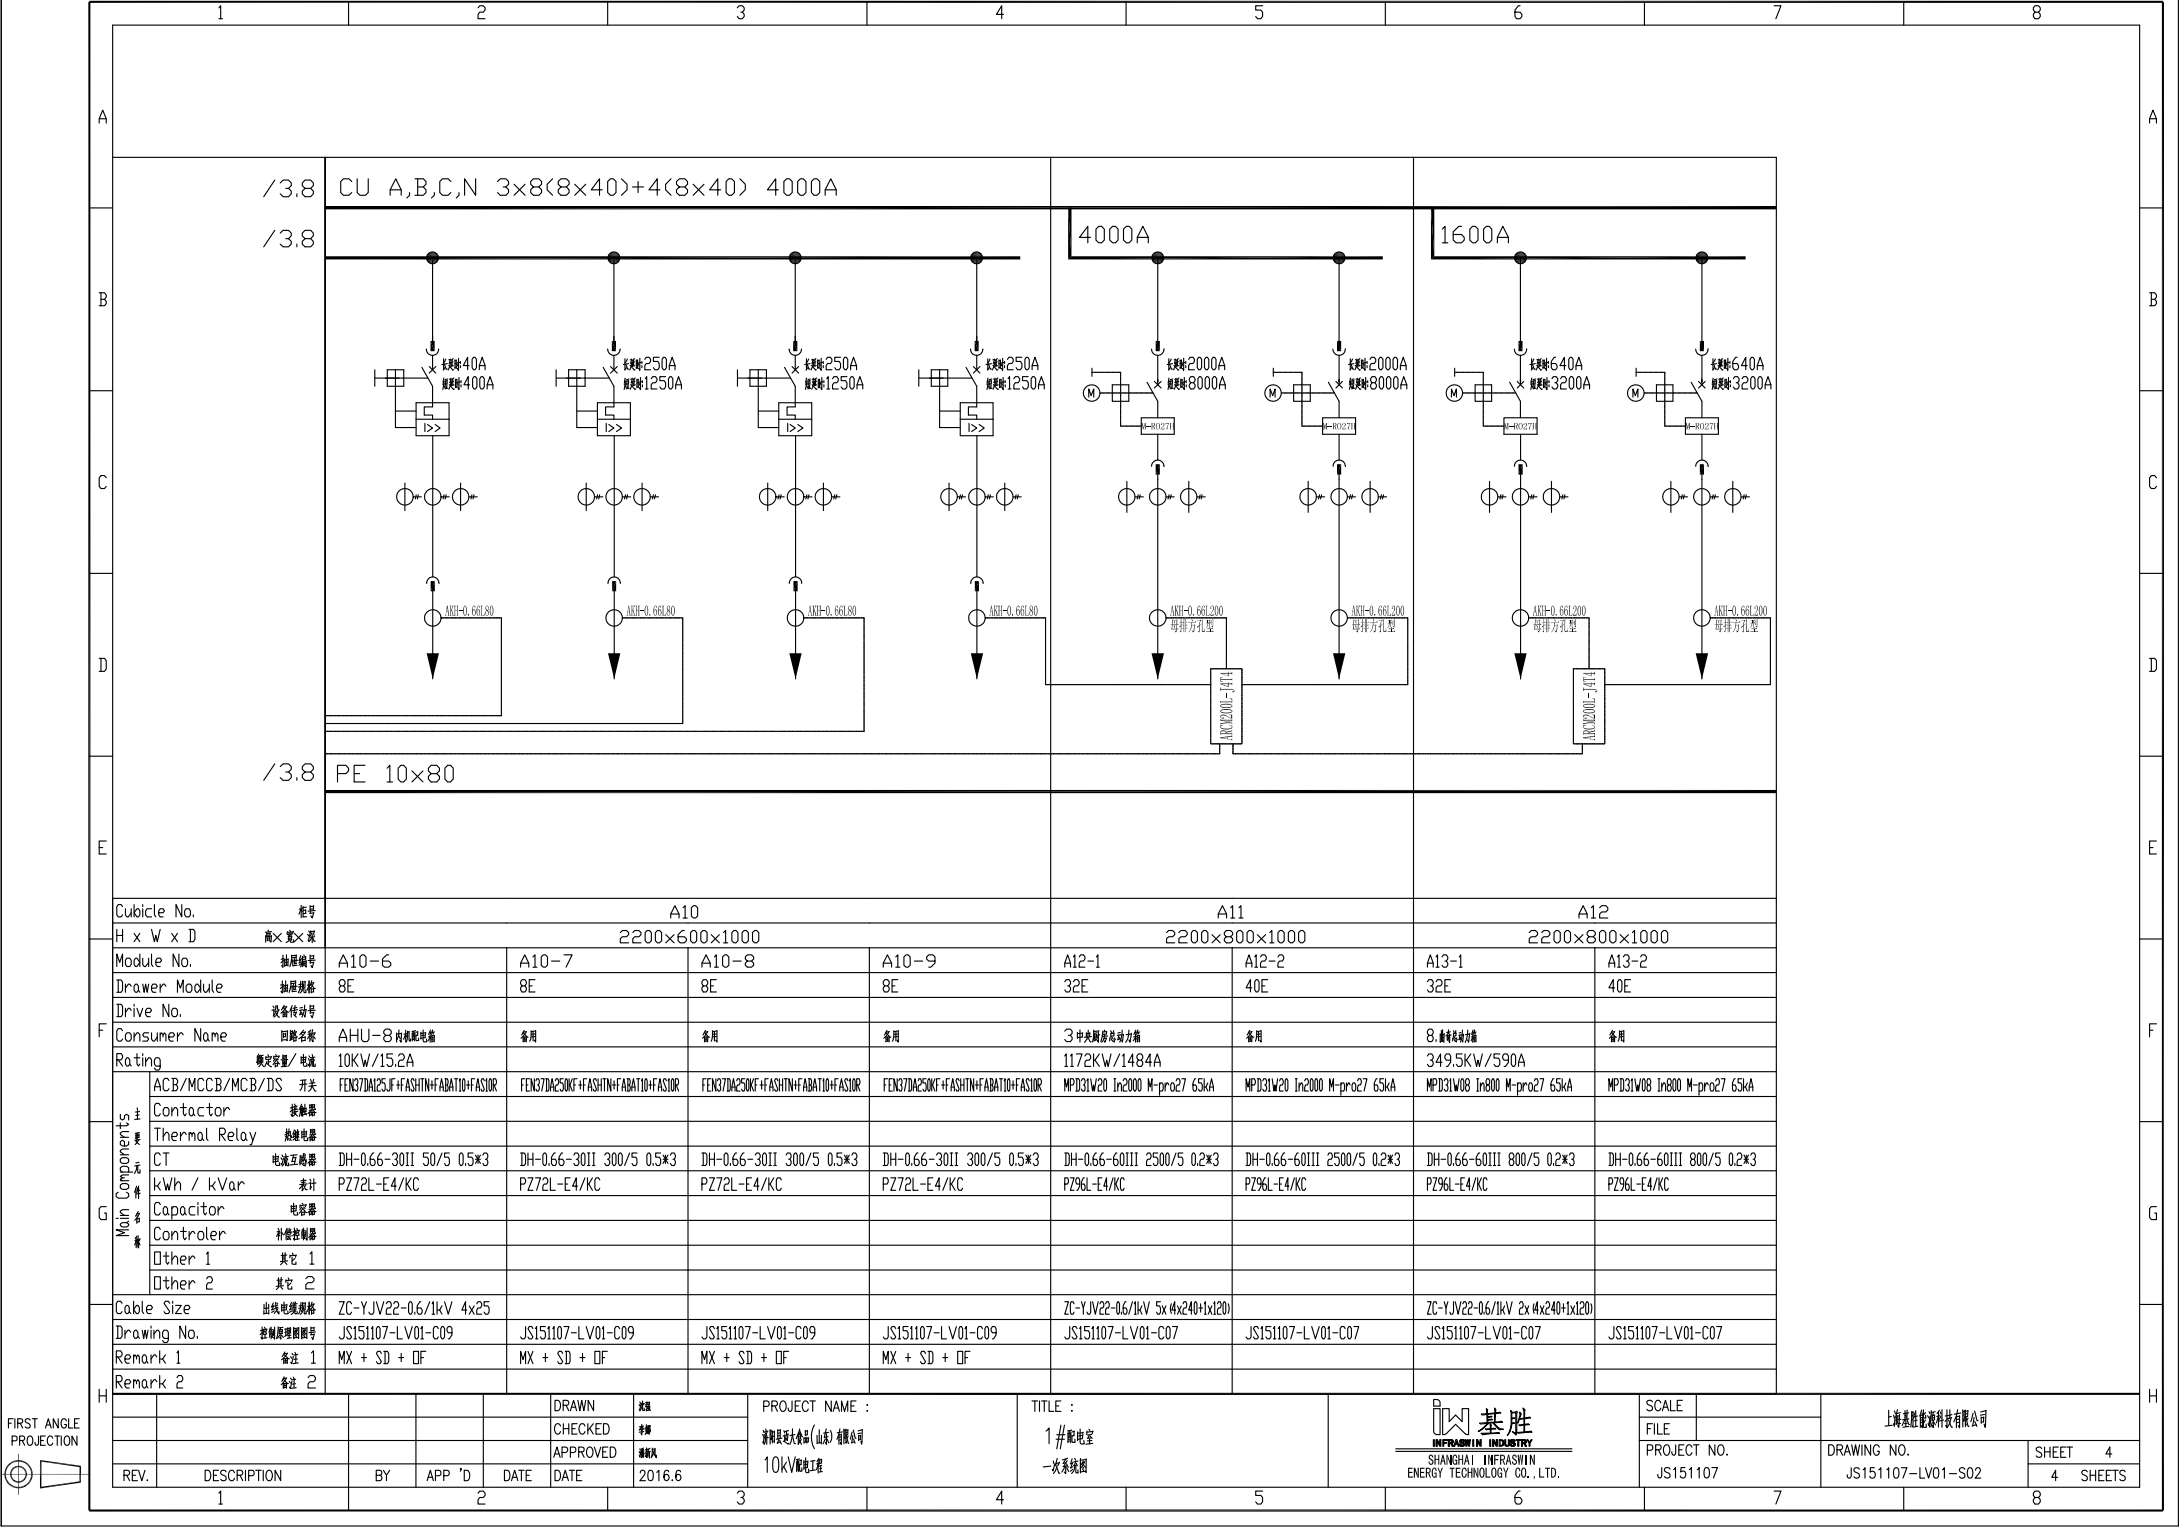



上海基胜能源科技有限公司

DRAWING NO. JS151107-LV01-S02

SHEET 4

4 SHEETS

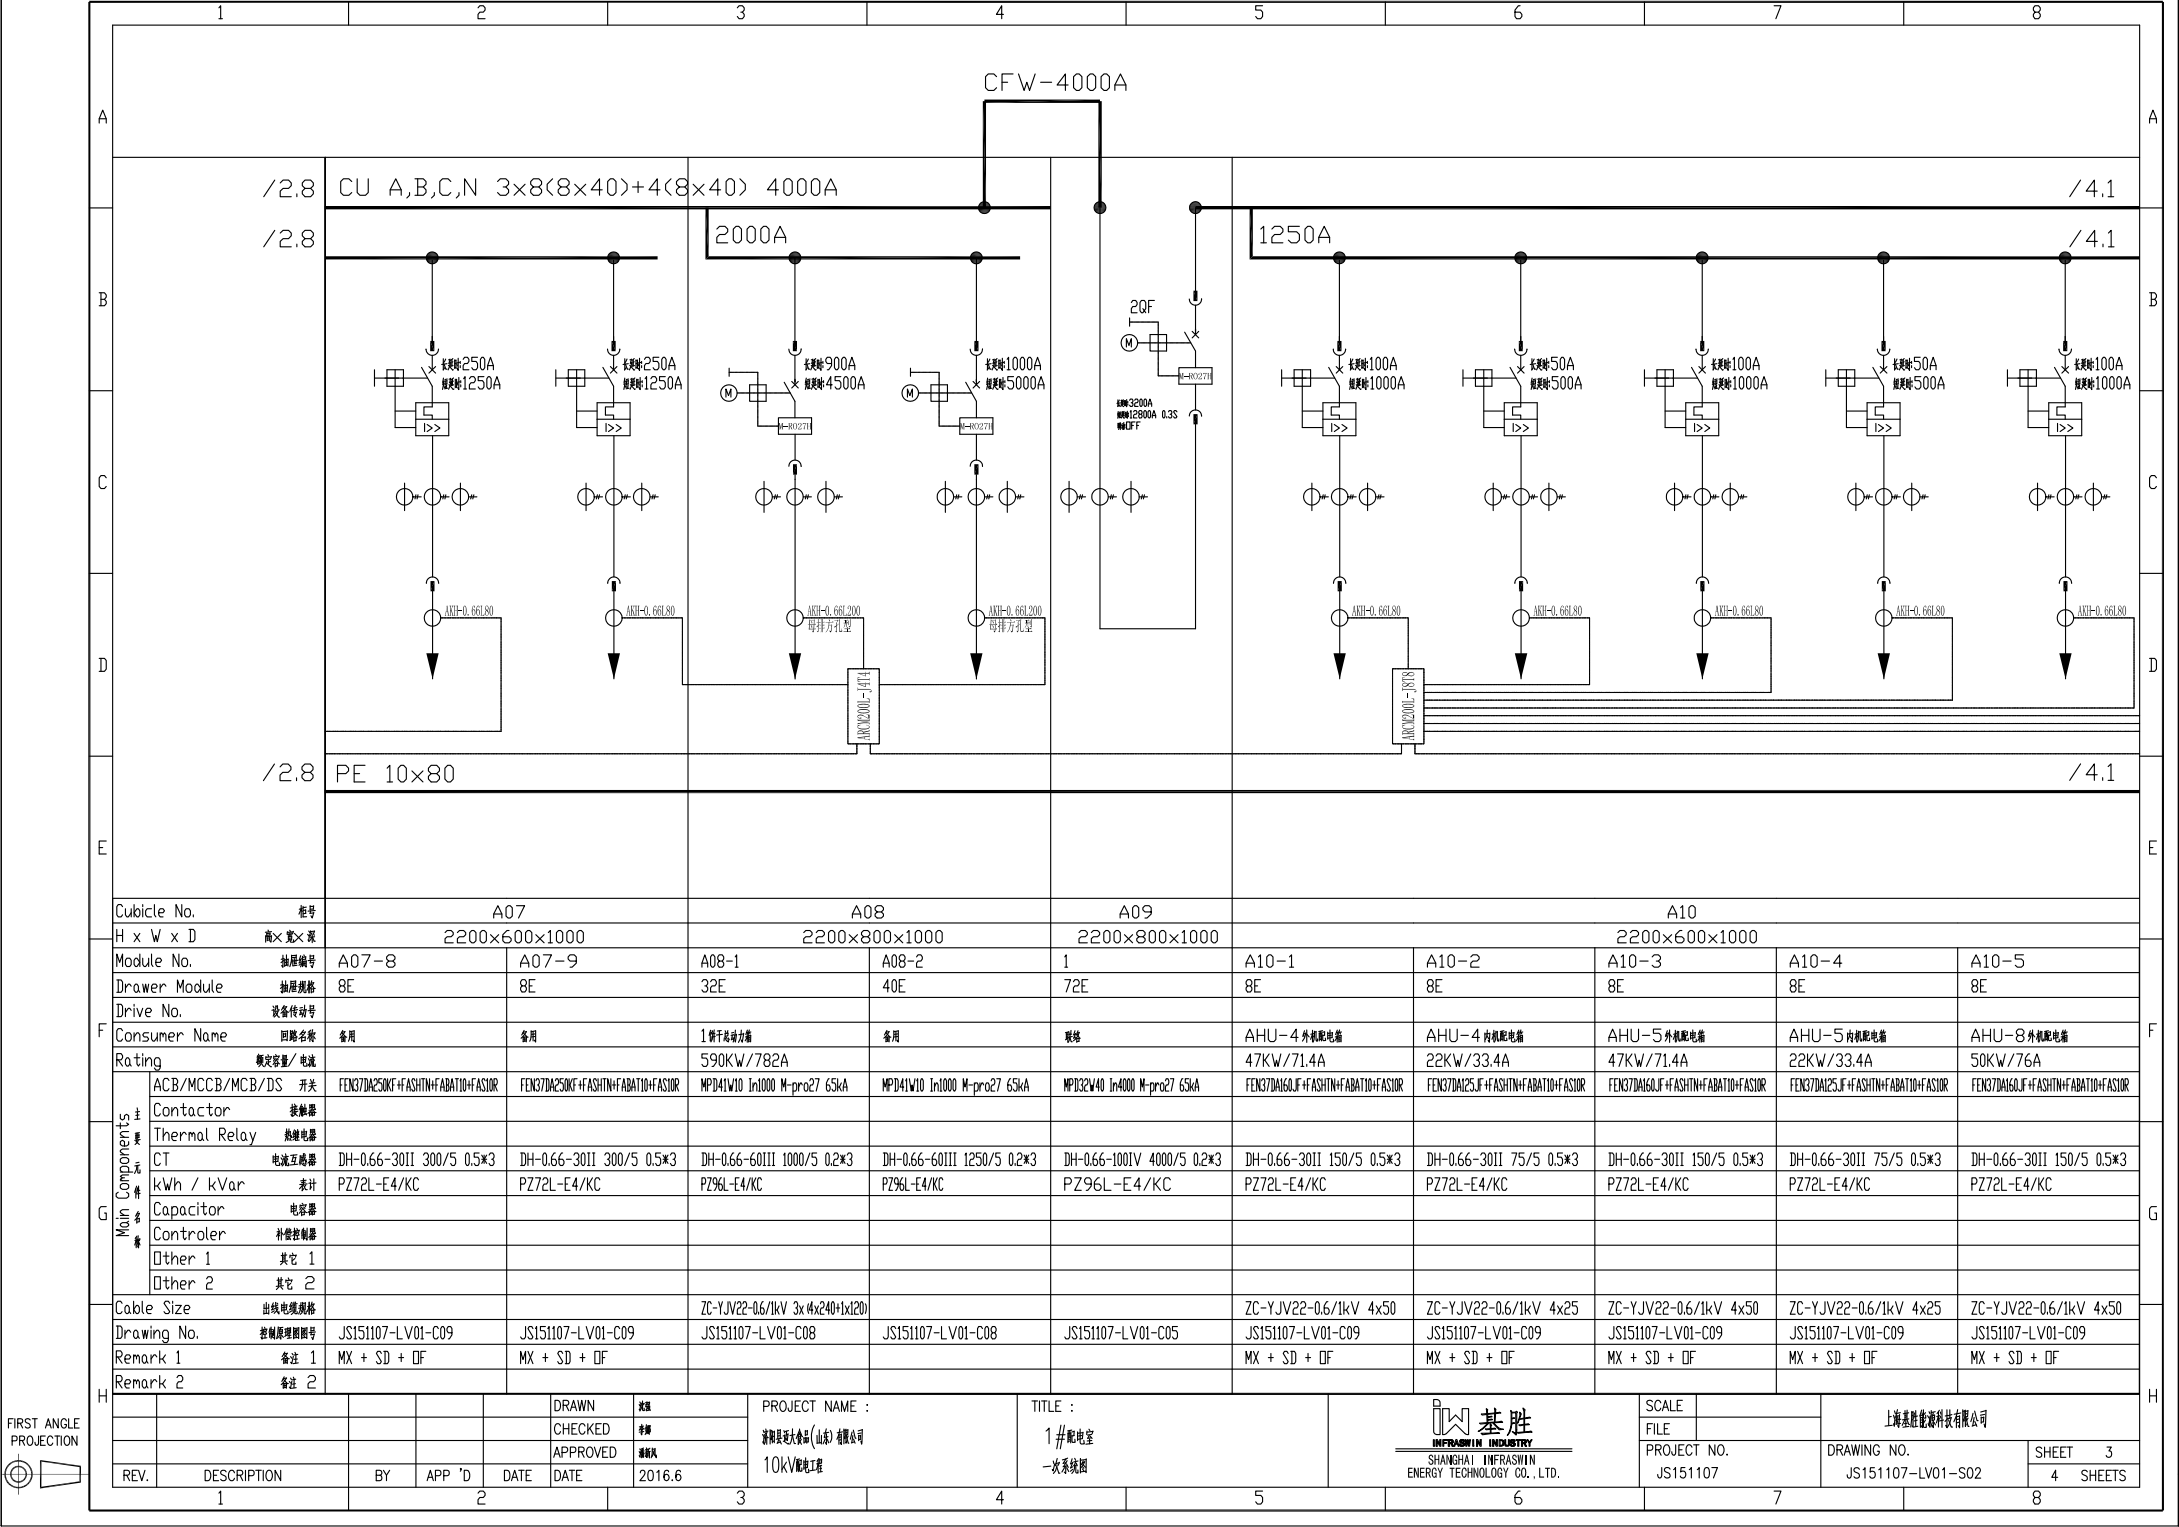

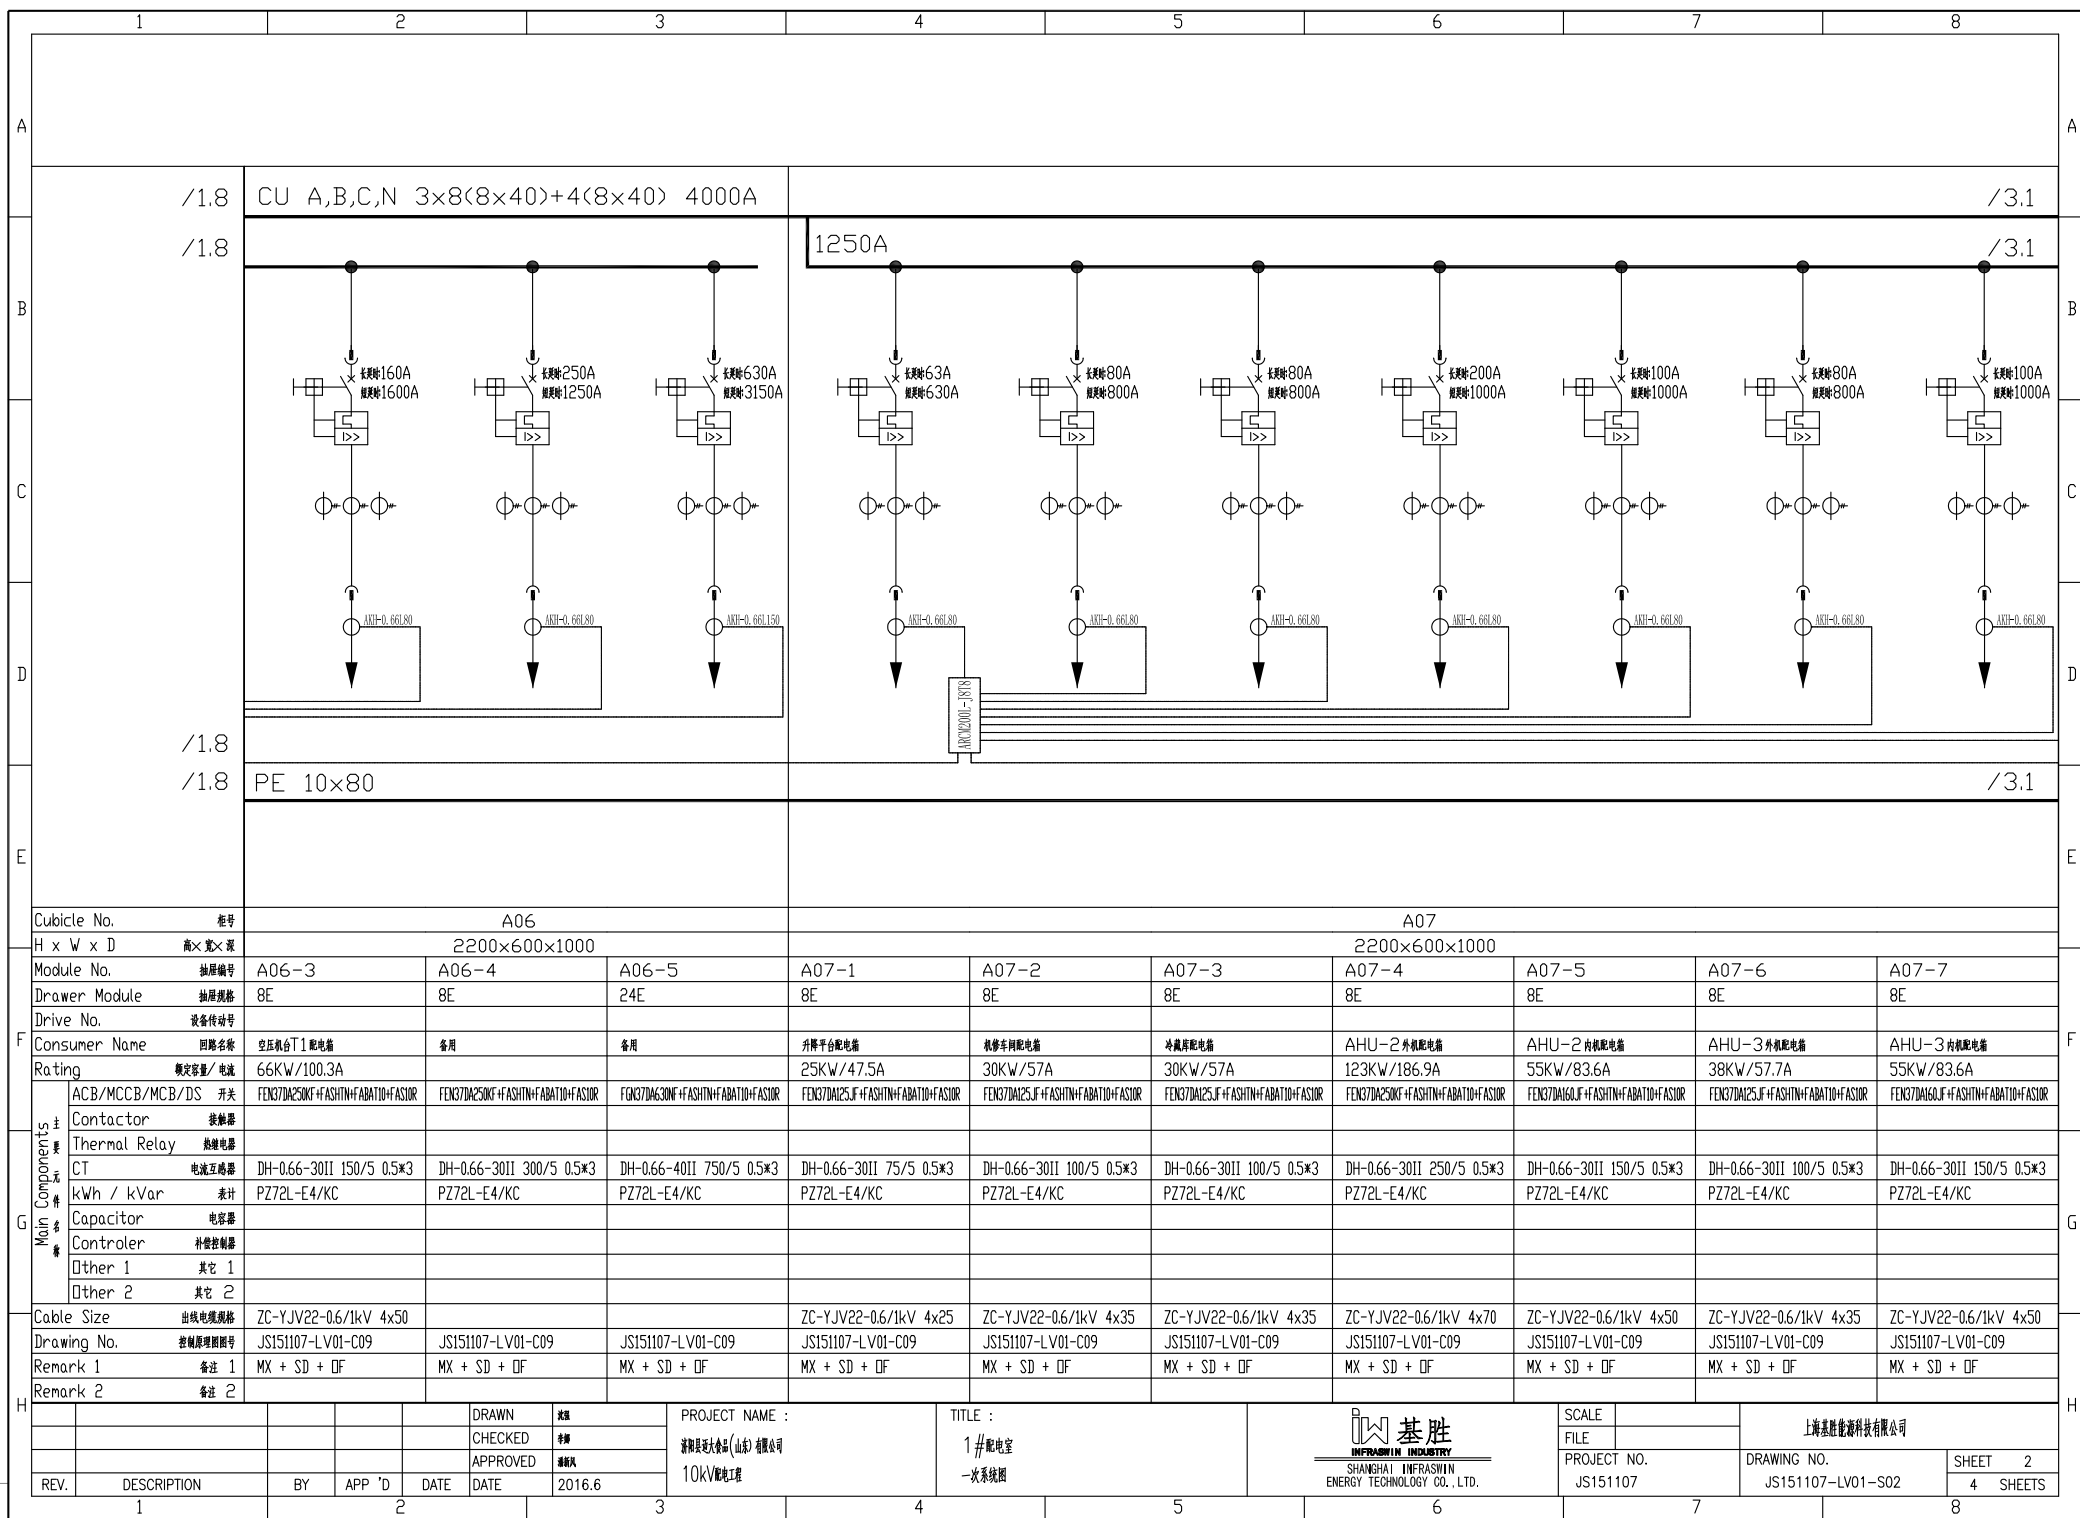



FIRST ANGLE
PROJECTION

1		2		3		4		5		6		7		8	
A		B		C		D		E		F		G		H	
/1.8		/1.8		CU A,B,C,N 4×2(8×30) 1000A											
/1.8		/1.8		PE 8×40		SFR-LXD-20/250 SFR-LXD-30/250 SFR-LXD-1010/450 SFR-LXD-2020/450*2		16 / 35²		16²		L1-3 N		ZC-YJV22-8.7/15-3×70mm²	
Cubicle No.		柜号		D4		D5		D6		T					
H x W x D		高×宽×深		2200×600×1000		2200×800×1000		2200×800×1000		2200×1600×1200					
Module No.		抽屉编号		D4-4		D4-5		1		1					
Drawer Module		抽屉规格		16E		16E		72E		72E					
Drive No.		设备传动号													
Consumer Name		回路名称		备用		备用		电容补偿		电容补偿		电容补偿			
Rating		额定容量/ 电流				150kvar		500KVA		500KVA					
ACB/MCCB/MCB/DS 开关		FGK37DM400LF+ASHTN+FBAT10+FASSOR		FGK37DM400LF+ASHTN+FBAT10+FASSOR		QSA-400A/3P 400A		MPD31W10 In1000 M-pro27 65kA							
Contactor 接触器															
Thermal Relay 热继电器						HY3W-0.28/1.3*3									
CT 电流互感器		DH-0.66-301I 400/5 0.5*3		DH-0.66-301I 400/5 0.5*3		DH-0.66-301I 400/5 0.5*3		DH-0.66-601III 1000/5 0.2*6							
kWh / kVar 表计		PZ72L-E4/KC		PZ72L-E4/KC		8972-A 400/5		PZ96L-E4/KC							
Capacitor 电容器															
Controler 补偿控制						WGG-31-201-F									
Other 1 其它 1								CP-100/4P							
Other 2 其它 2								G64C63							
Cable Size 出线电缆规格															
Drawing No. 控制原理图图号		JS151107-LV01-C09		JS151107-LV01-C09		JS151107-LV01-C15		JS151107-LV01-C03		JS151107-LV01-C18					
Remark 1 备注 1		MX + SD + DF		MX + SD + DF				3TA1-3 1000/5 0.5S							
Remark 2 备注 2						MFDD10-68A,B,FK6625-230*2									
REV.		DESCRIPTION		BY		APP 'D		DATE		DRAWN 制图		CHECKED 审核		APPROVED 审核	
1								2016.6		PROJECT NAME : 浪潮昇远大数据(山东)有限公司 10kV配电工程		TITLE : 开关站 一次系统图		SHANGHAI INFRAWIN ENERGY TECHNOLOGY CO., LTD.	
SCALE		FILE		PROJECT NO.		DRAWING NO.		SHEET 2		SHEETS					
JS151107		JS151107-LV01-S01		2		2		2							